




"Star" Indicates AED Location

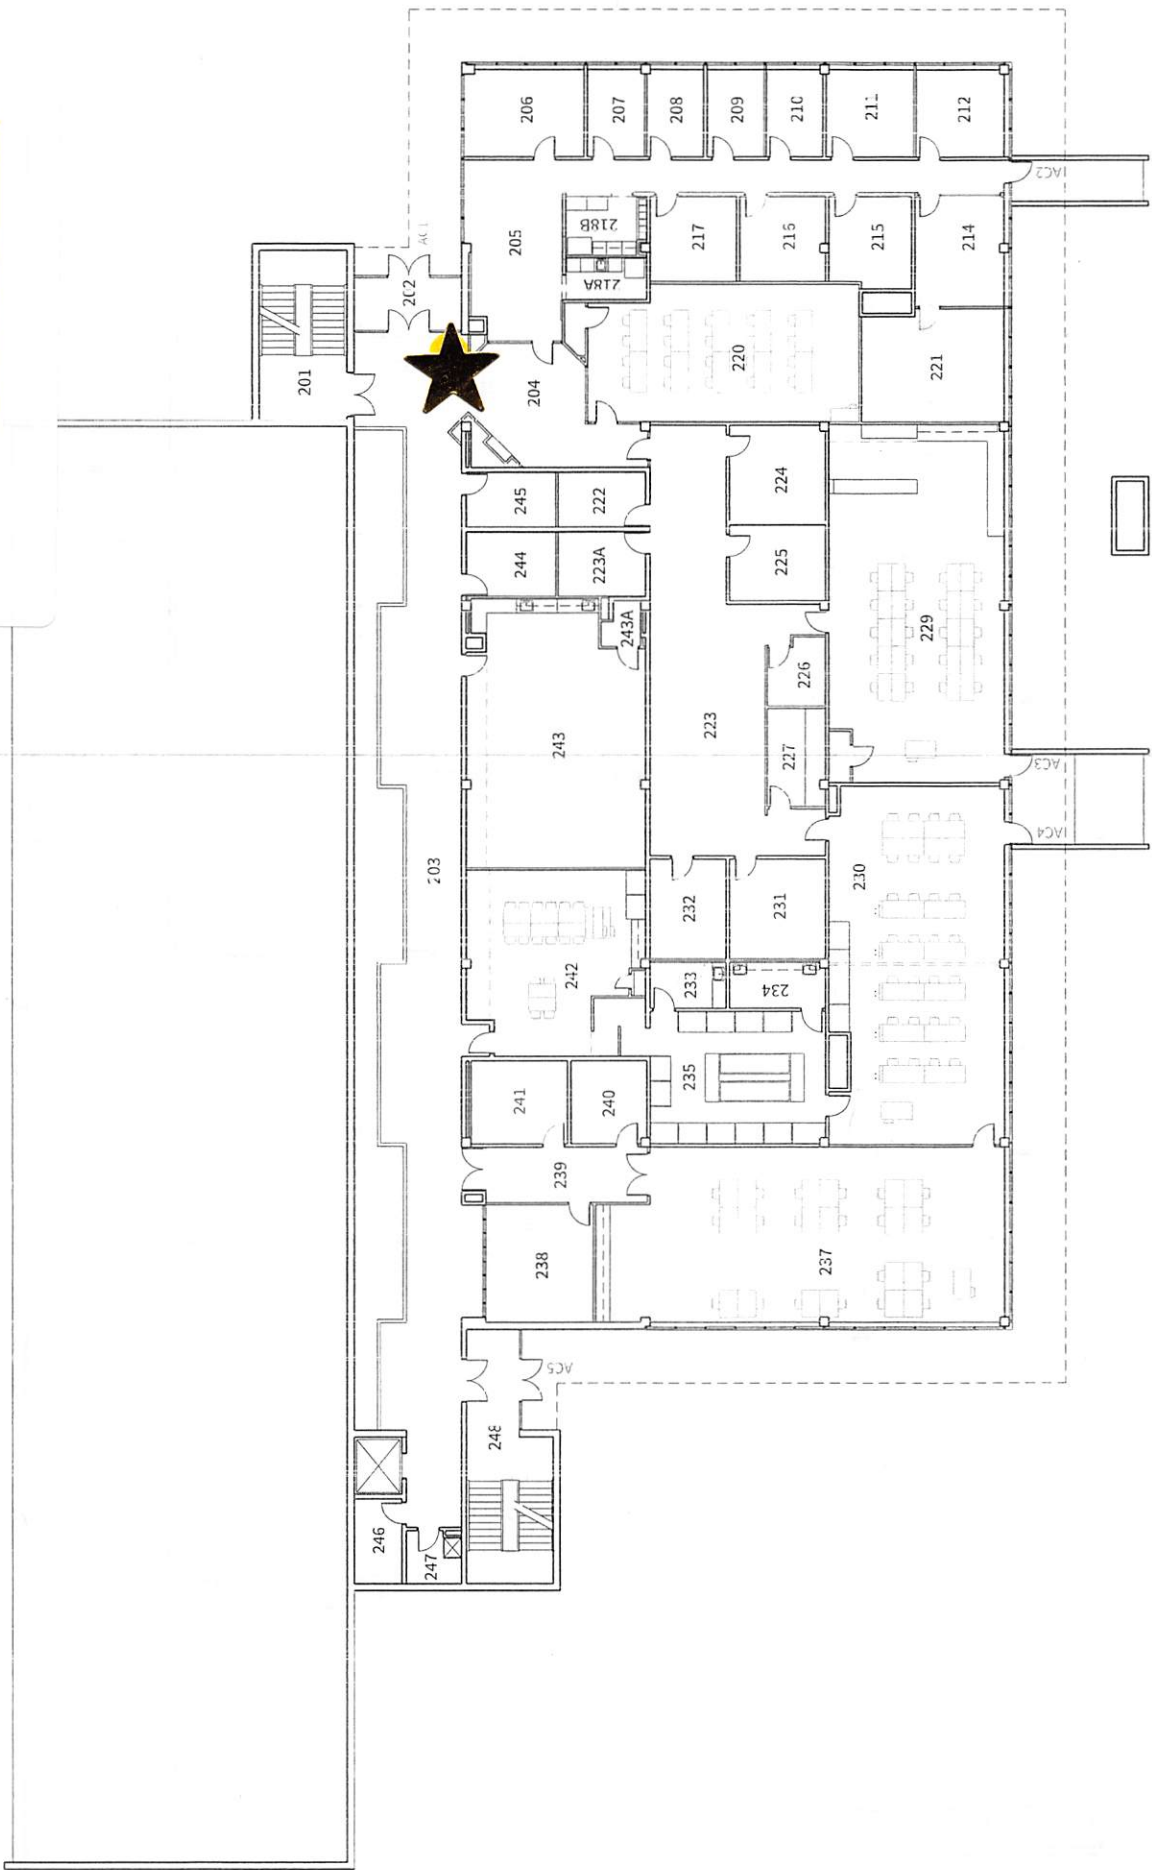

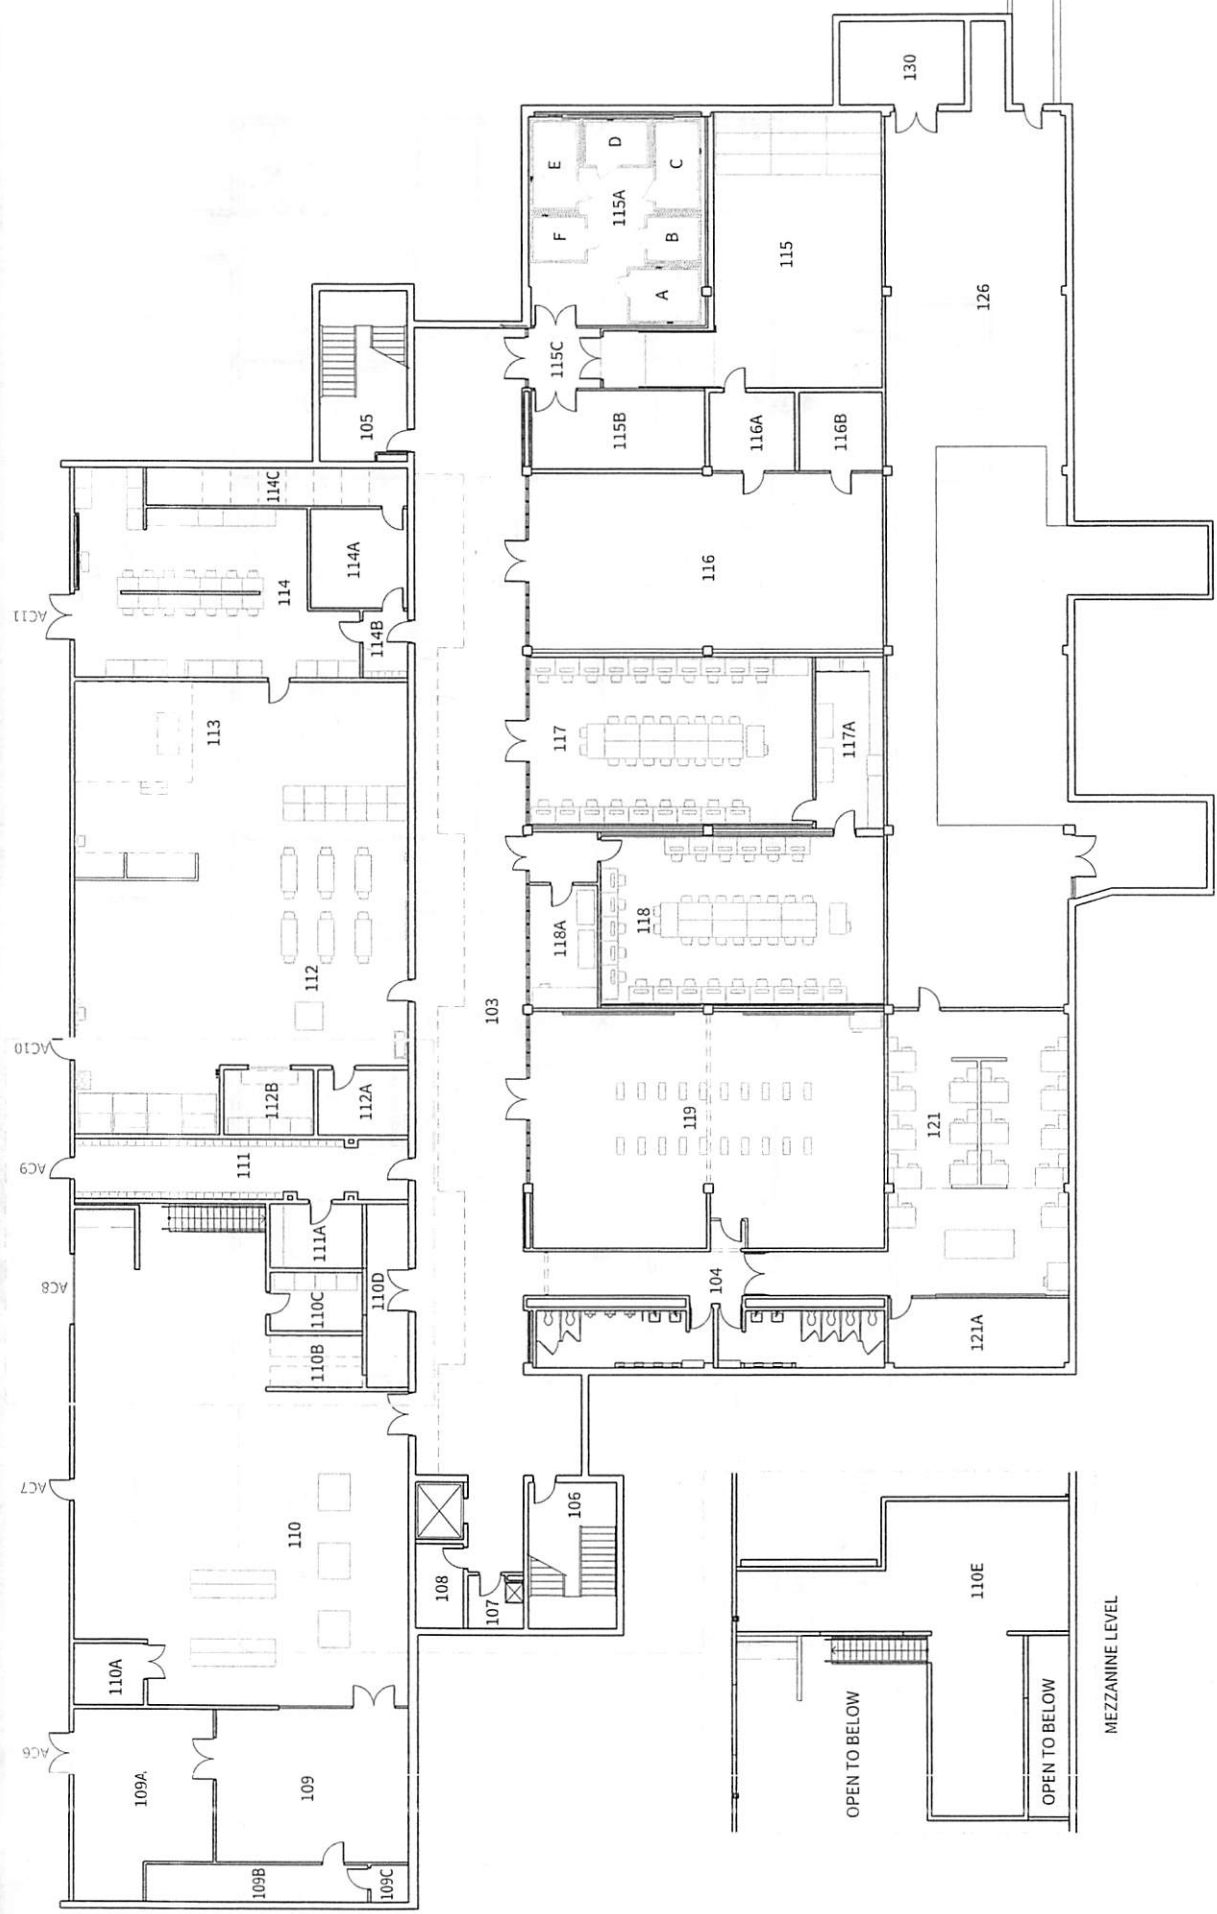

"Star" Indicates AED Location

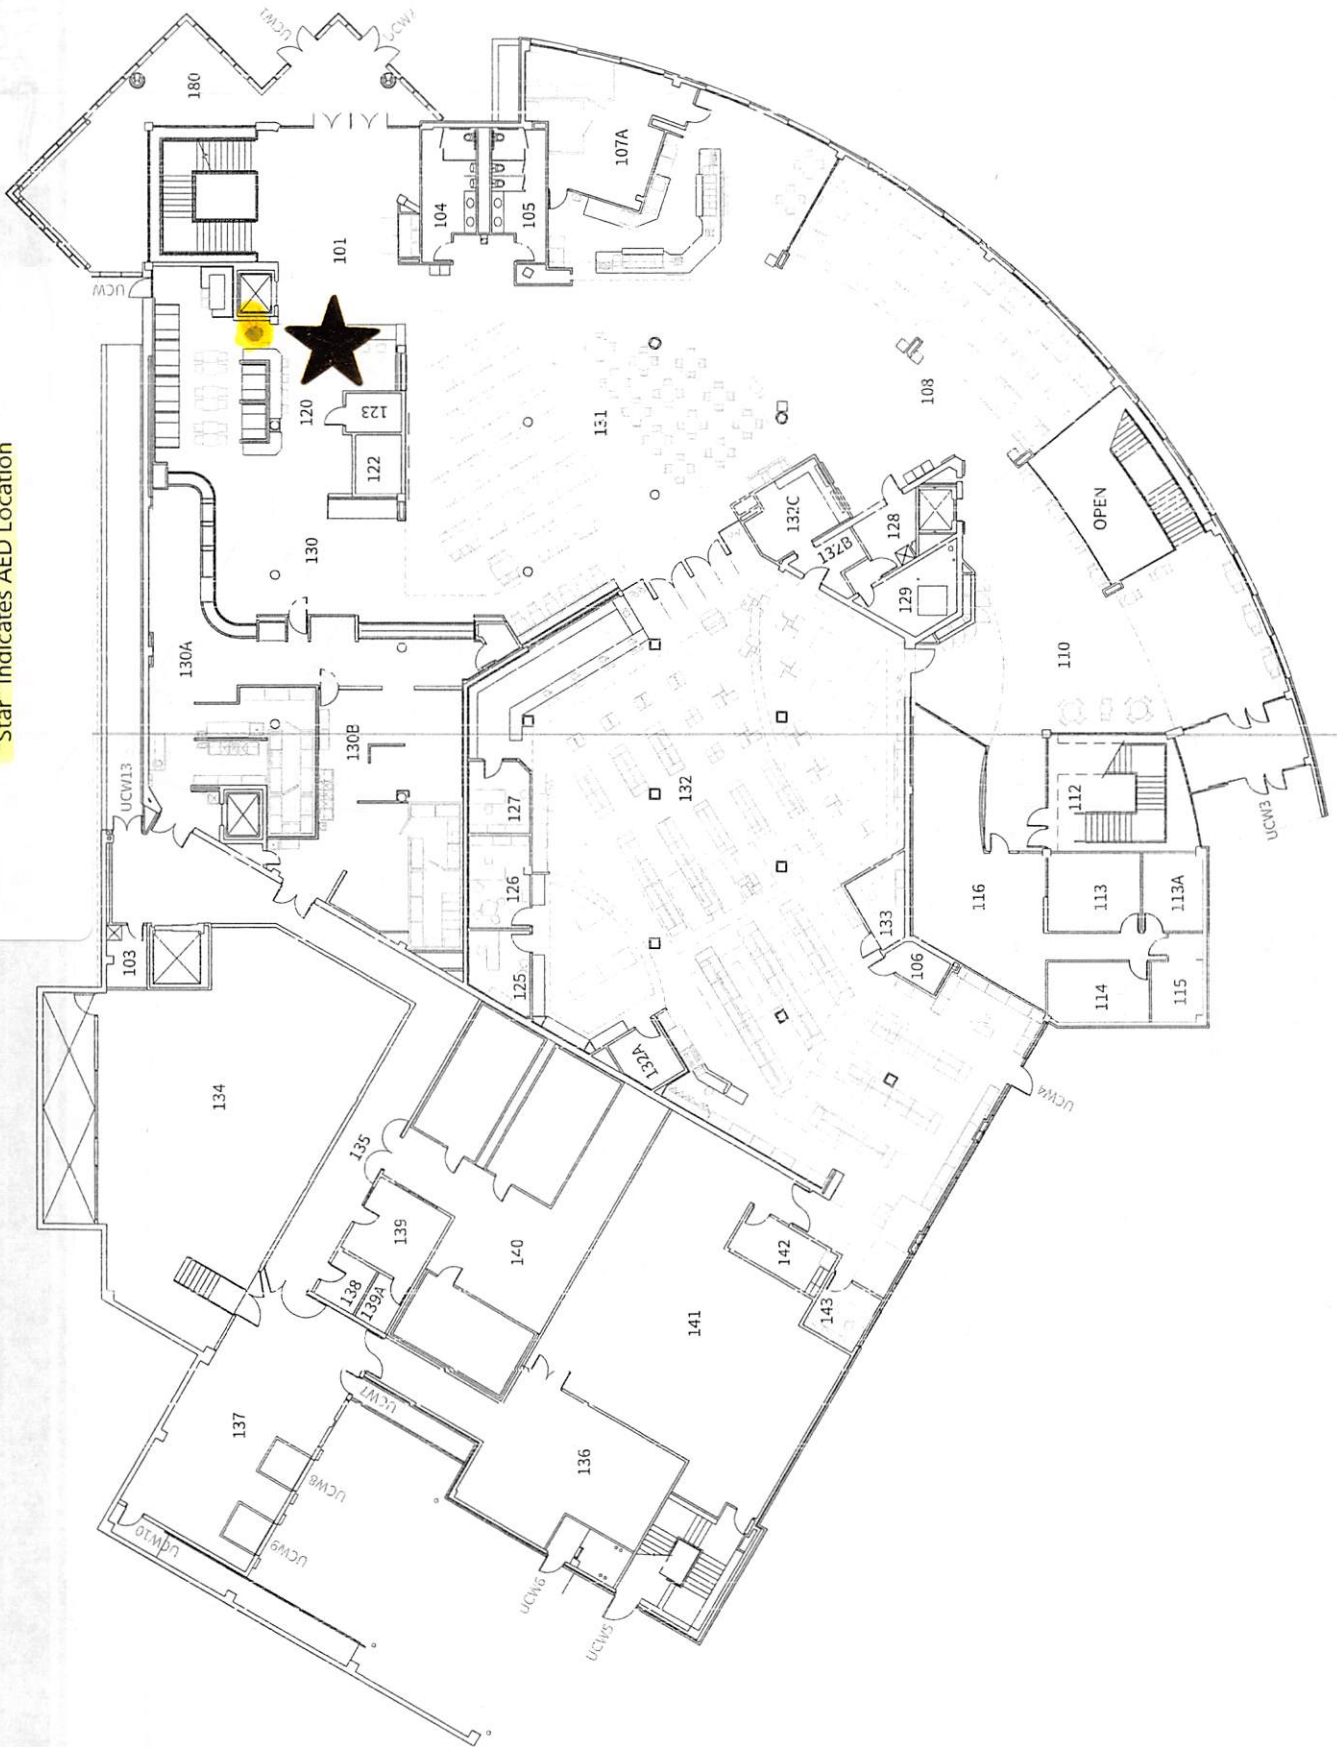





floor plan changed.  
Verify what exist.





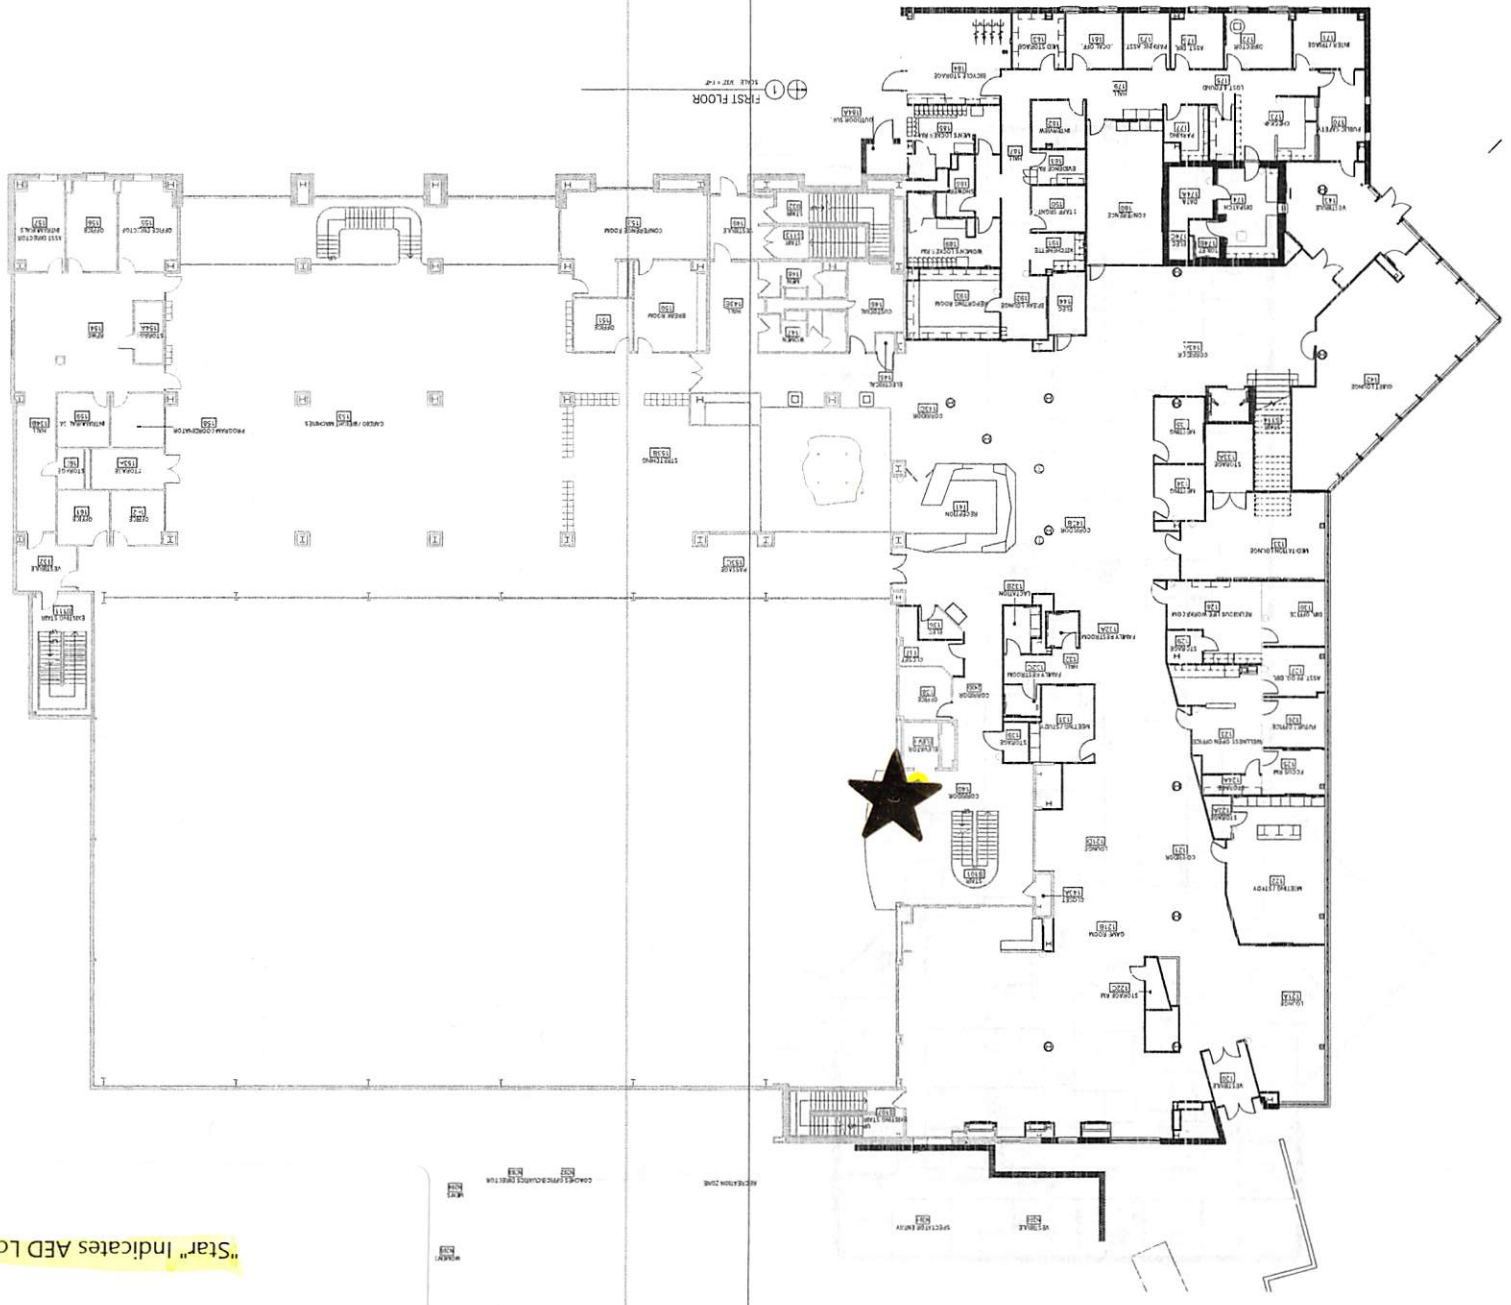


"Star" Indicates AED Location

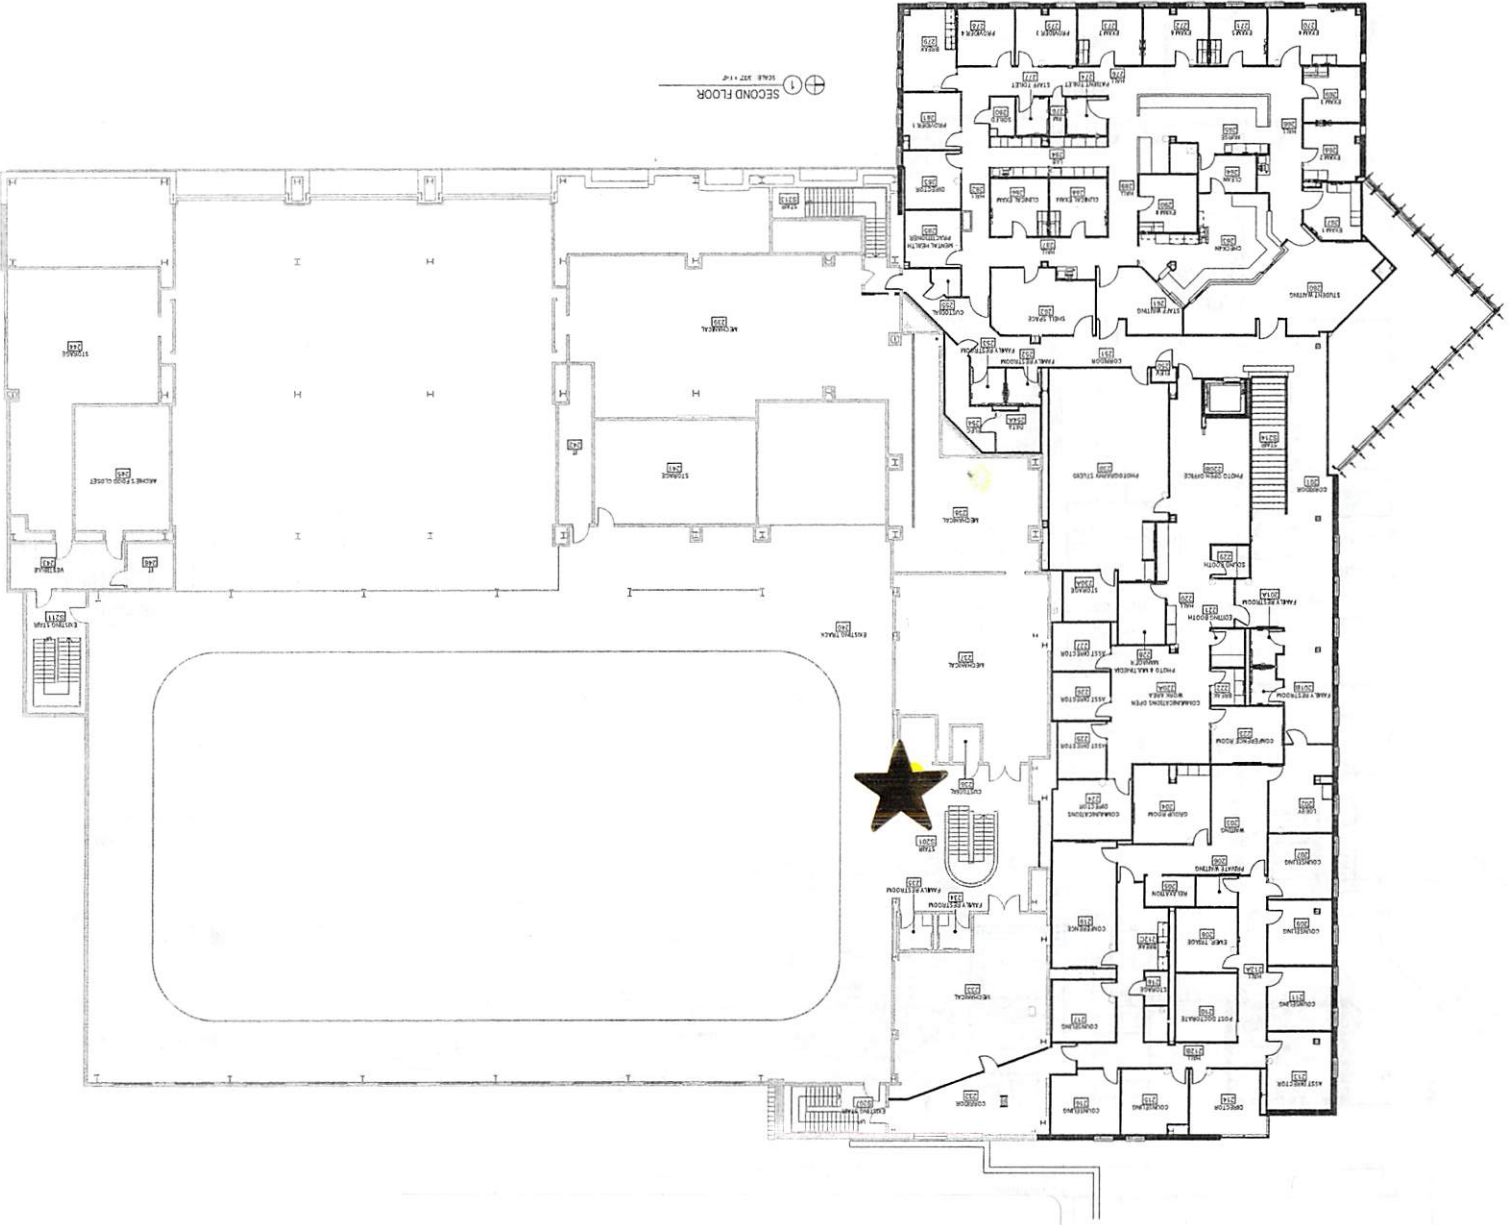


"Star" Indicates AED Location


"Star" Indicates AED Location

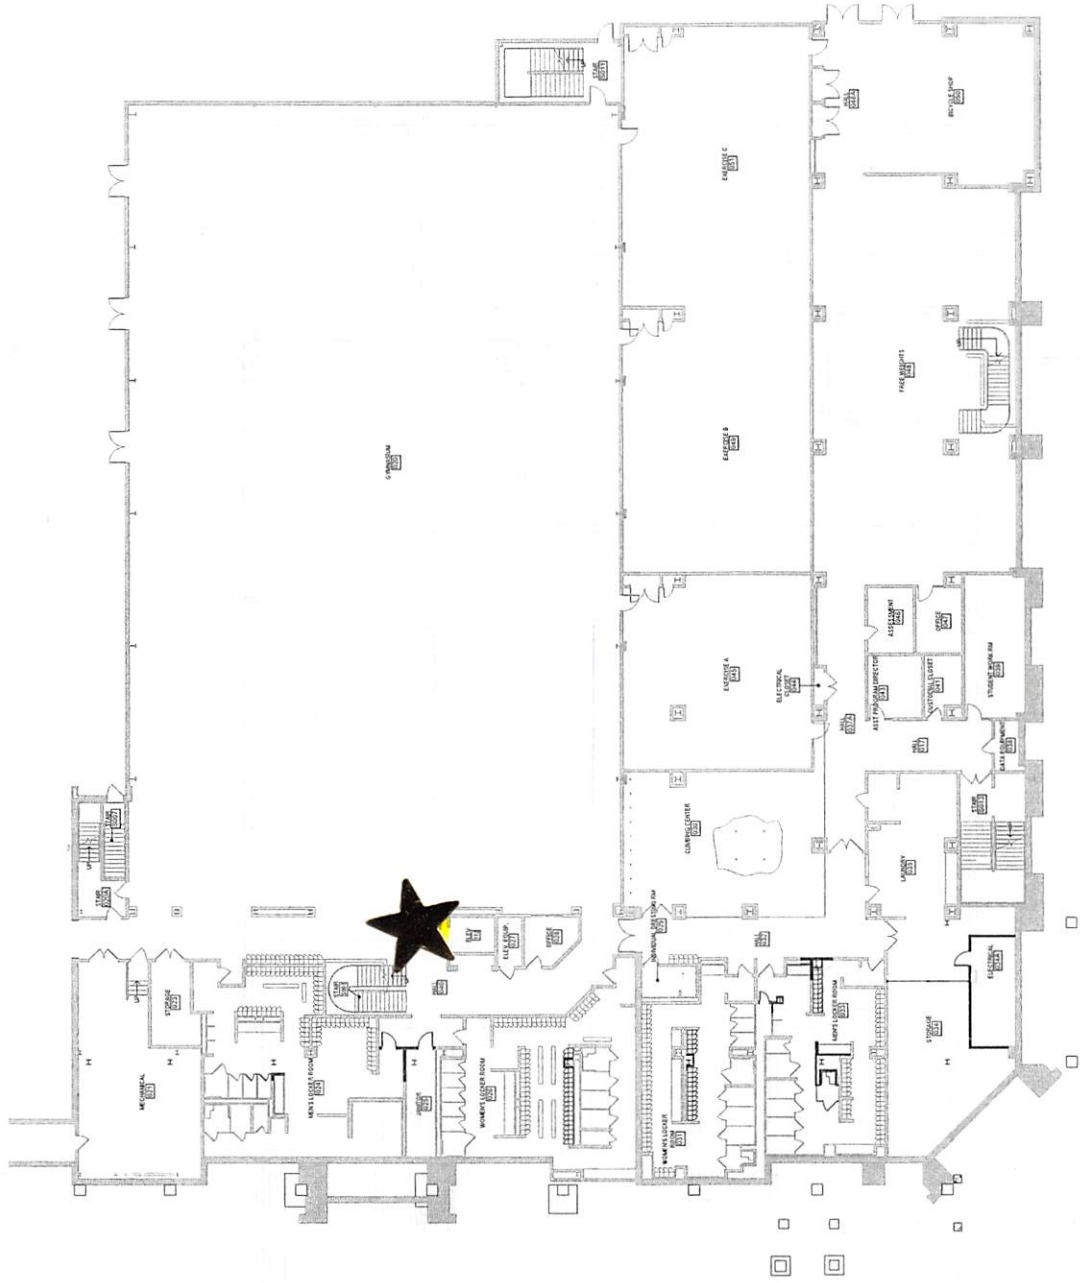

① LOWER LEVEL  
SCALE 1/8" = 1'-0"

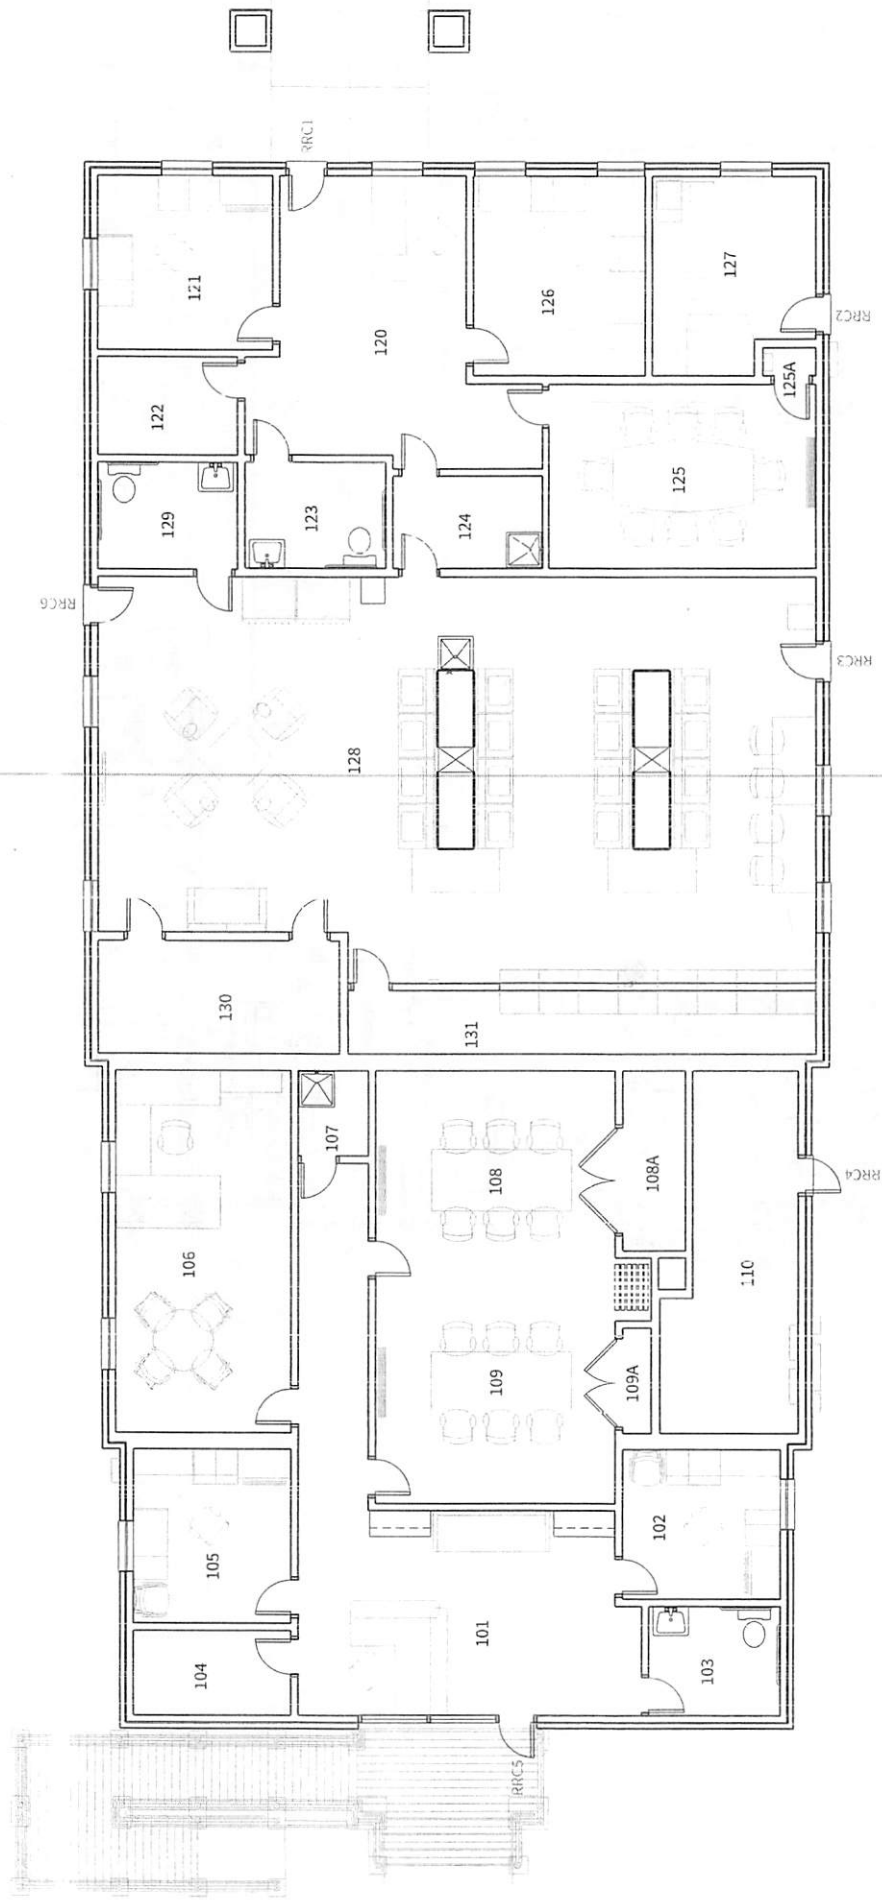




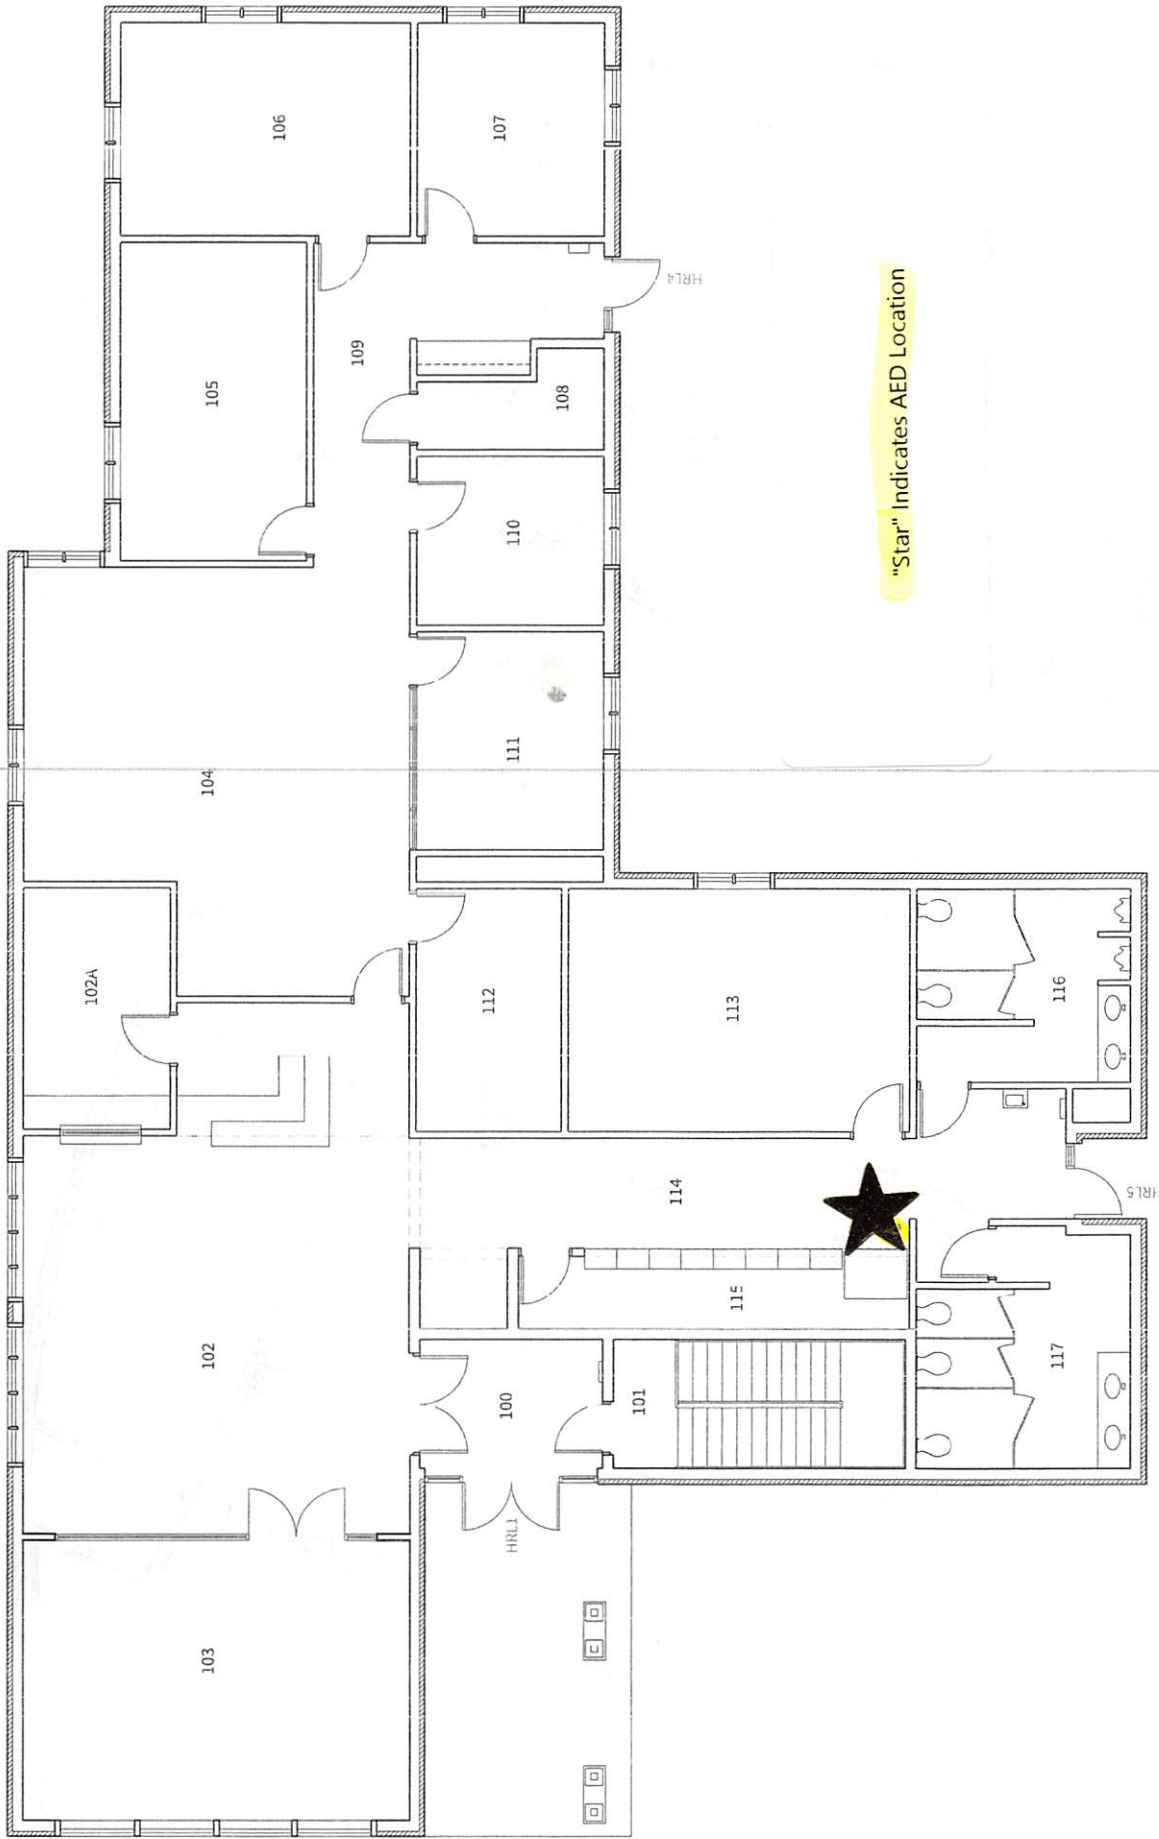


"Star" Indicates AED Location



"Star" Indicates AED Location

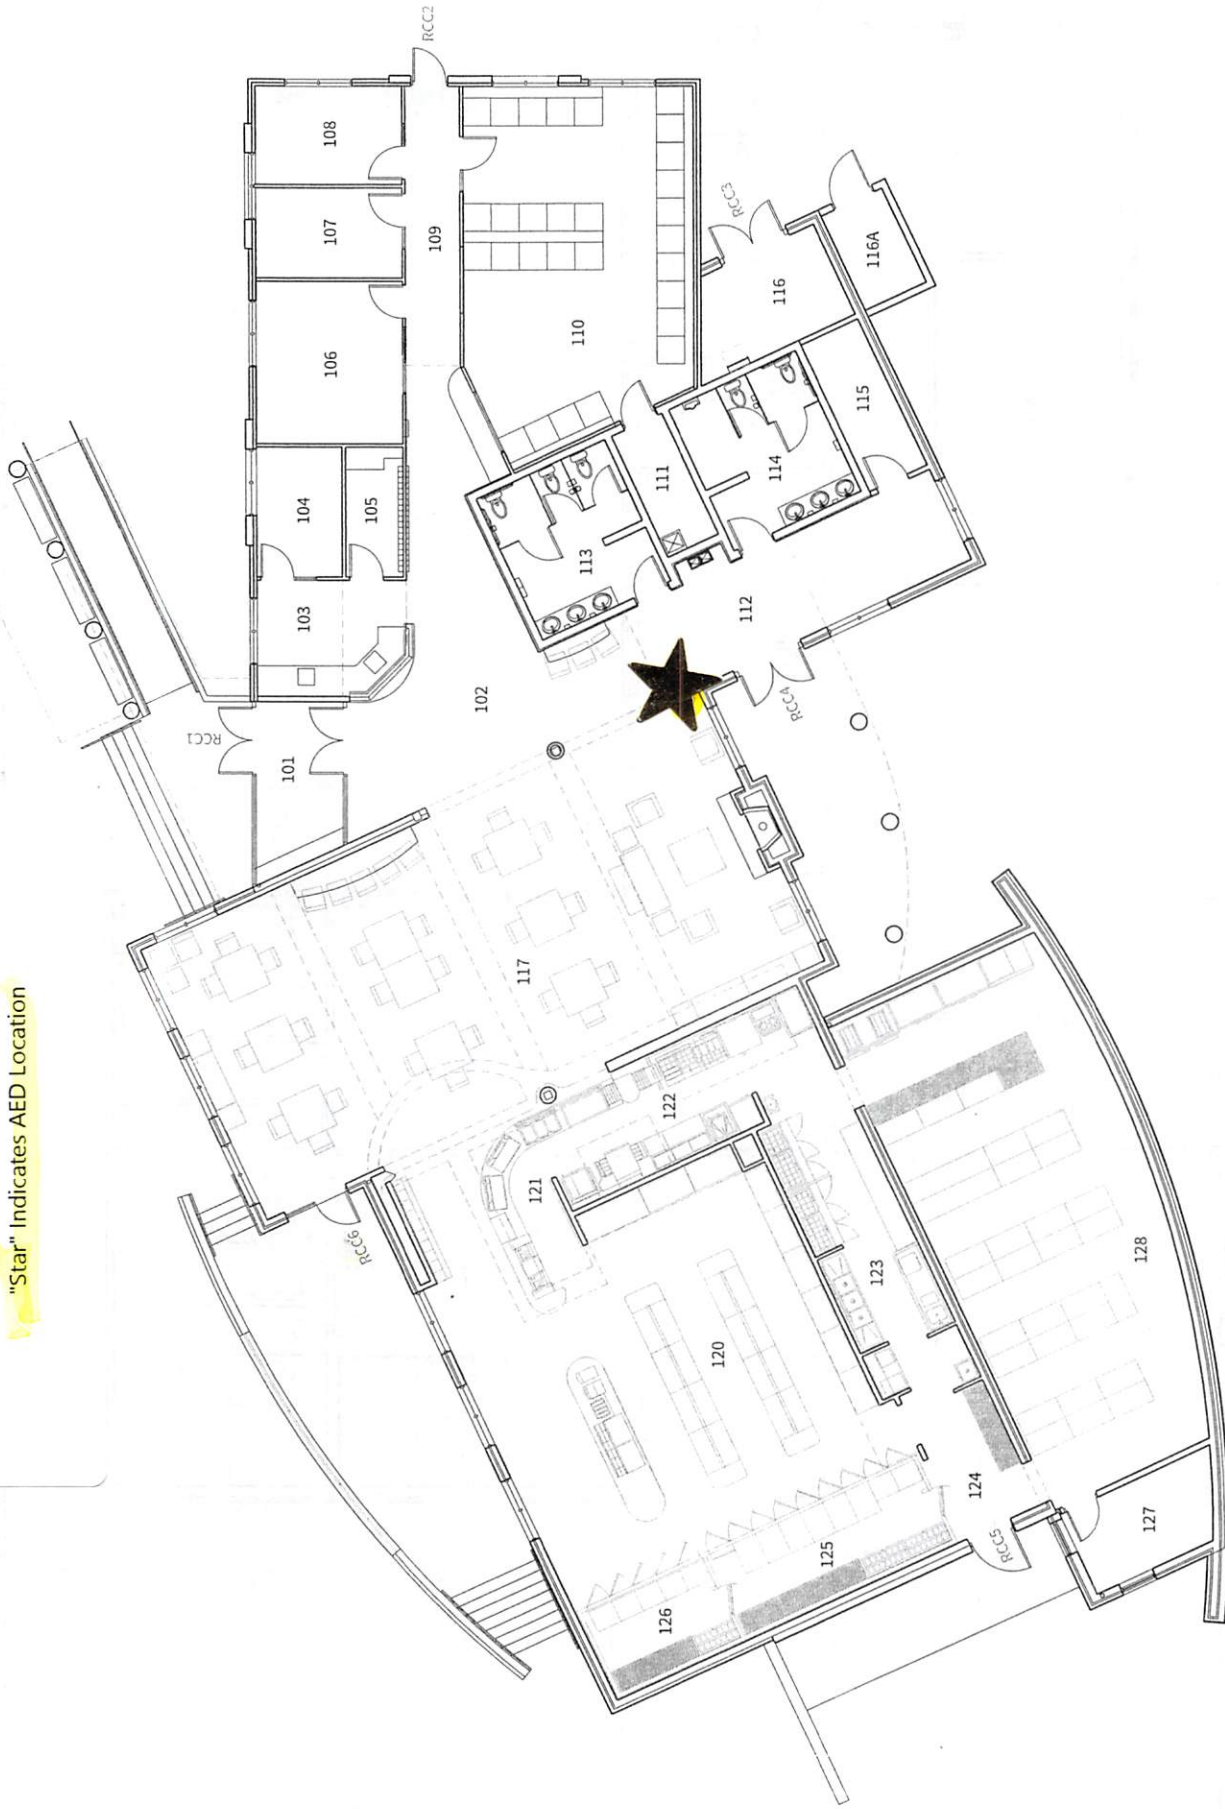


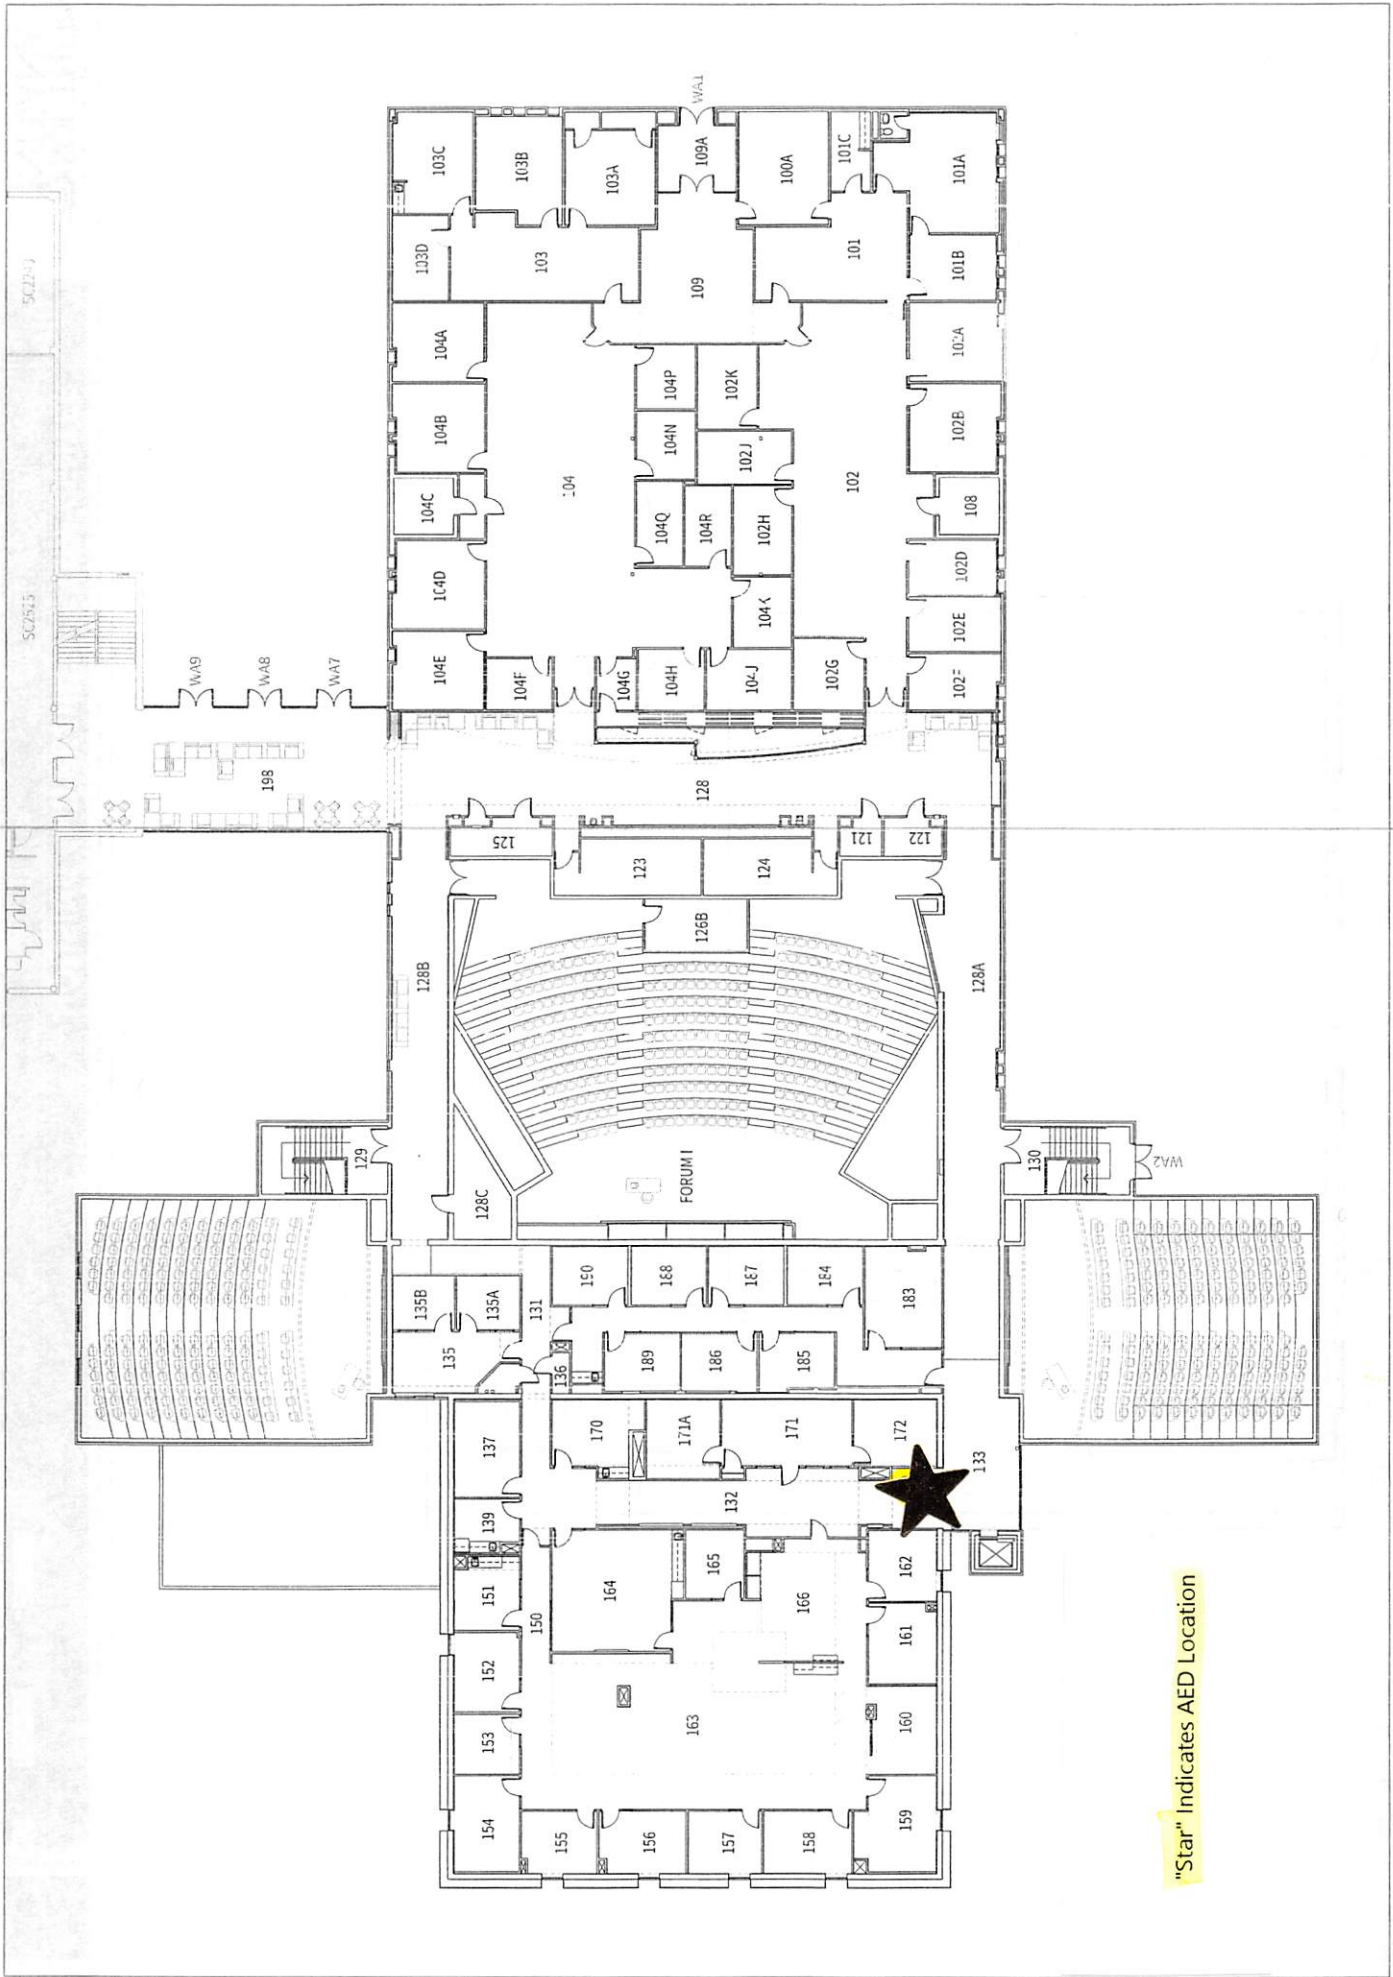

"Star" Indicates AED Location






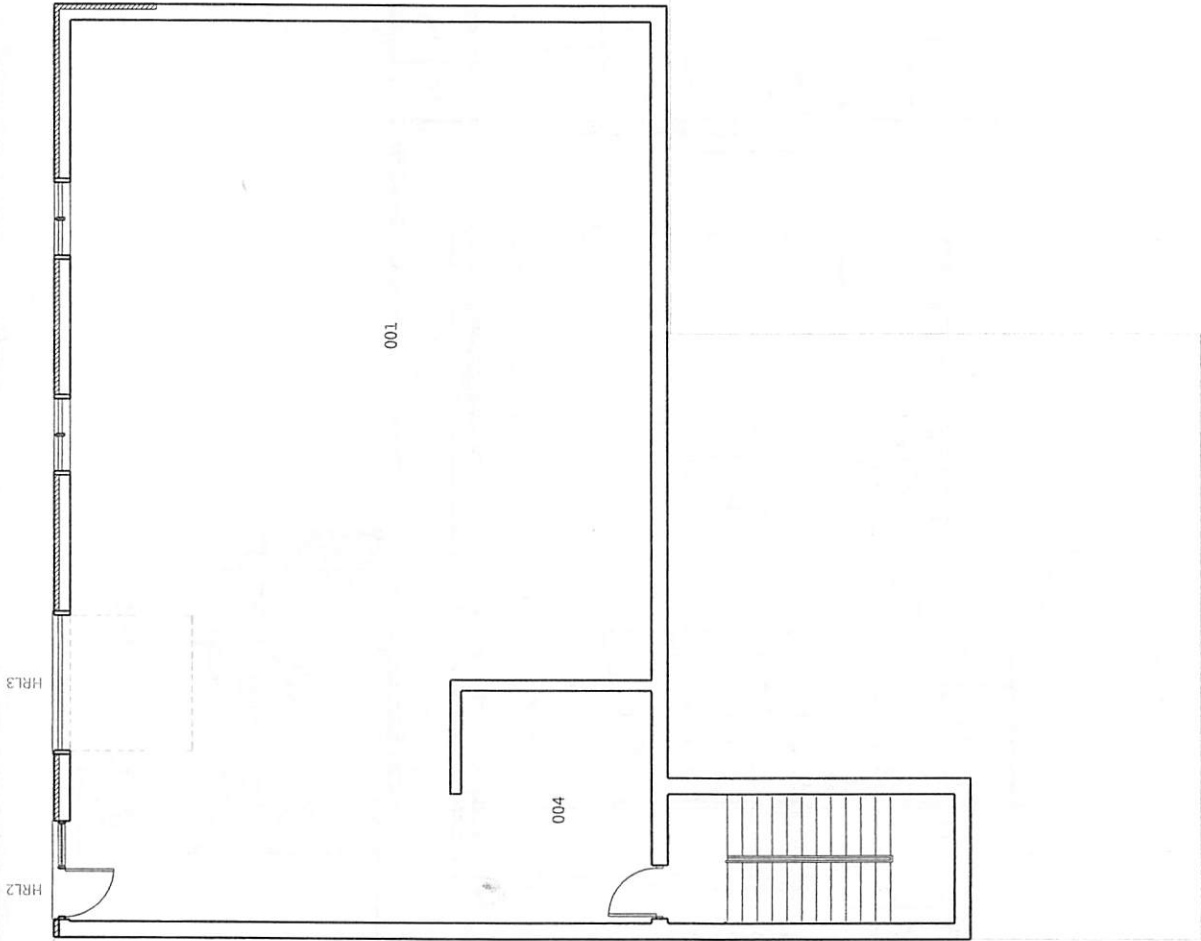







"Star" Indicates AED Location

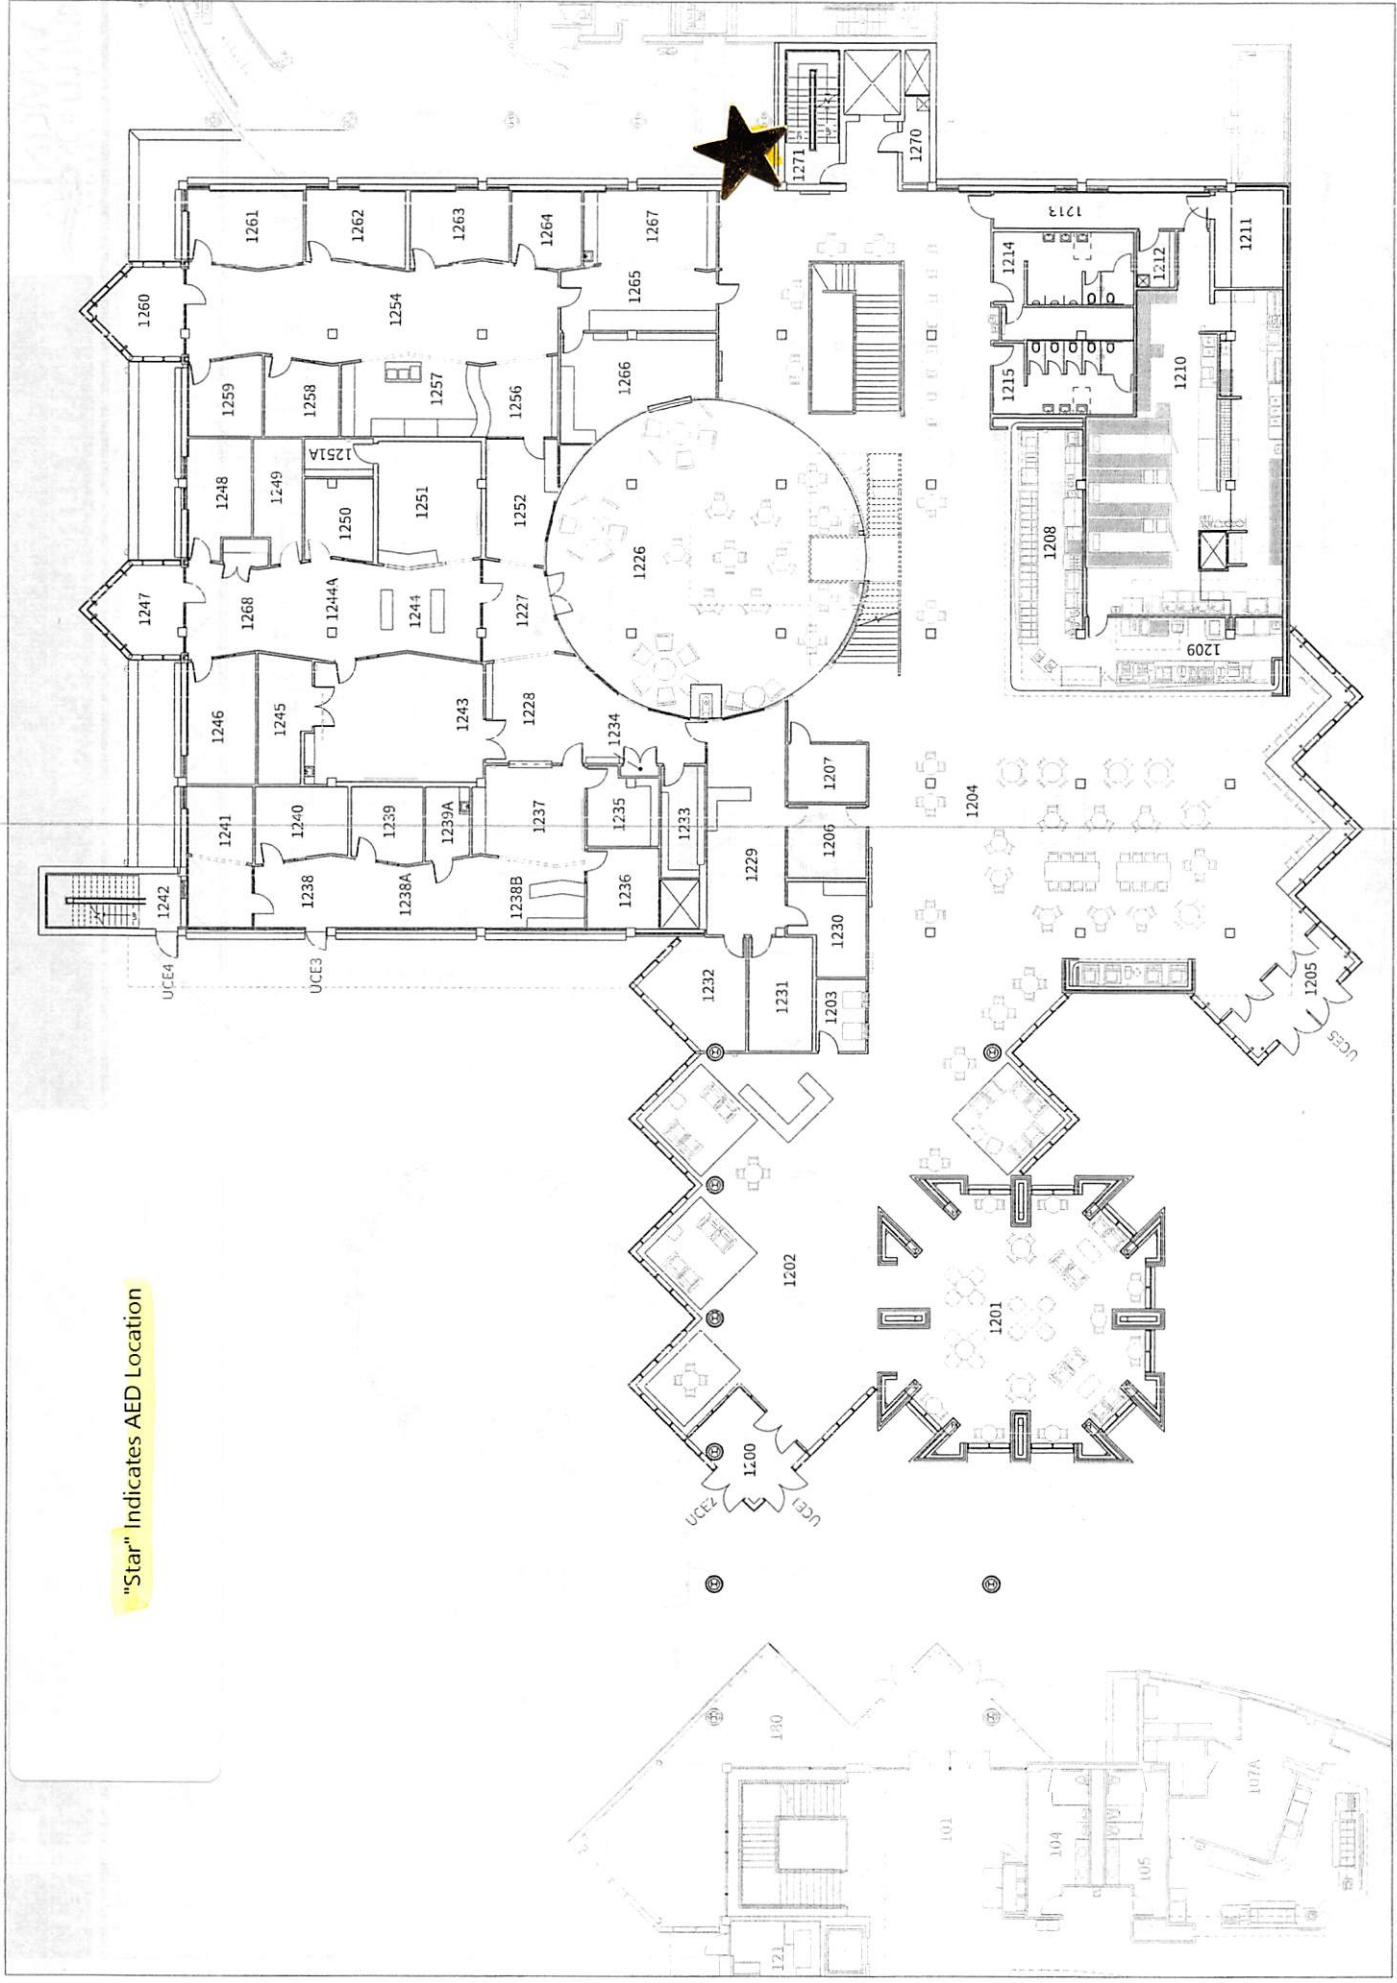

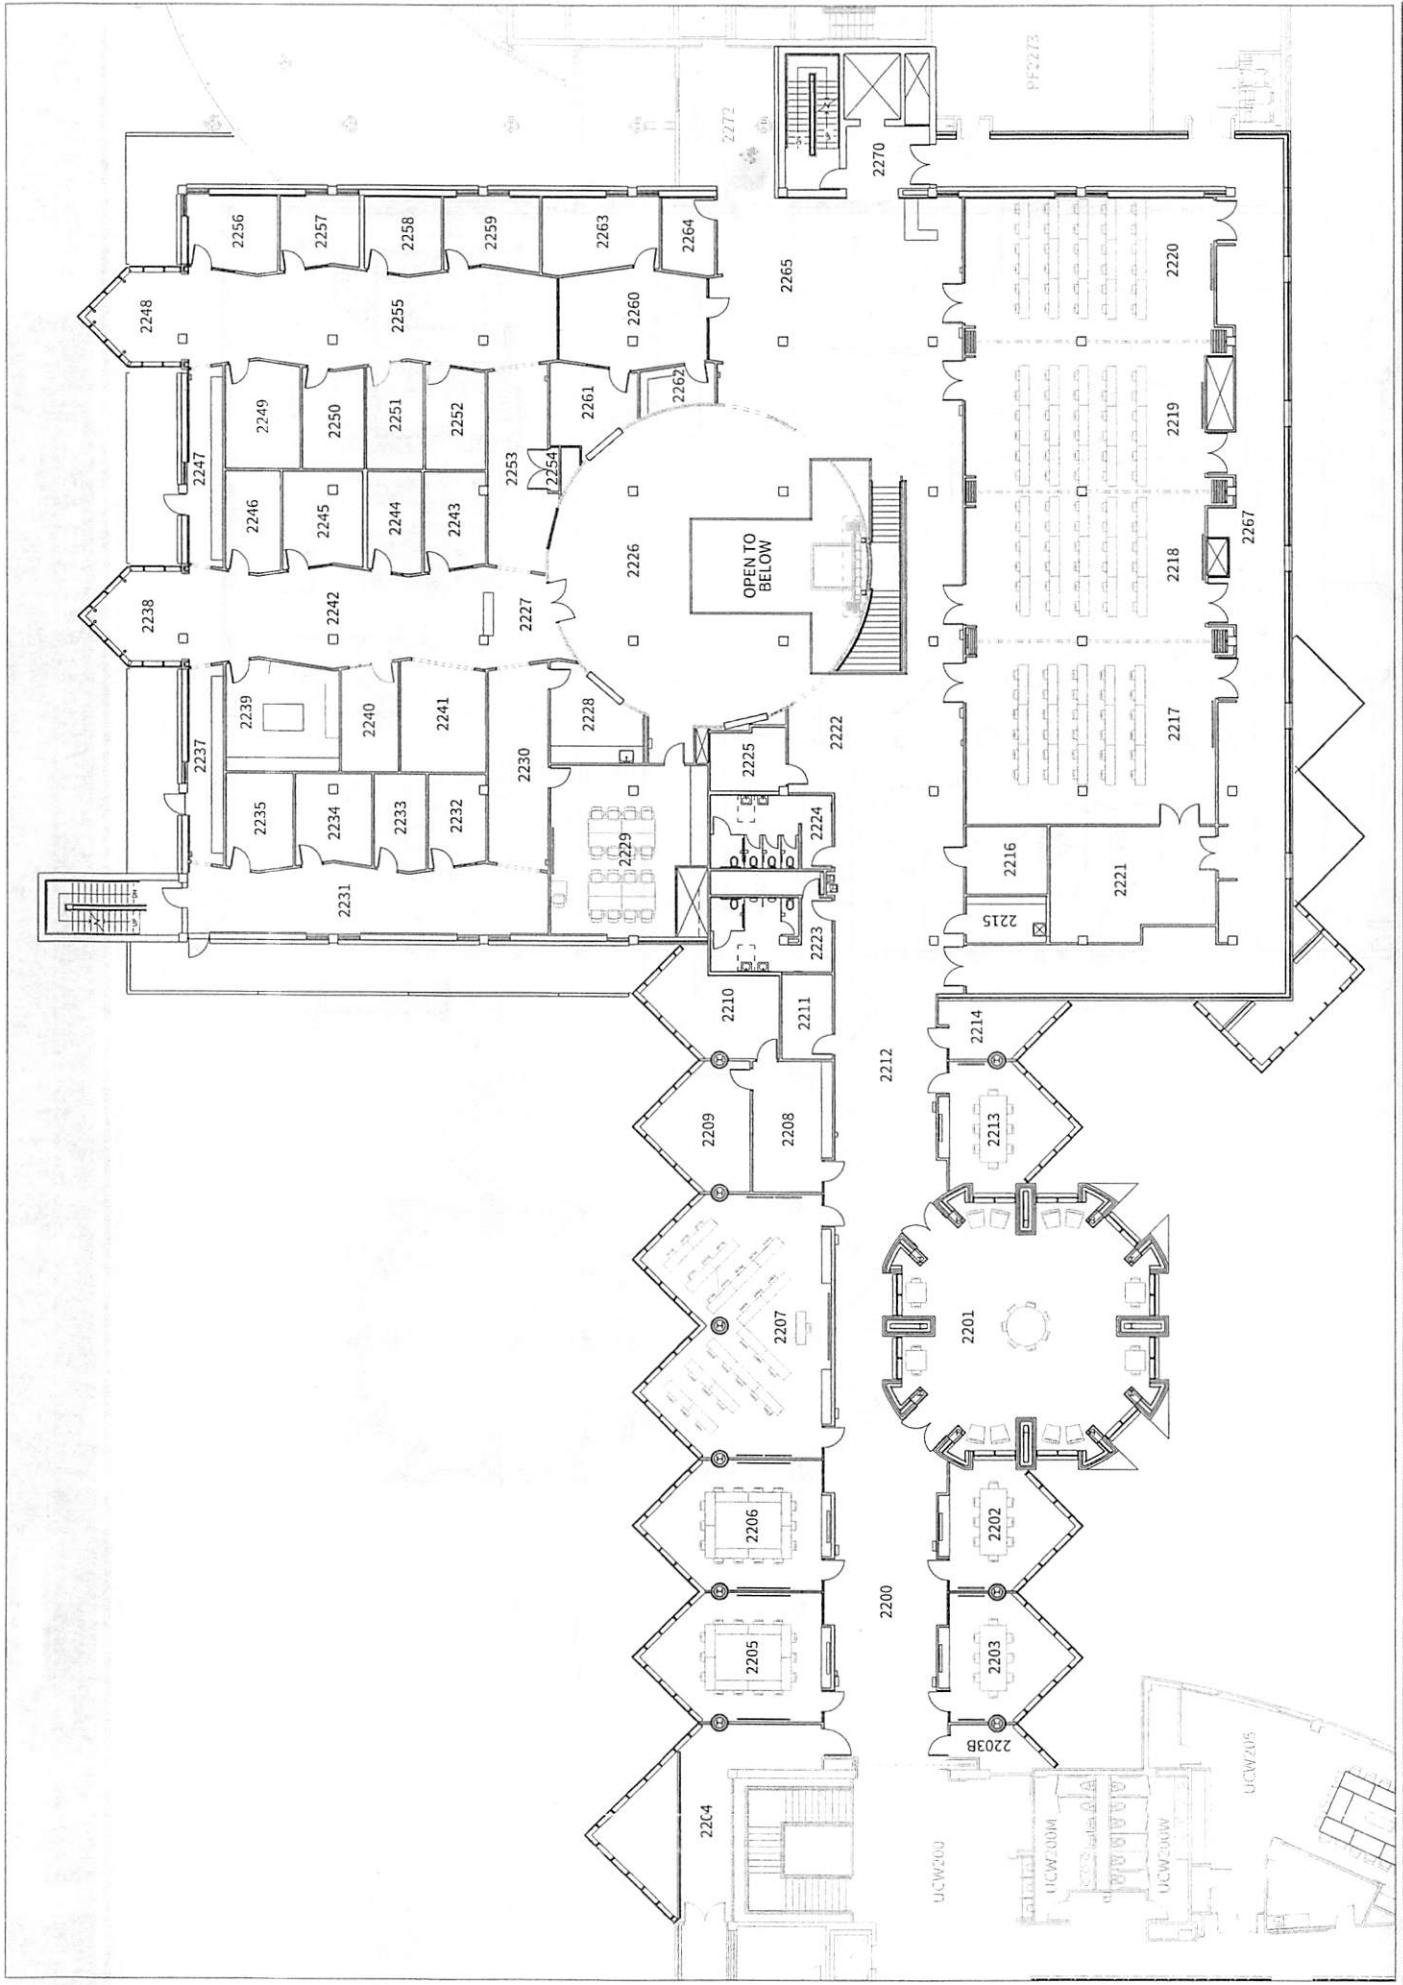

"Star" Indicates AED Location

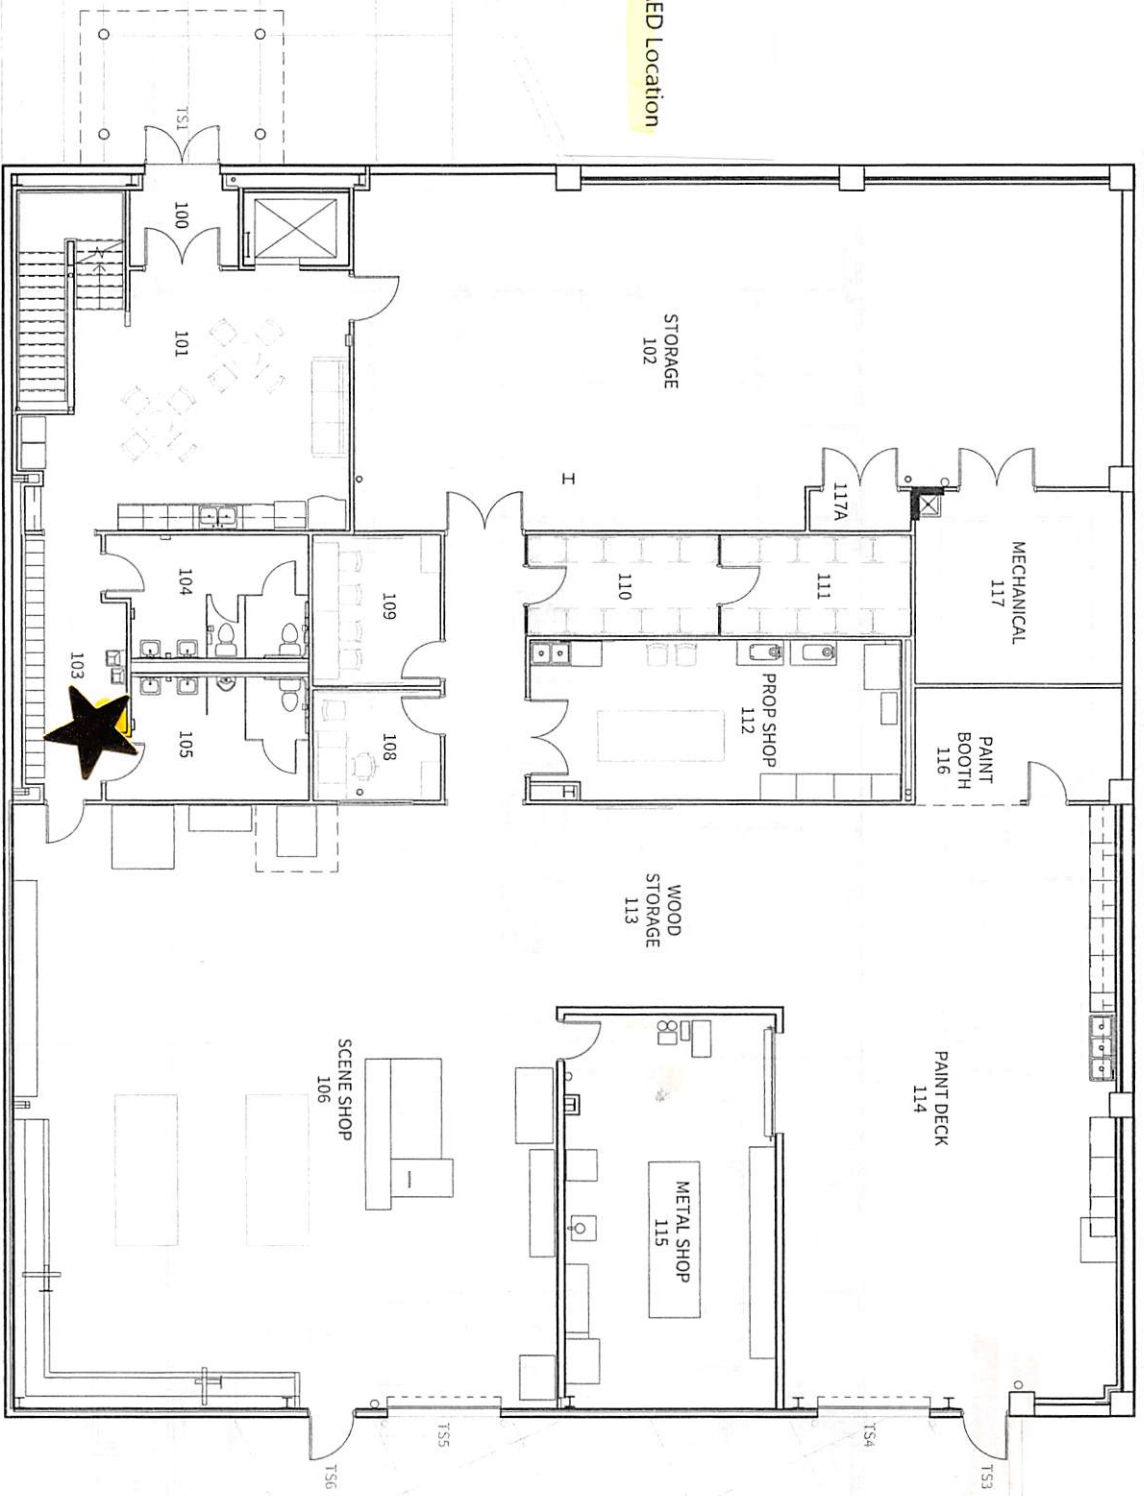

06.01.2020



**THEATRE SUPPORT CENTER**  
FIRST LEVEL FLOOR PLAN

**TS**








01.01.2022



"Star" Indicates AED Location

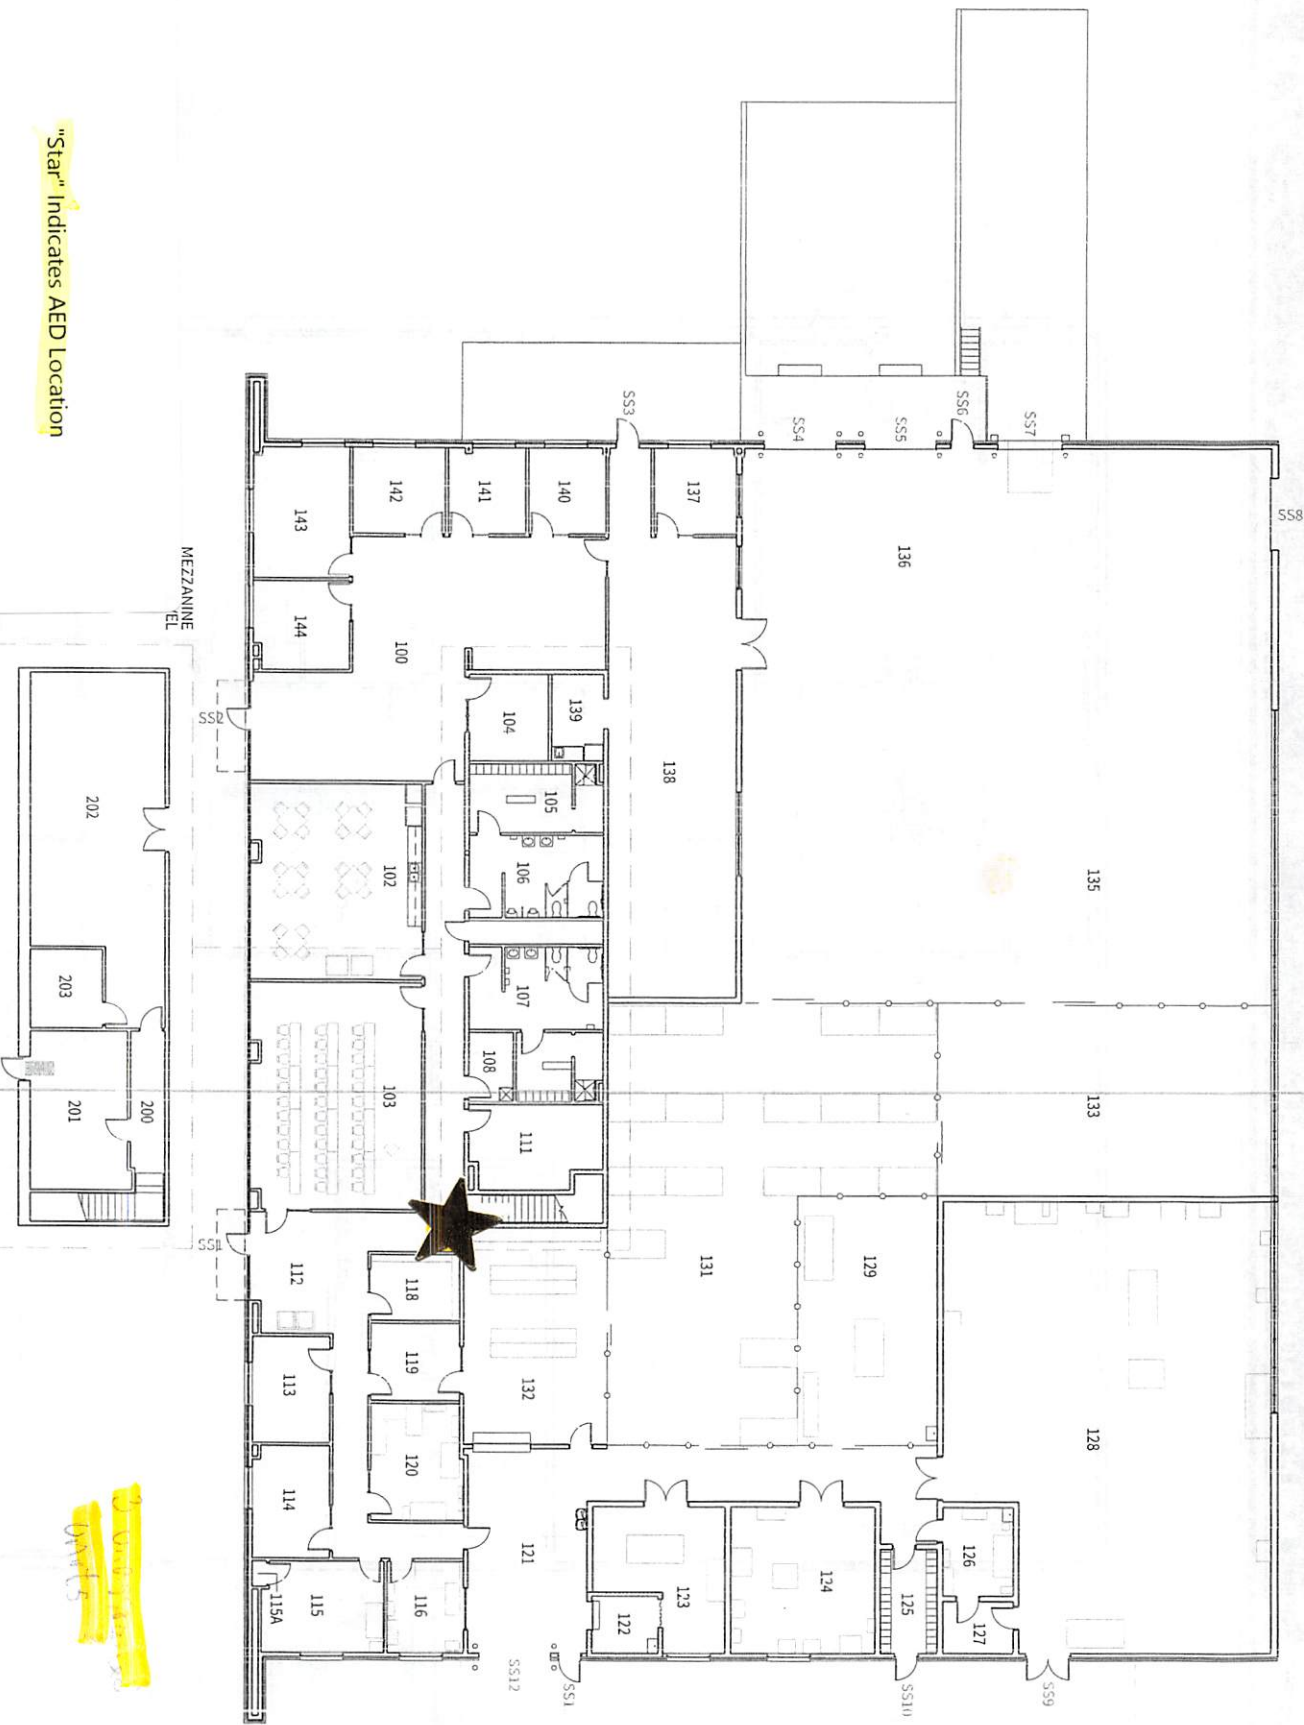

# SUPPORT SERVICES CENTER


FLOOR PLAN

SS





"Star" Indicates AED Location

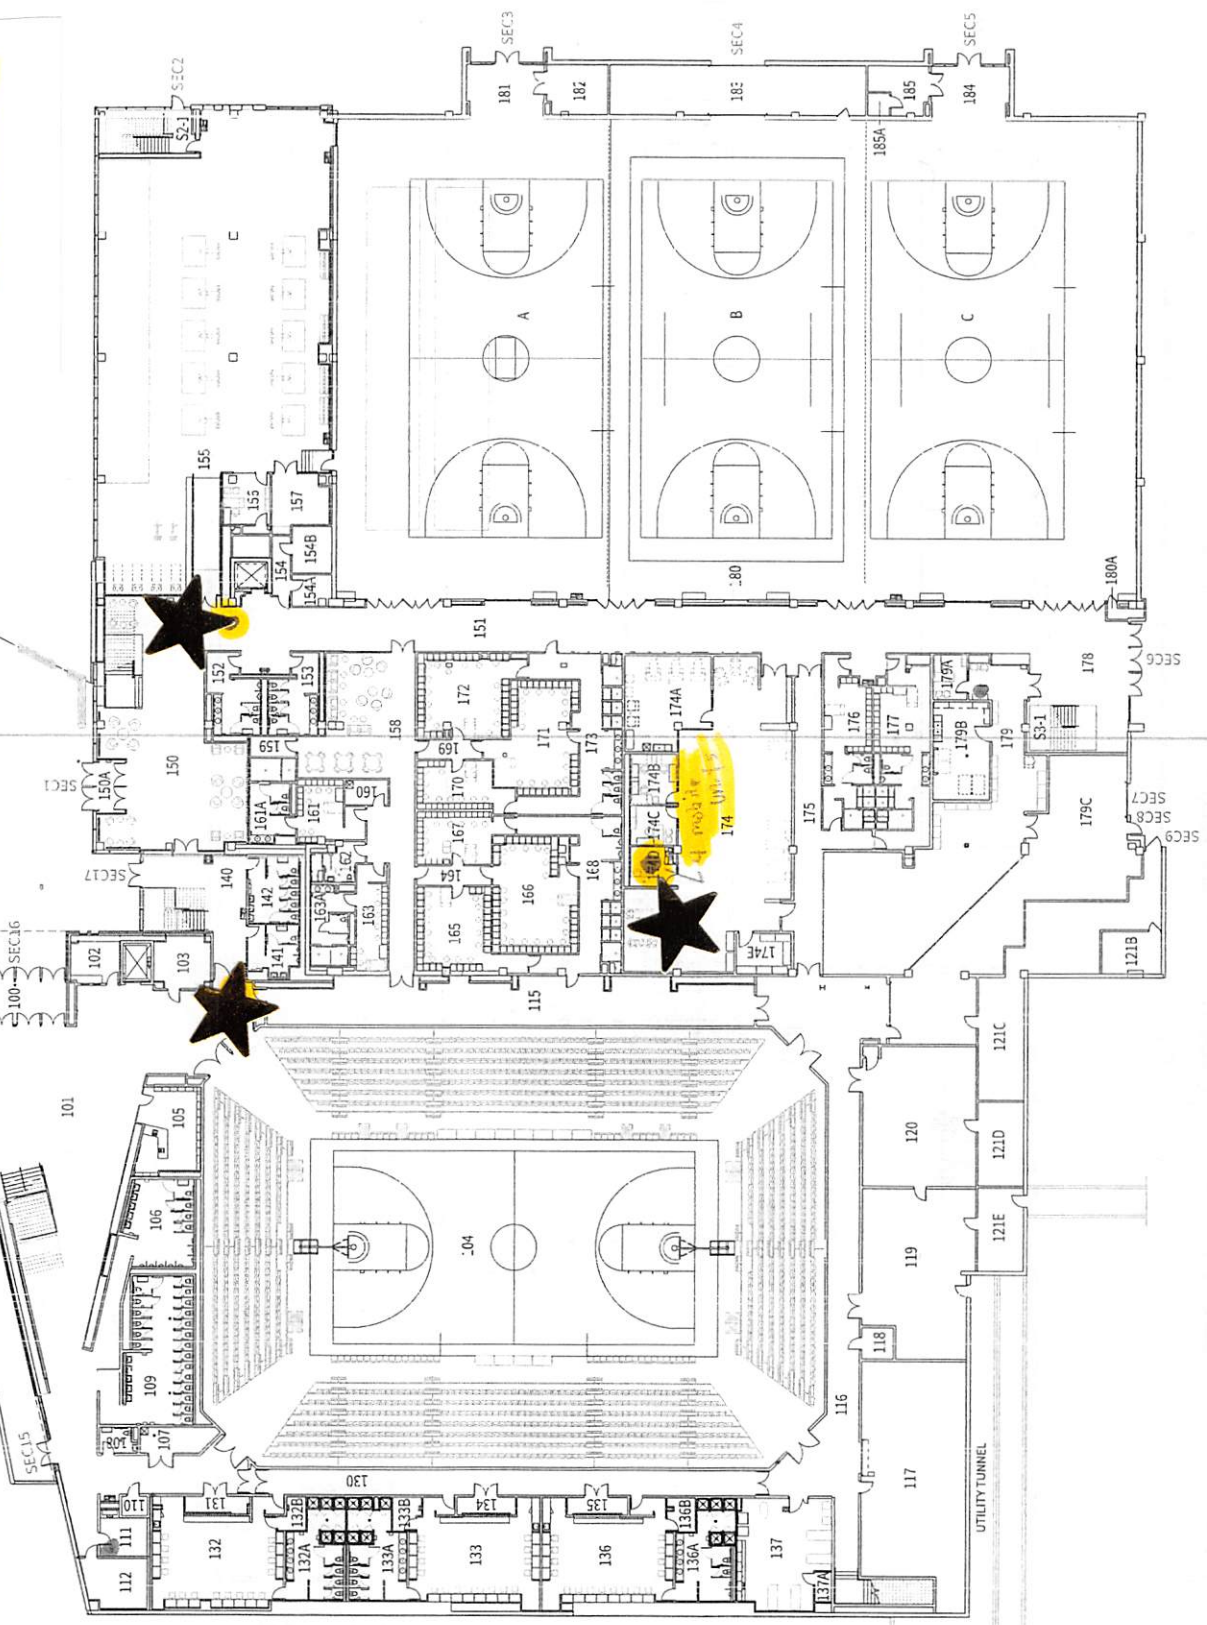




03.01.2020




# SCIENCE CENTER PENTHOUSE FLOOR PLAN

SC

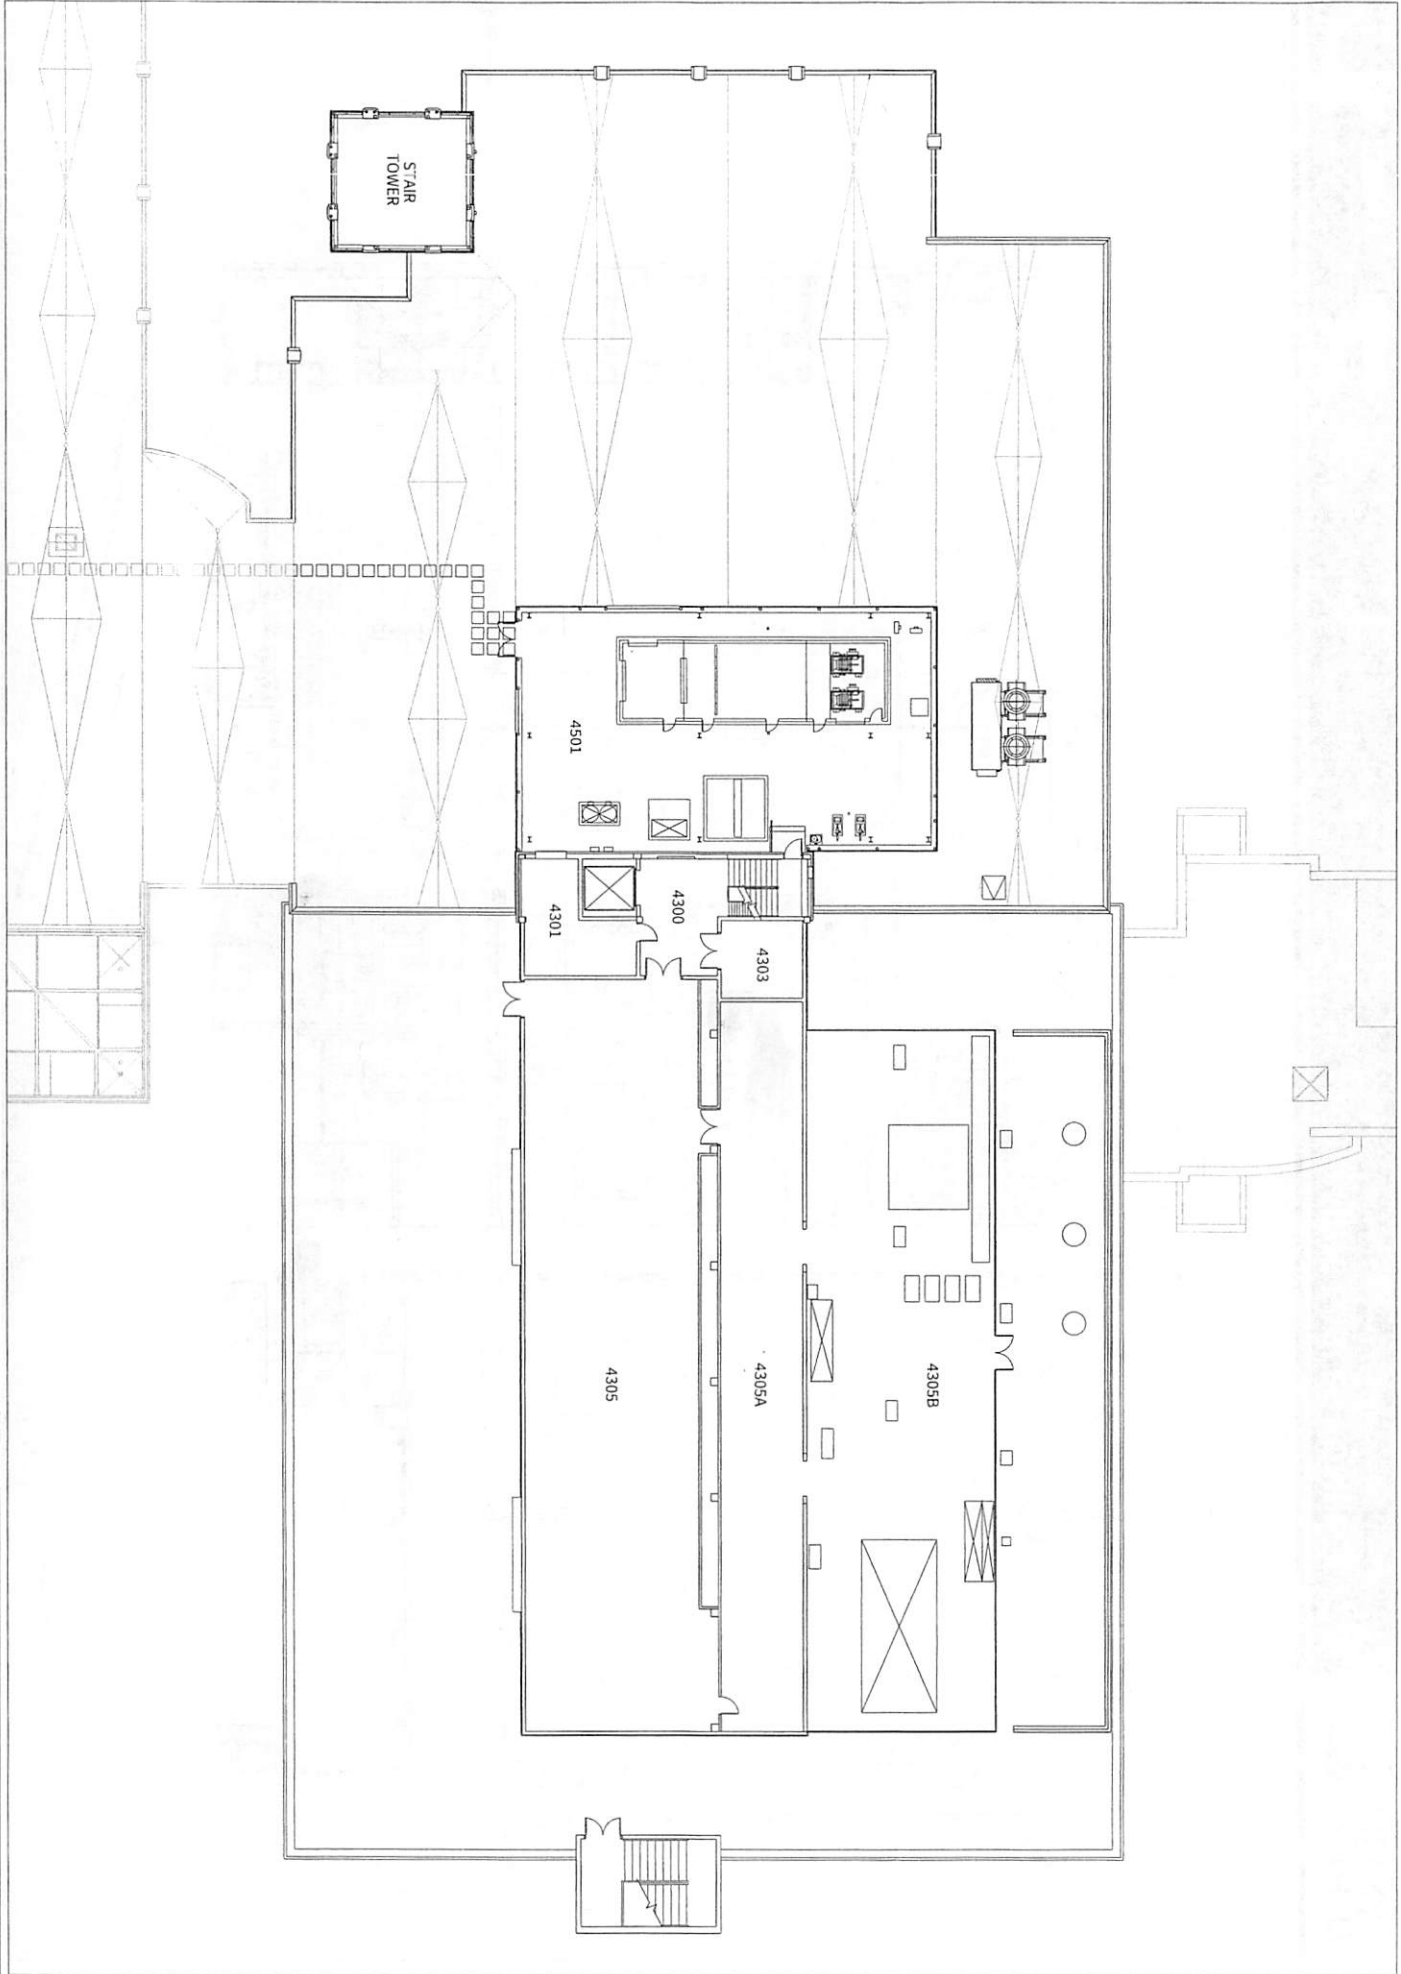



"Star" Indicates AED Location

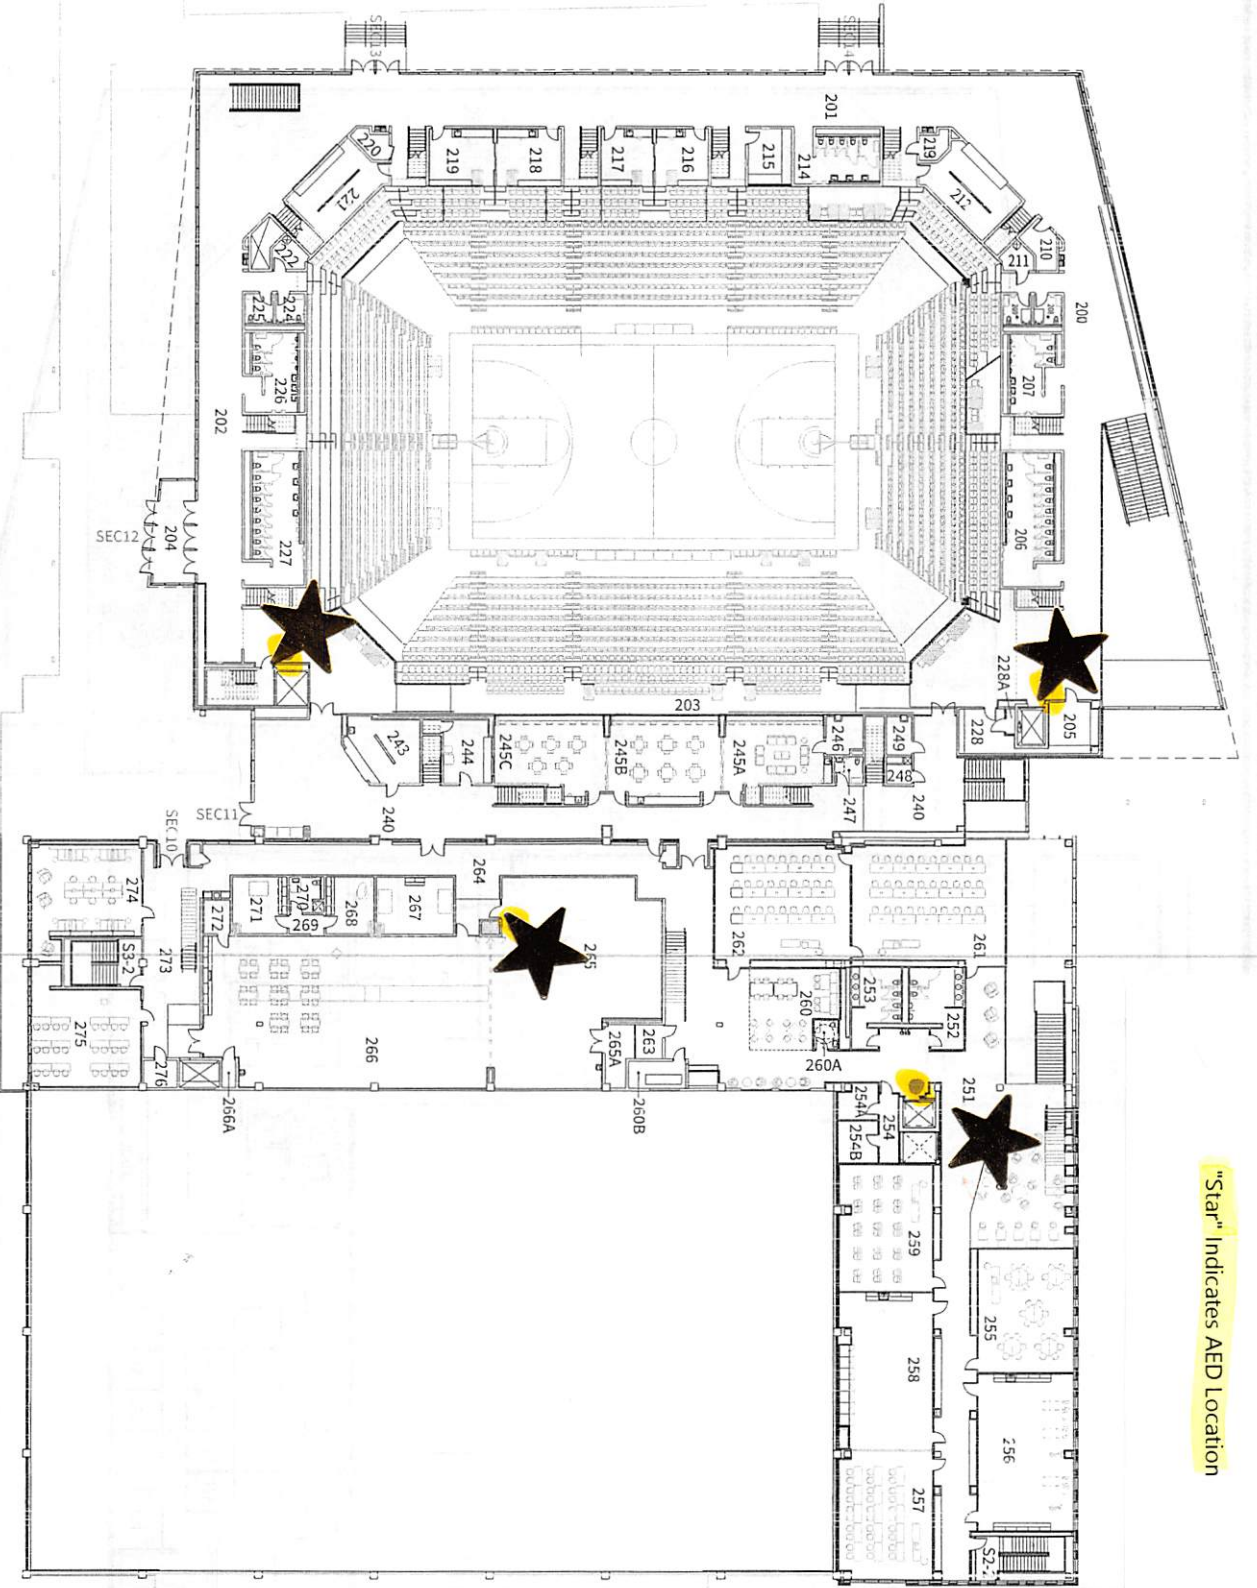

**SCREAMING EAGLES COMPLEX**  
SECOND LEVEL FLOOR PLAN  
**SEC**



01.01.2022  
0 5 10 25  
50 75



01.01.2022


0 5 10 25

50 75


# SCREAMING EAGLES COMPLEX

## THIRD LEVEL FLOOR PLAN

### SEC

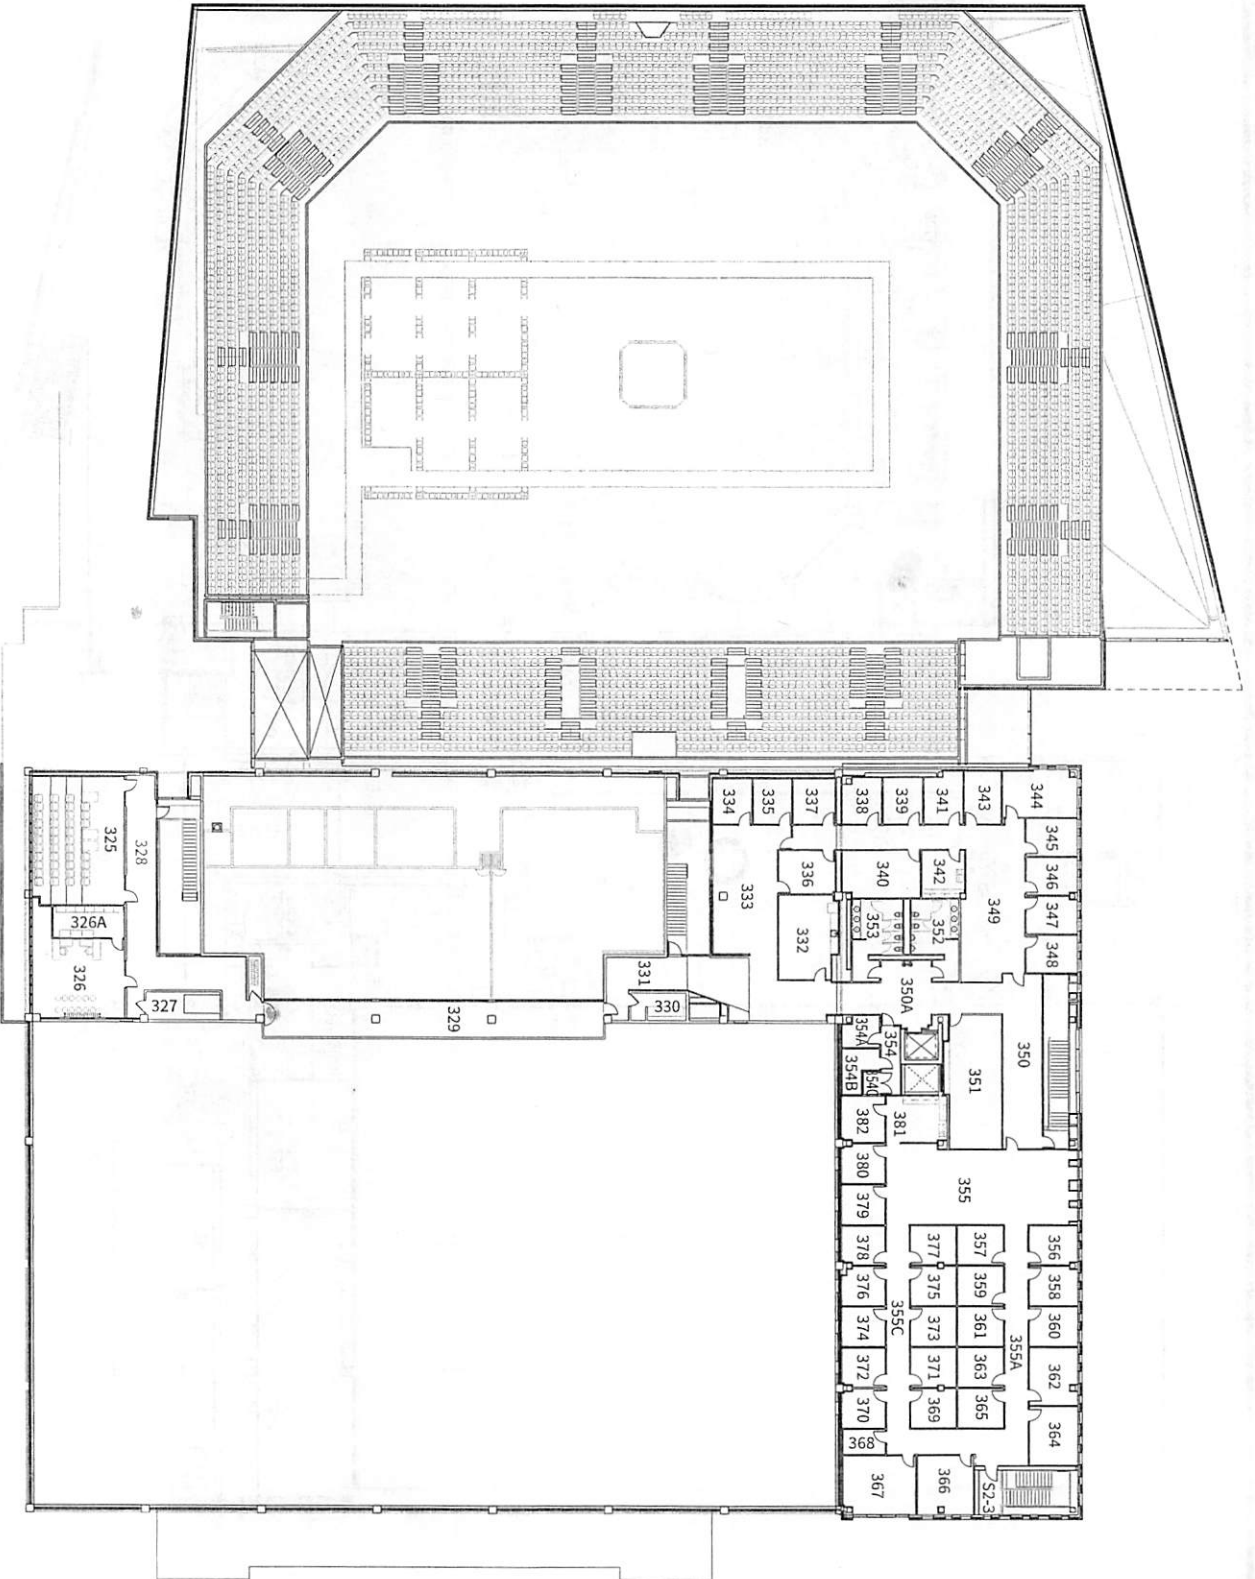




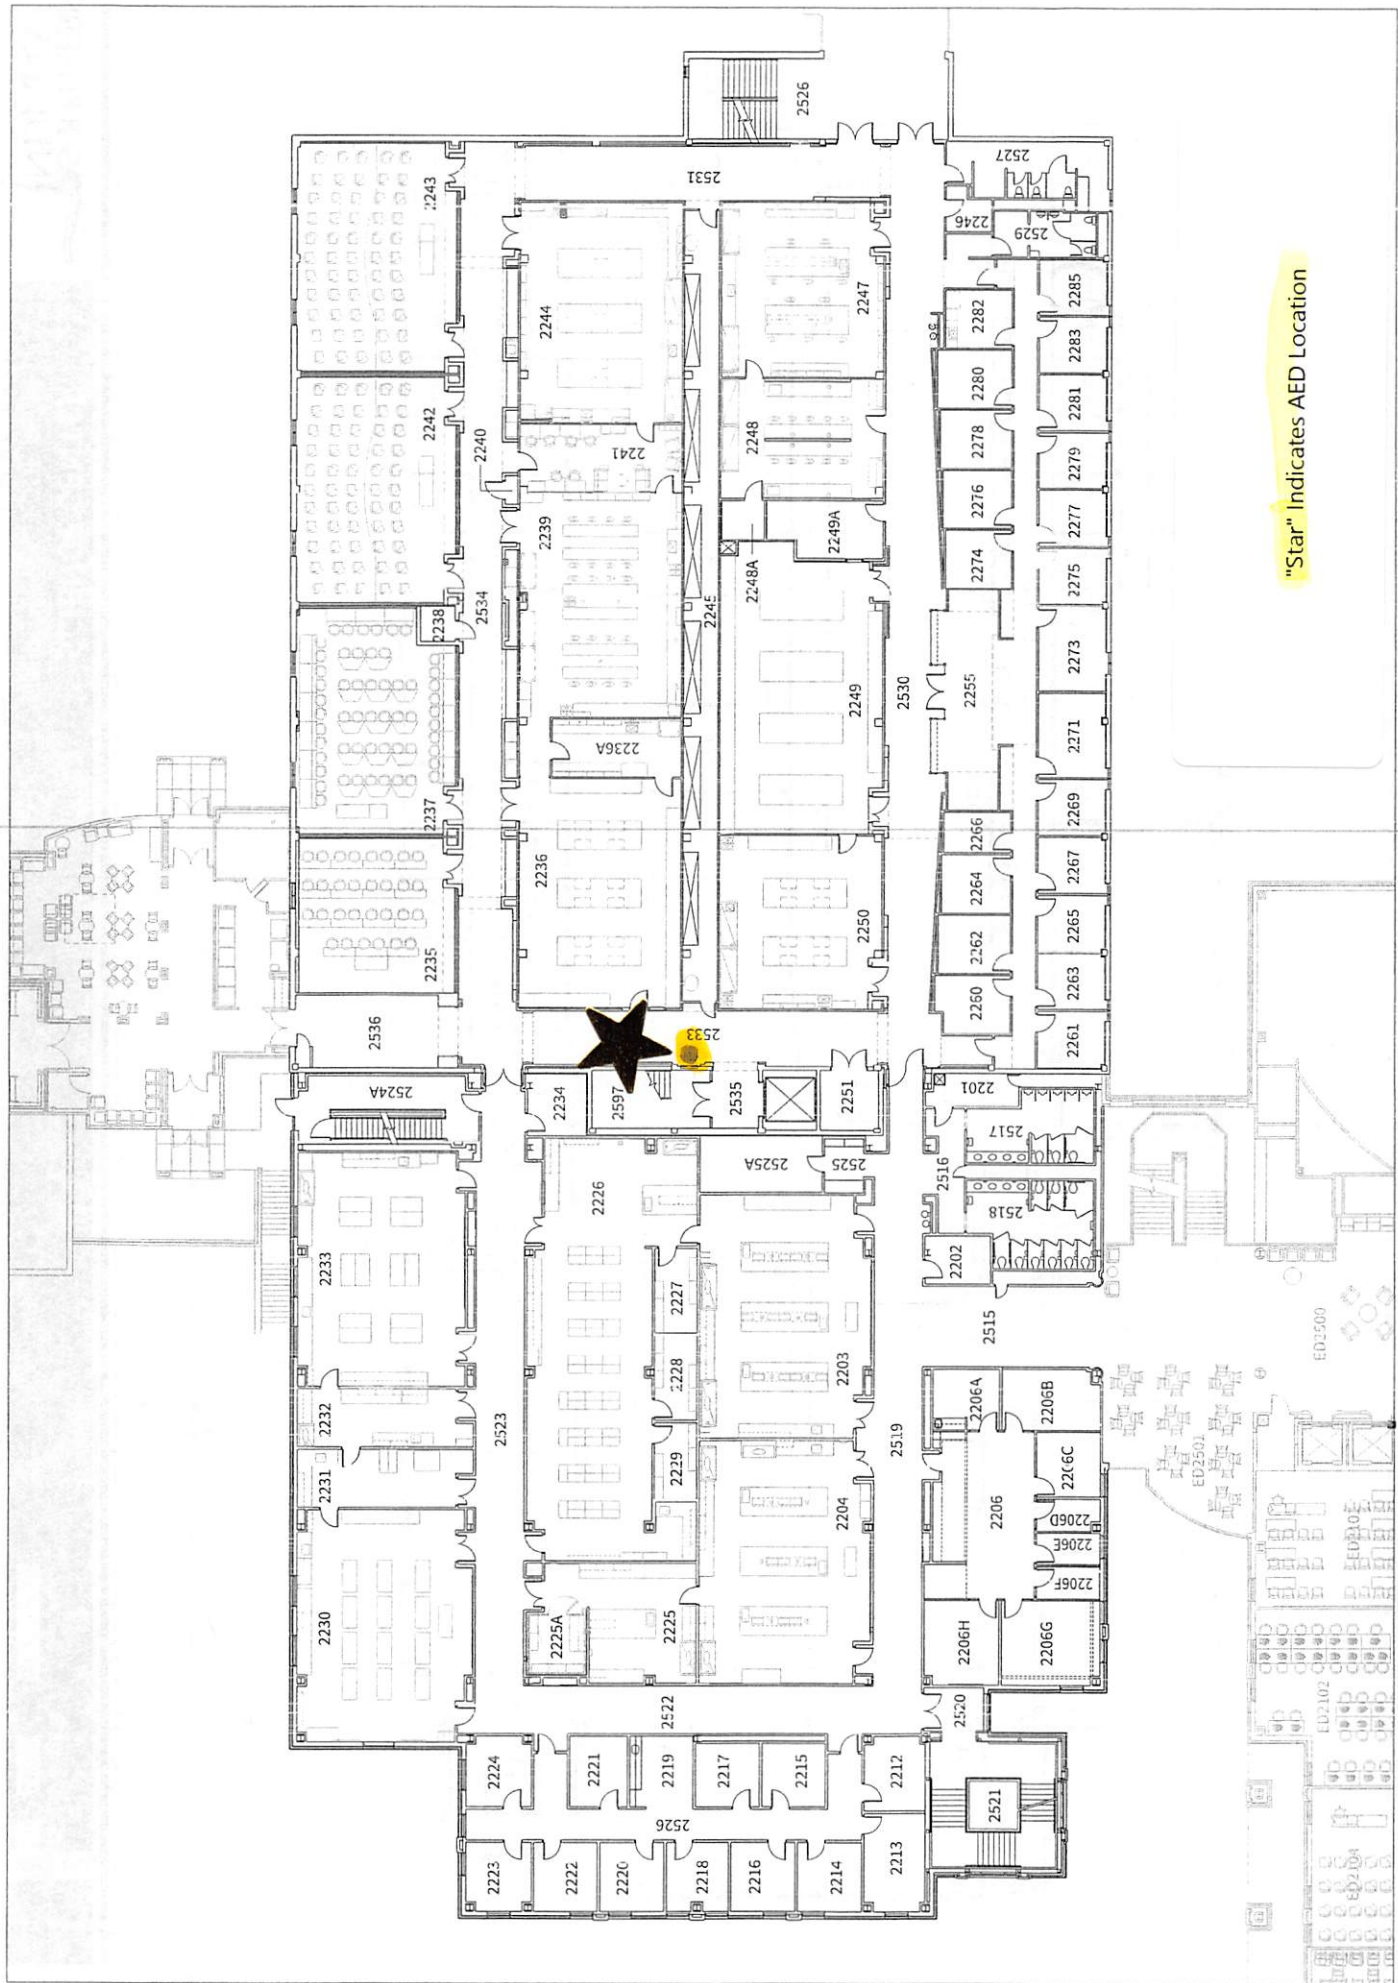

"Star" Indicates AED Location



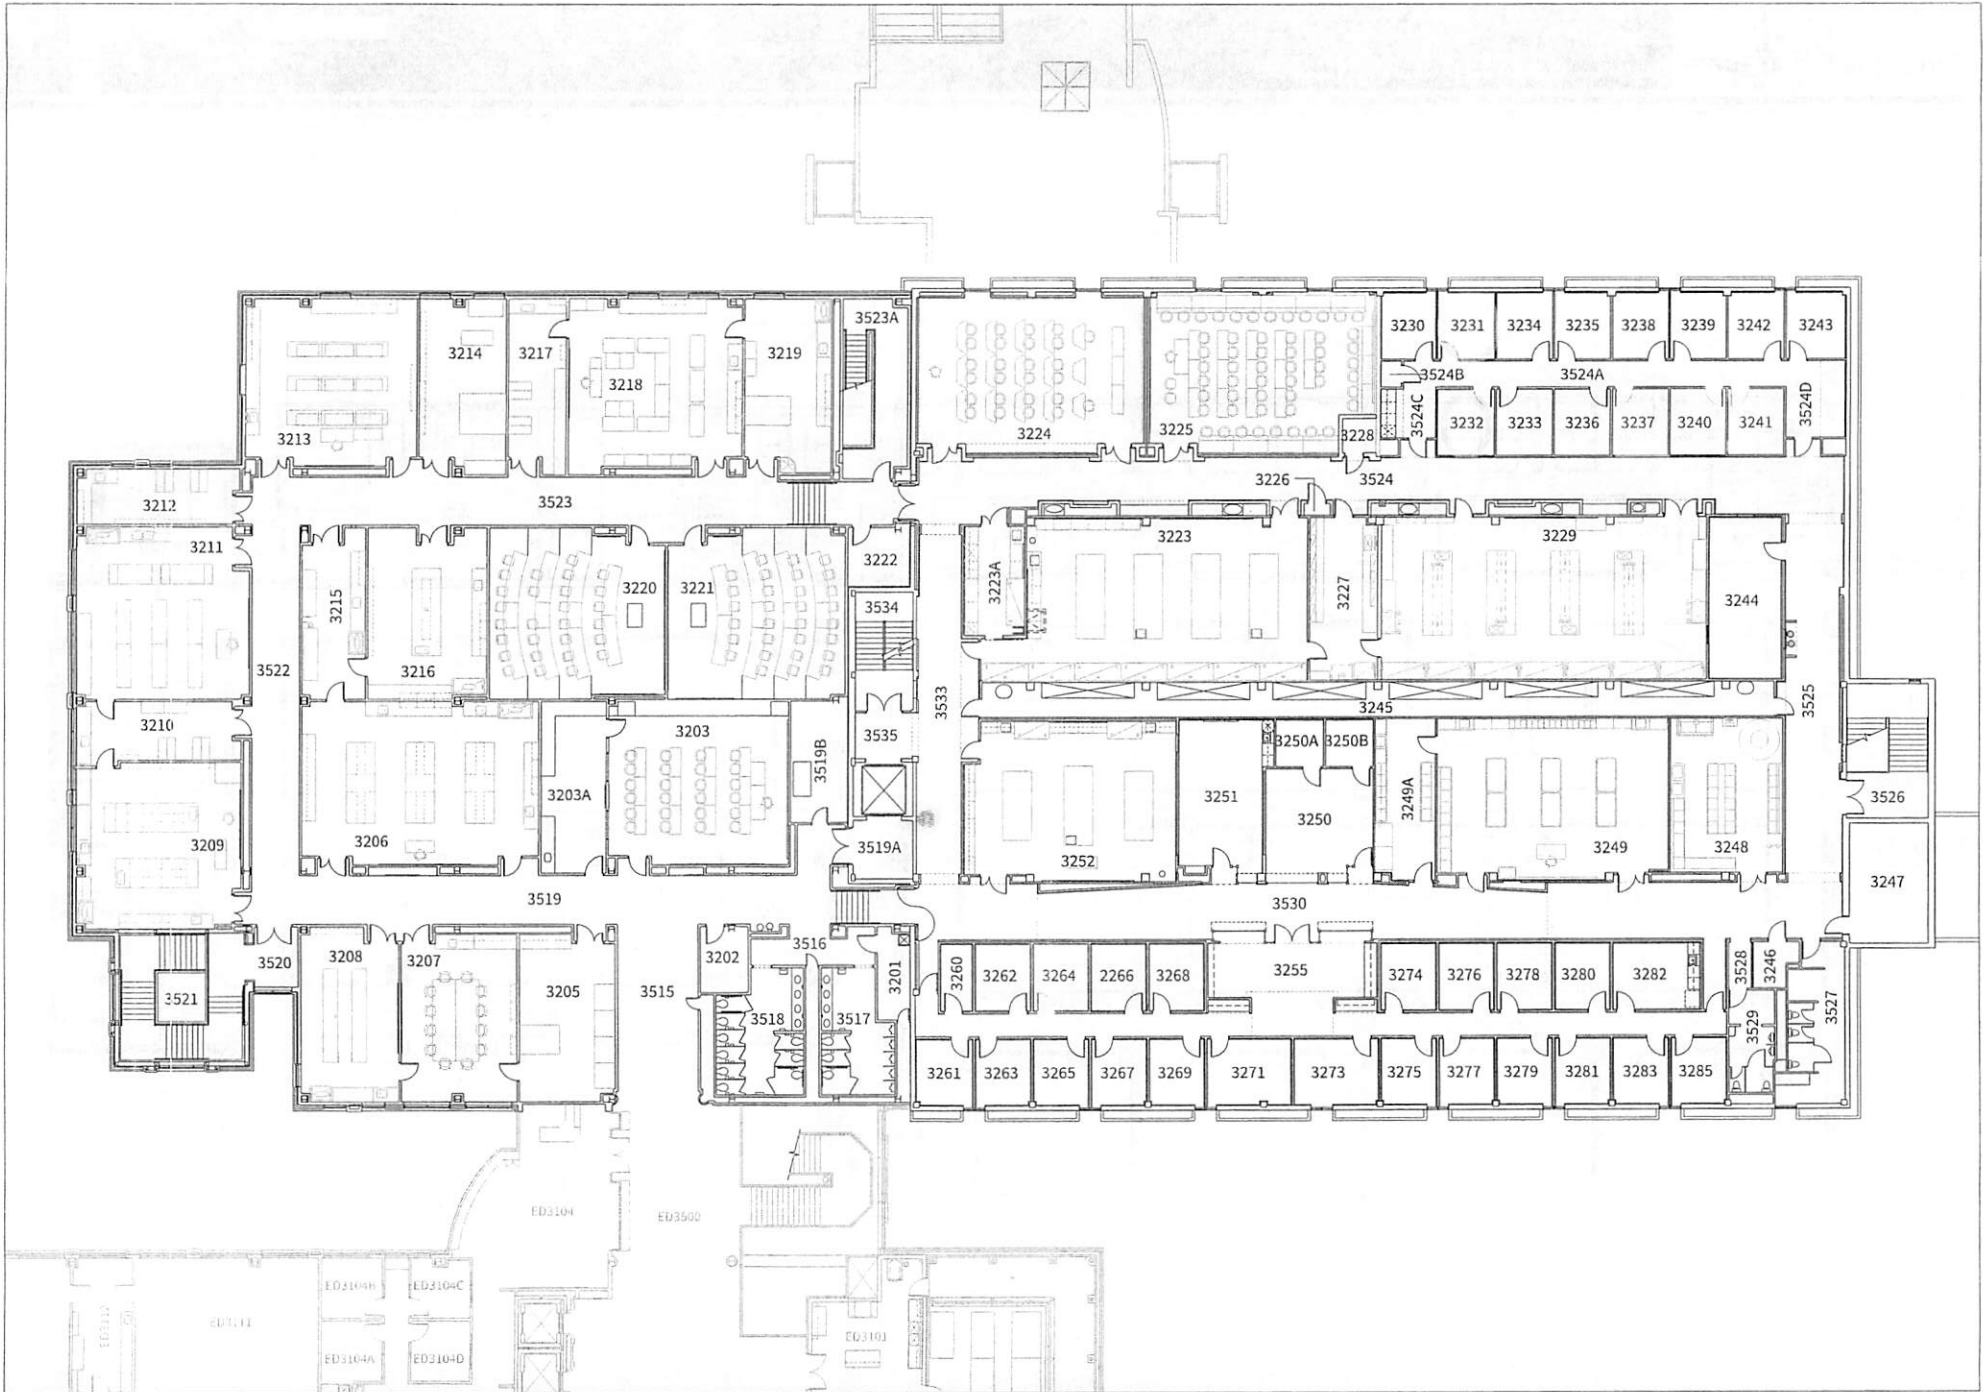

01.10.2022


**SCIENCE CENTER**  
THIRD LEVEL FLOOR PLAN


**SC**





"Star" Indicates AED Location

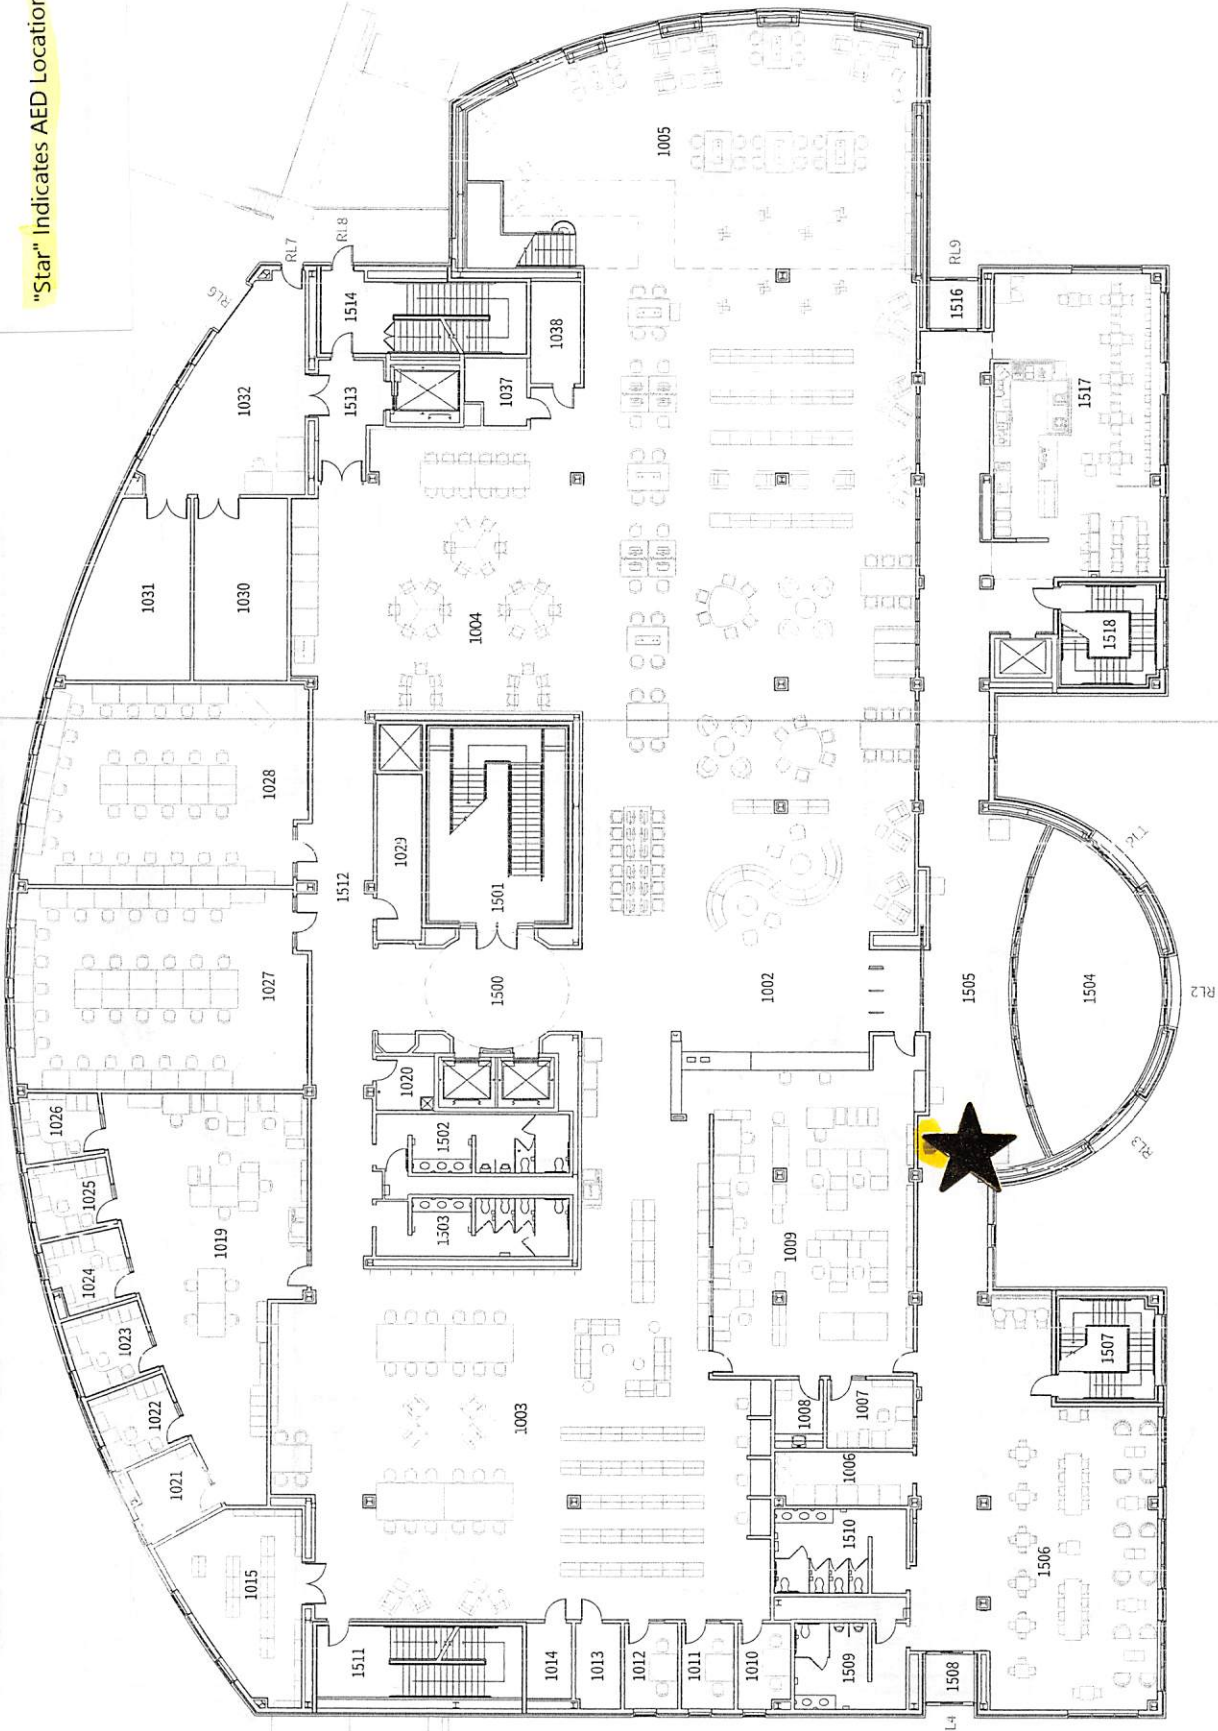

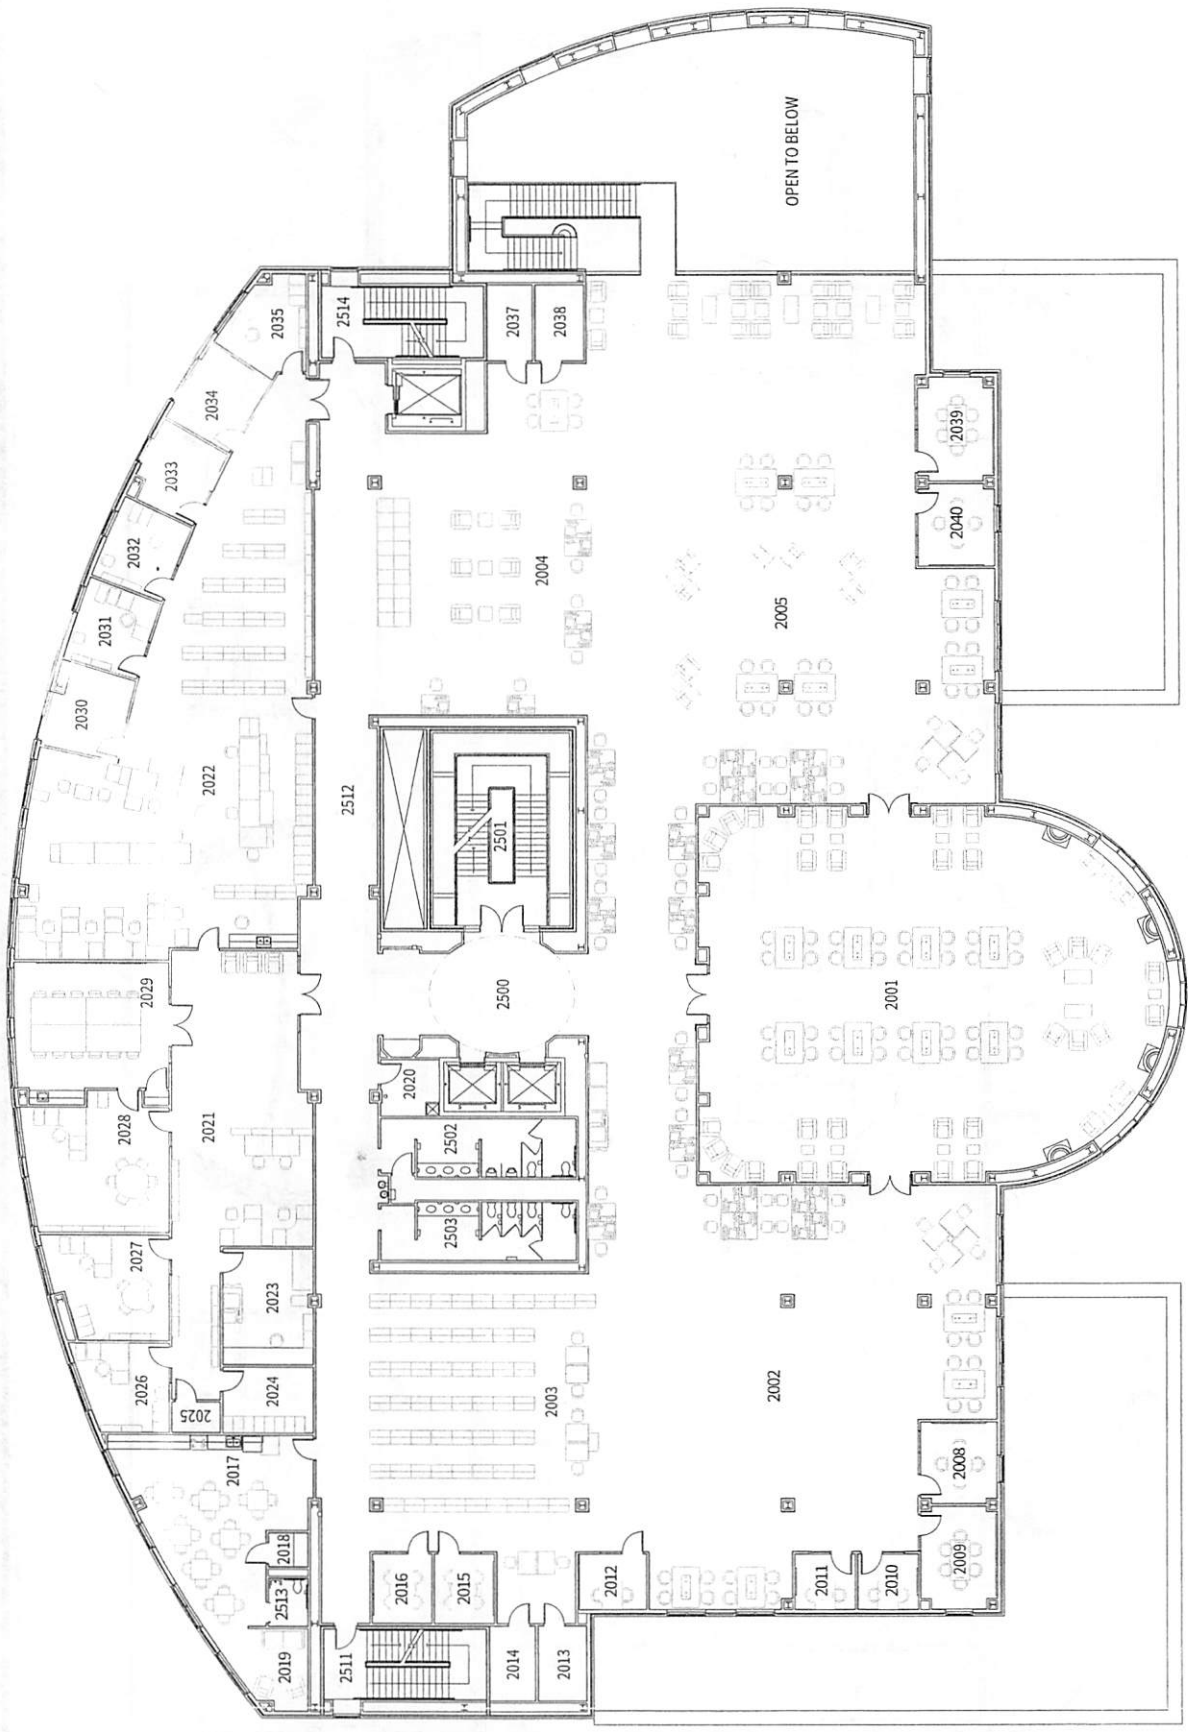





01.01.2022




# RECREATION, FITNESS AND WELLNESS CENTER

## SECOND LEVEL FLOOR PLAN

FC




"Star" Indicates AED Location

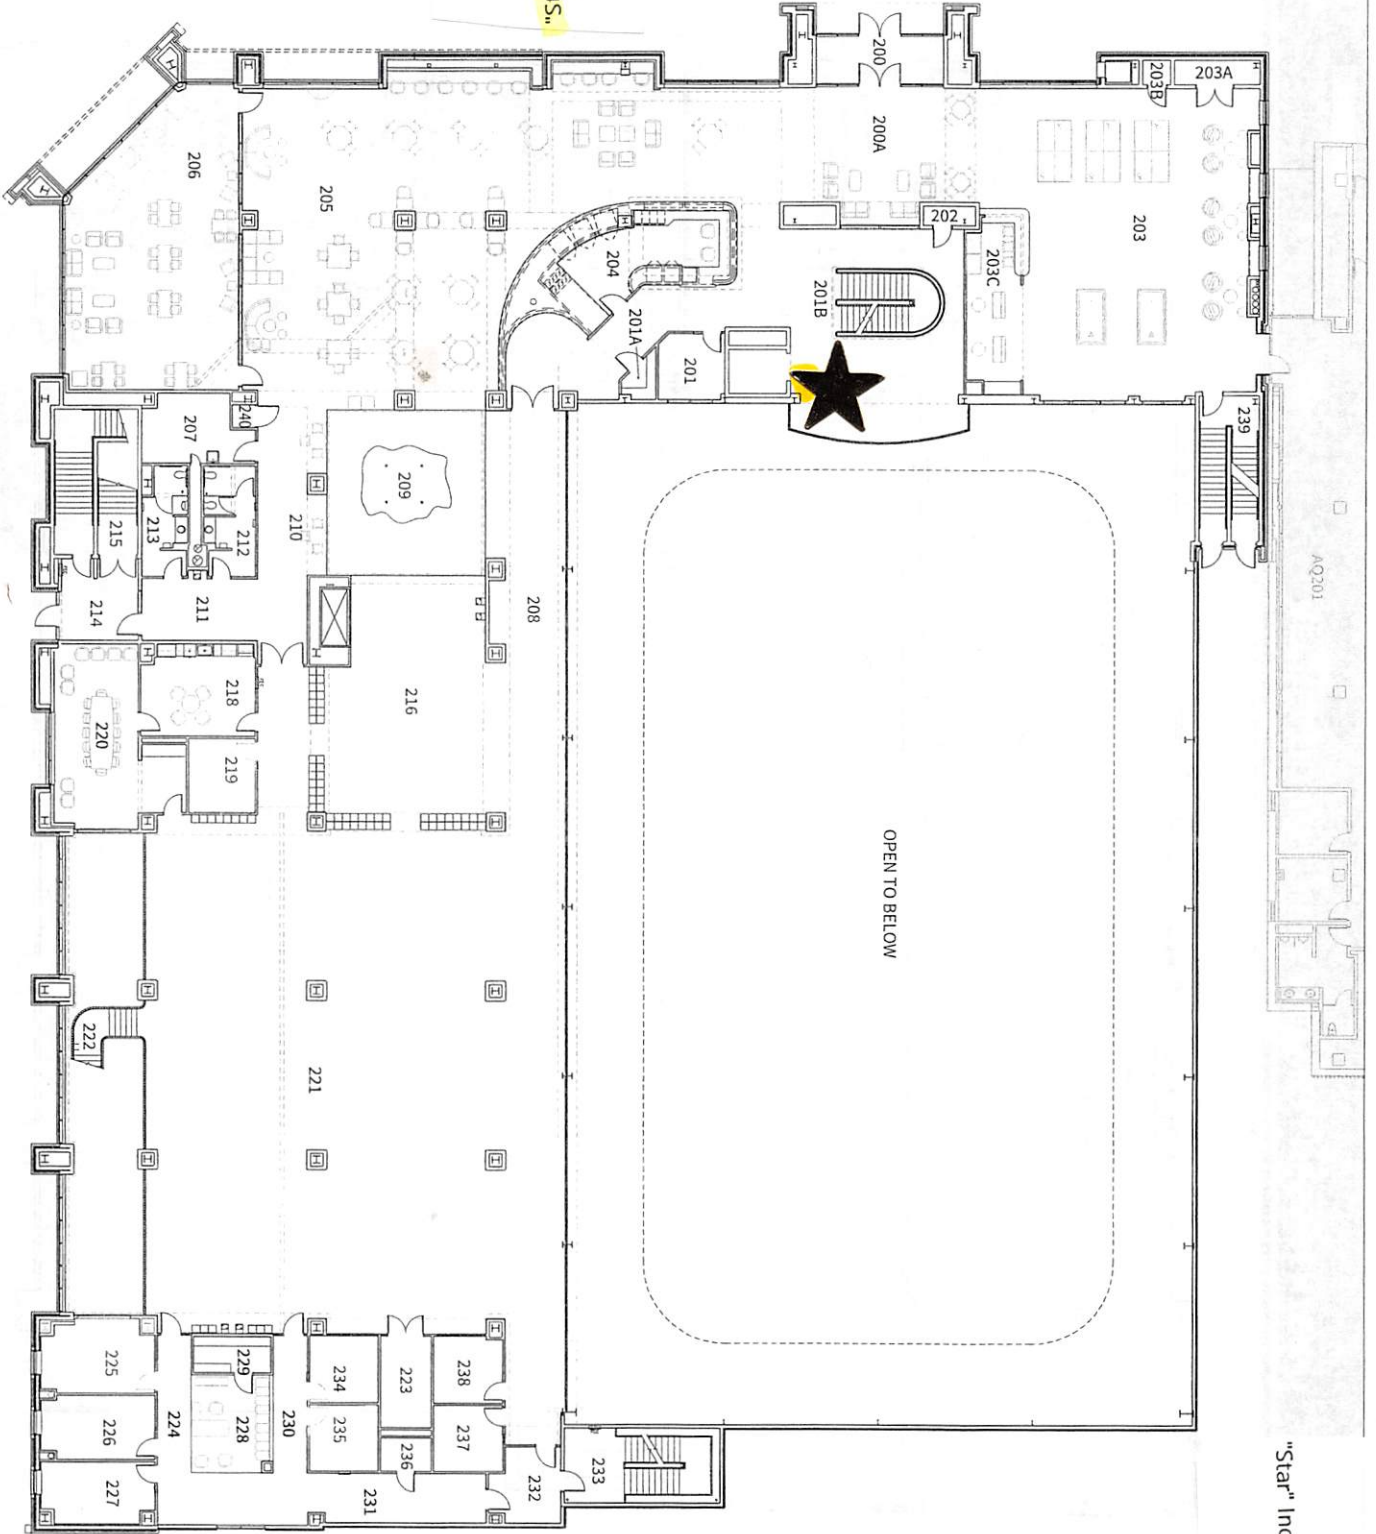

"Star" Indicates AED Location

Rm #s are the old flr plan. follow new numbering to match list.

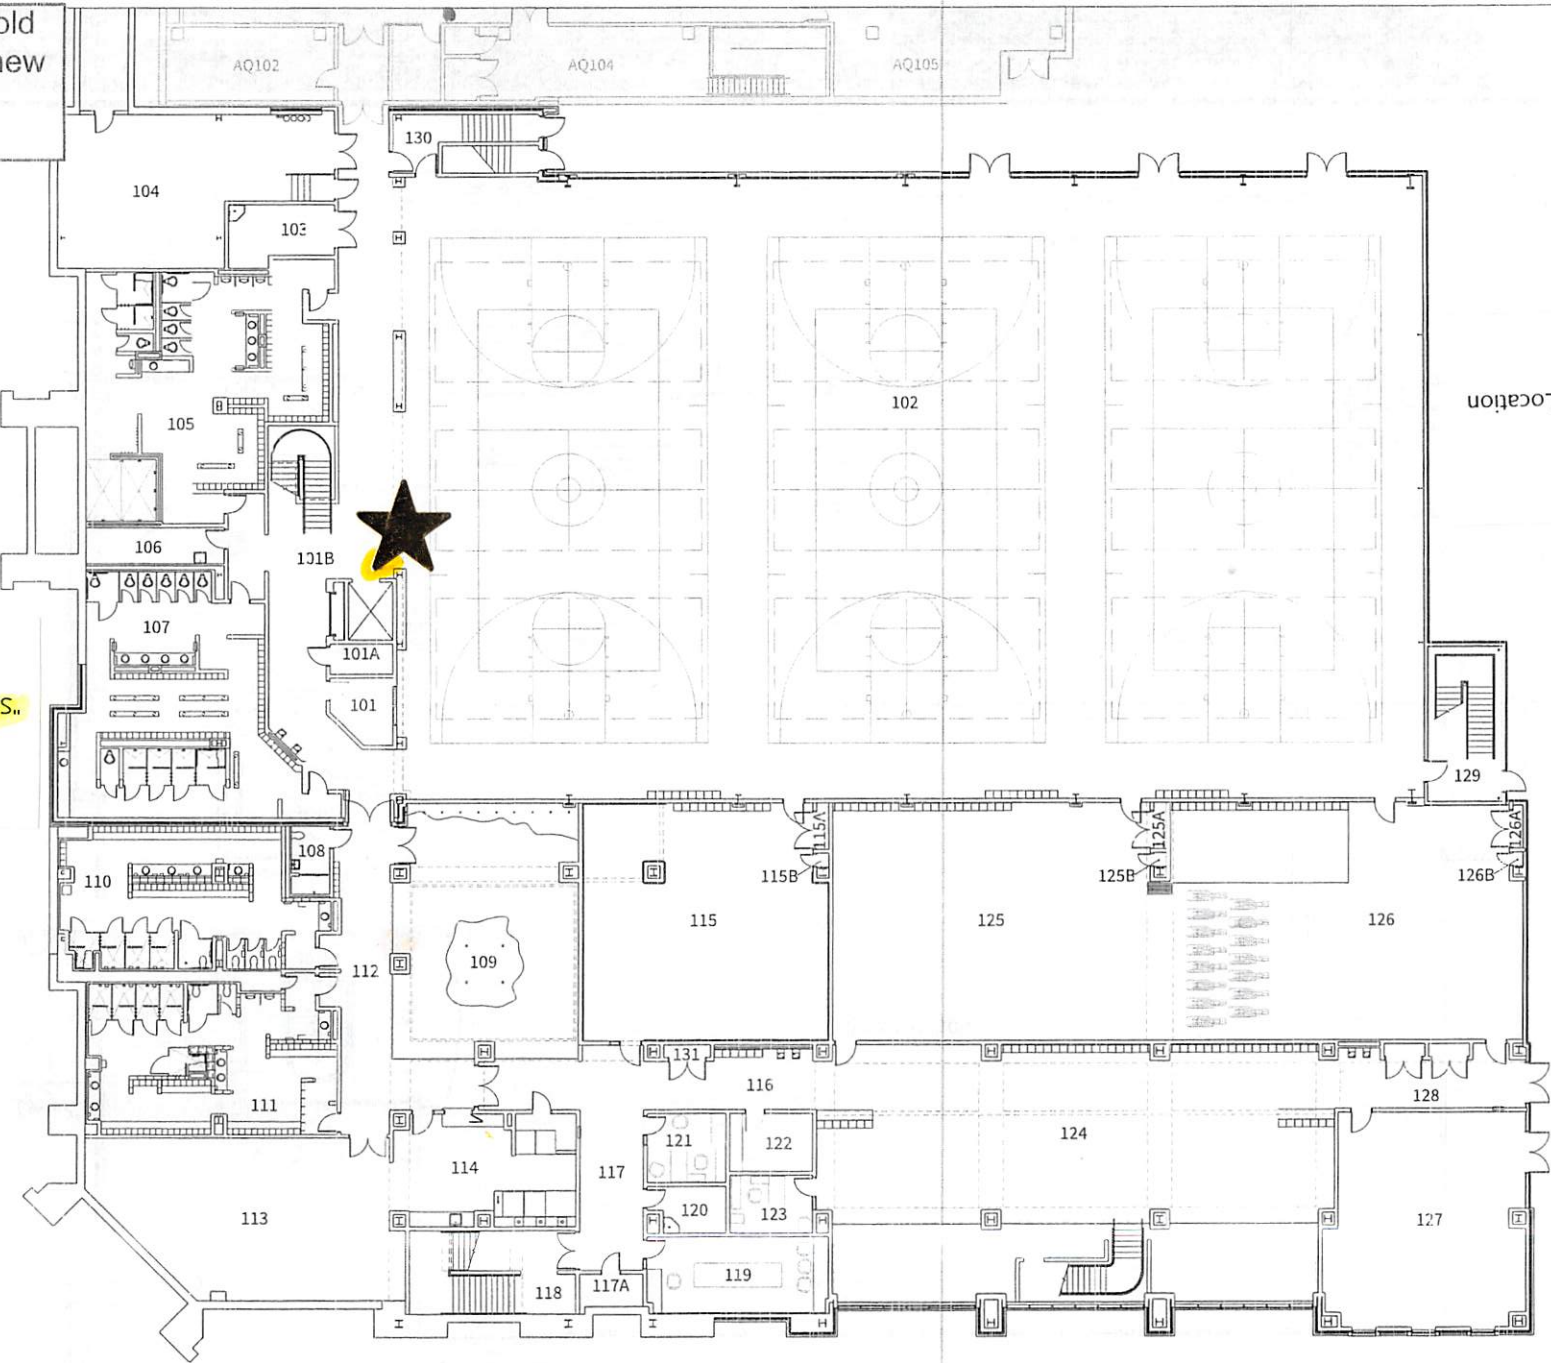

"Star" Indicates AED Location

"Star" Indicates AED Location



01.01.2022




# RECREATION, FITNESS AND WELLNESS CENTER

FIRST LEVEL FLOOR PLAN

FC




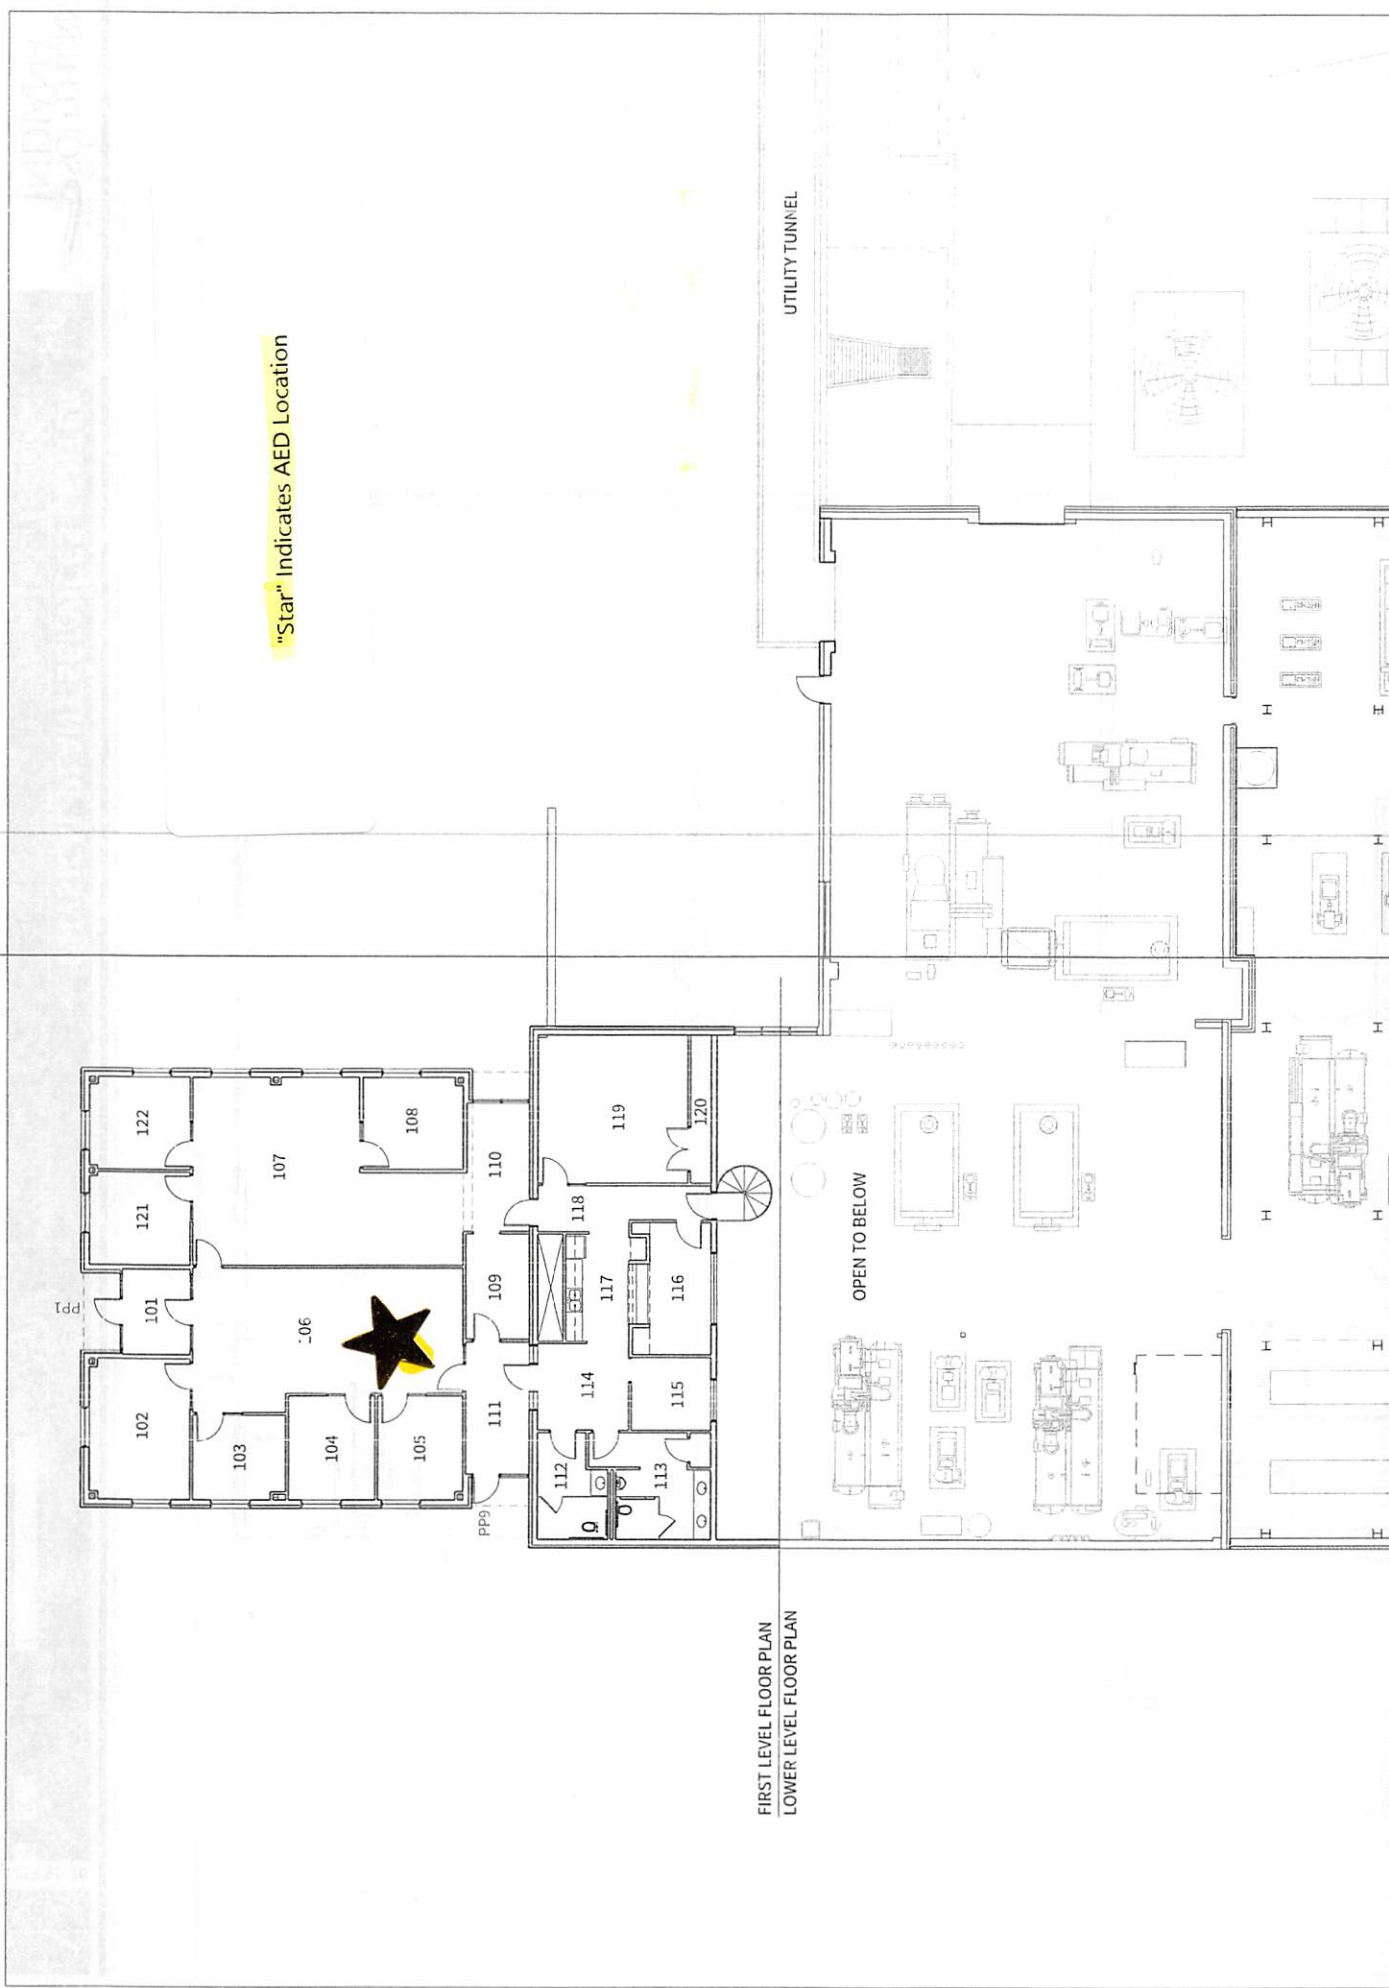


"Star" Indicates AED Location


FIRST LEVEL FLOOR PLAN  
LOWER LEVEL FLOOR PLAN



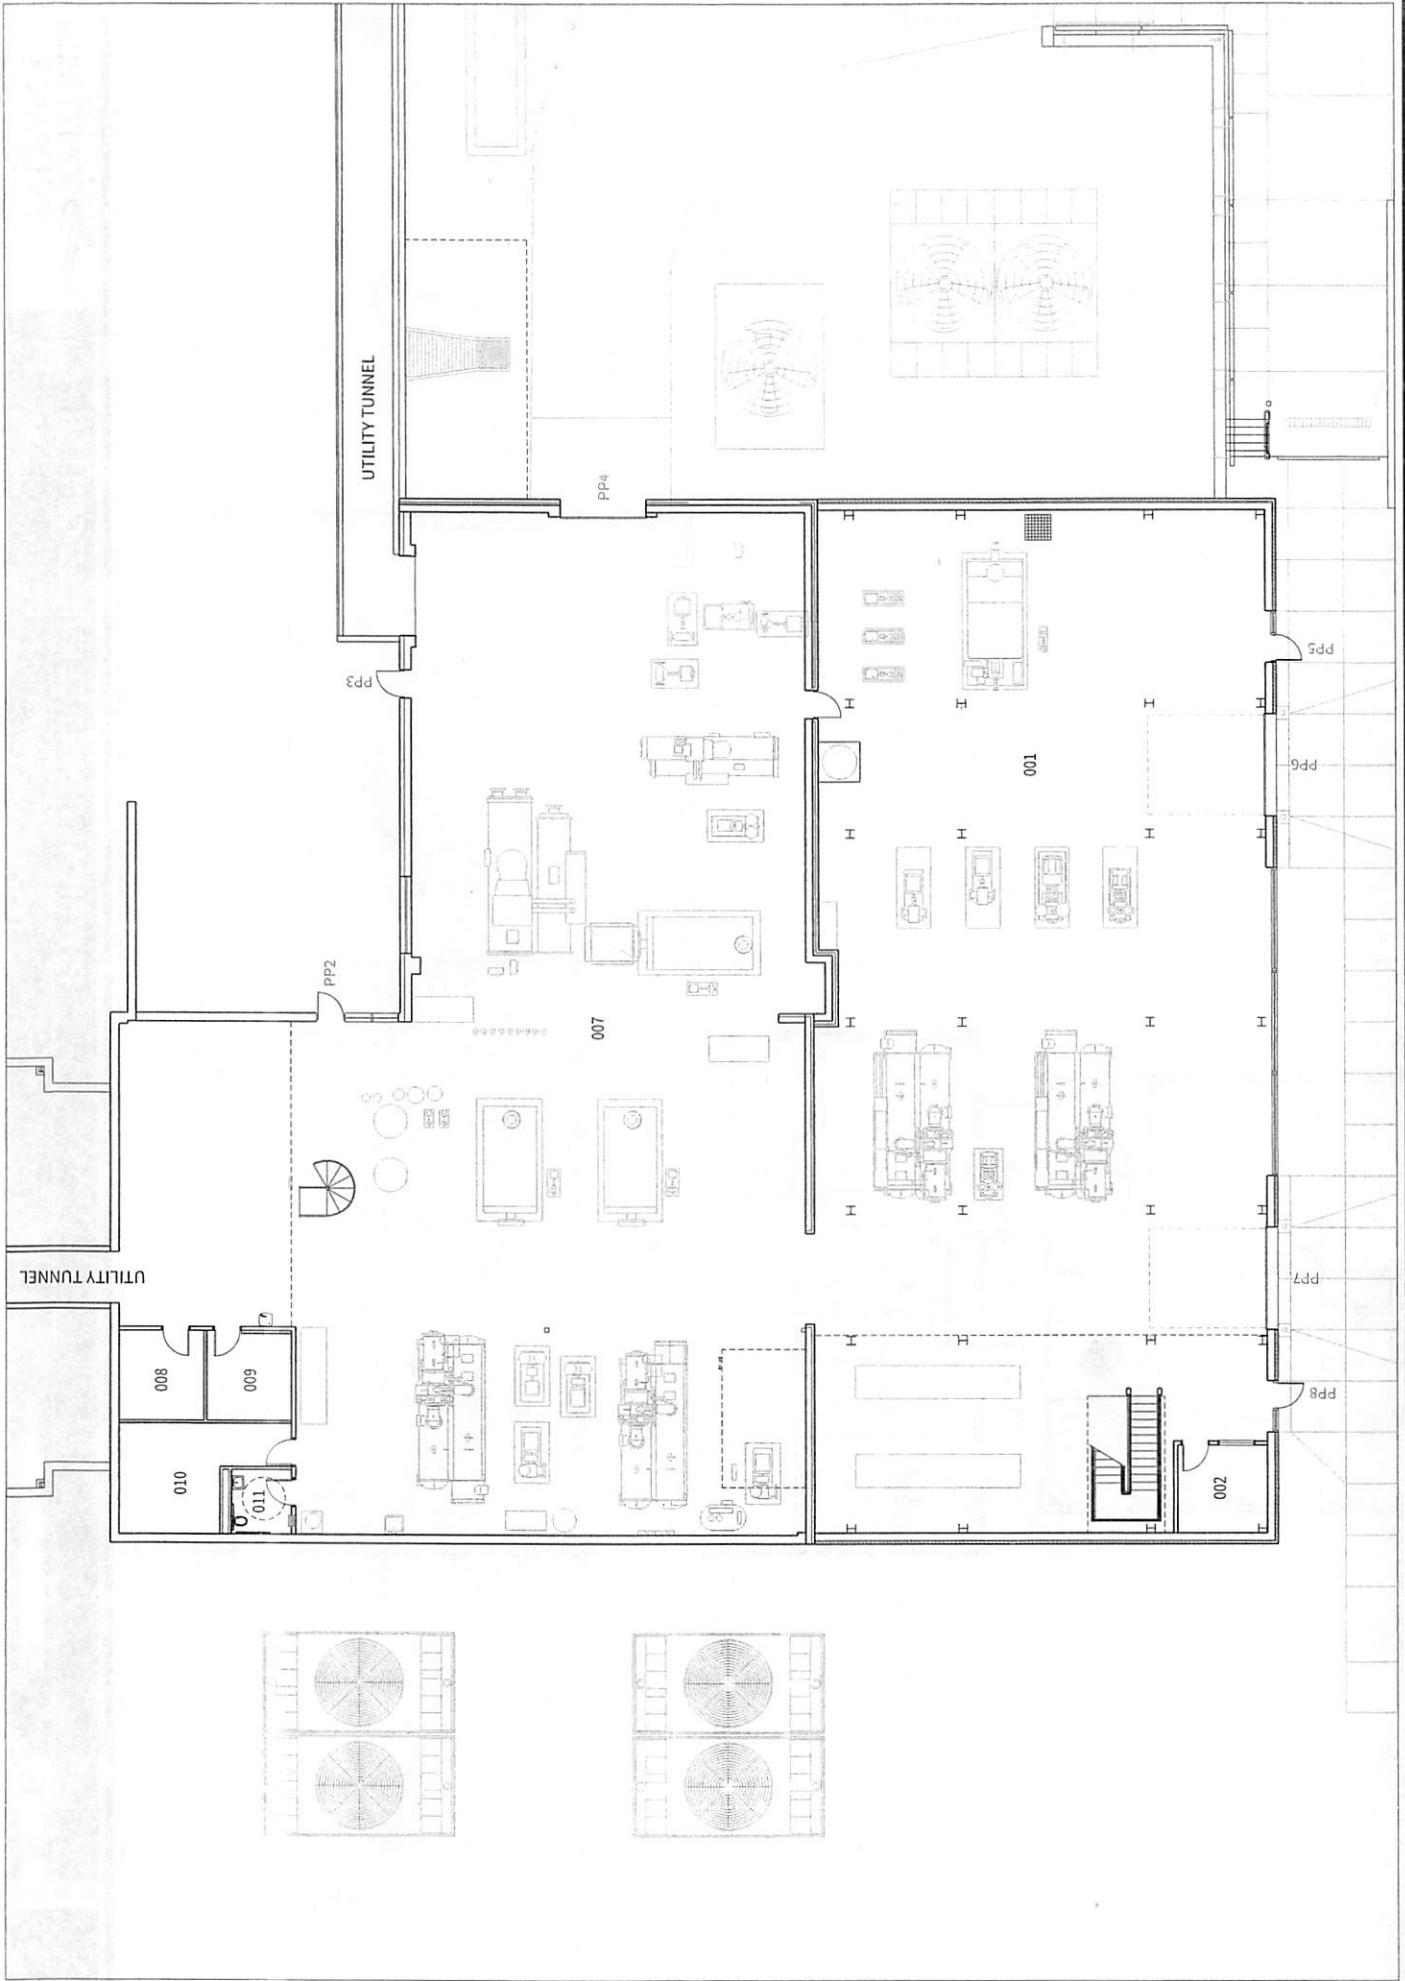

"Star" Indicates AED Location

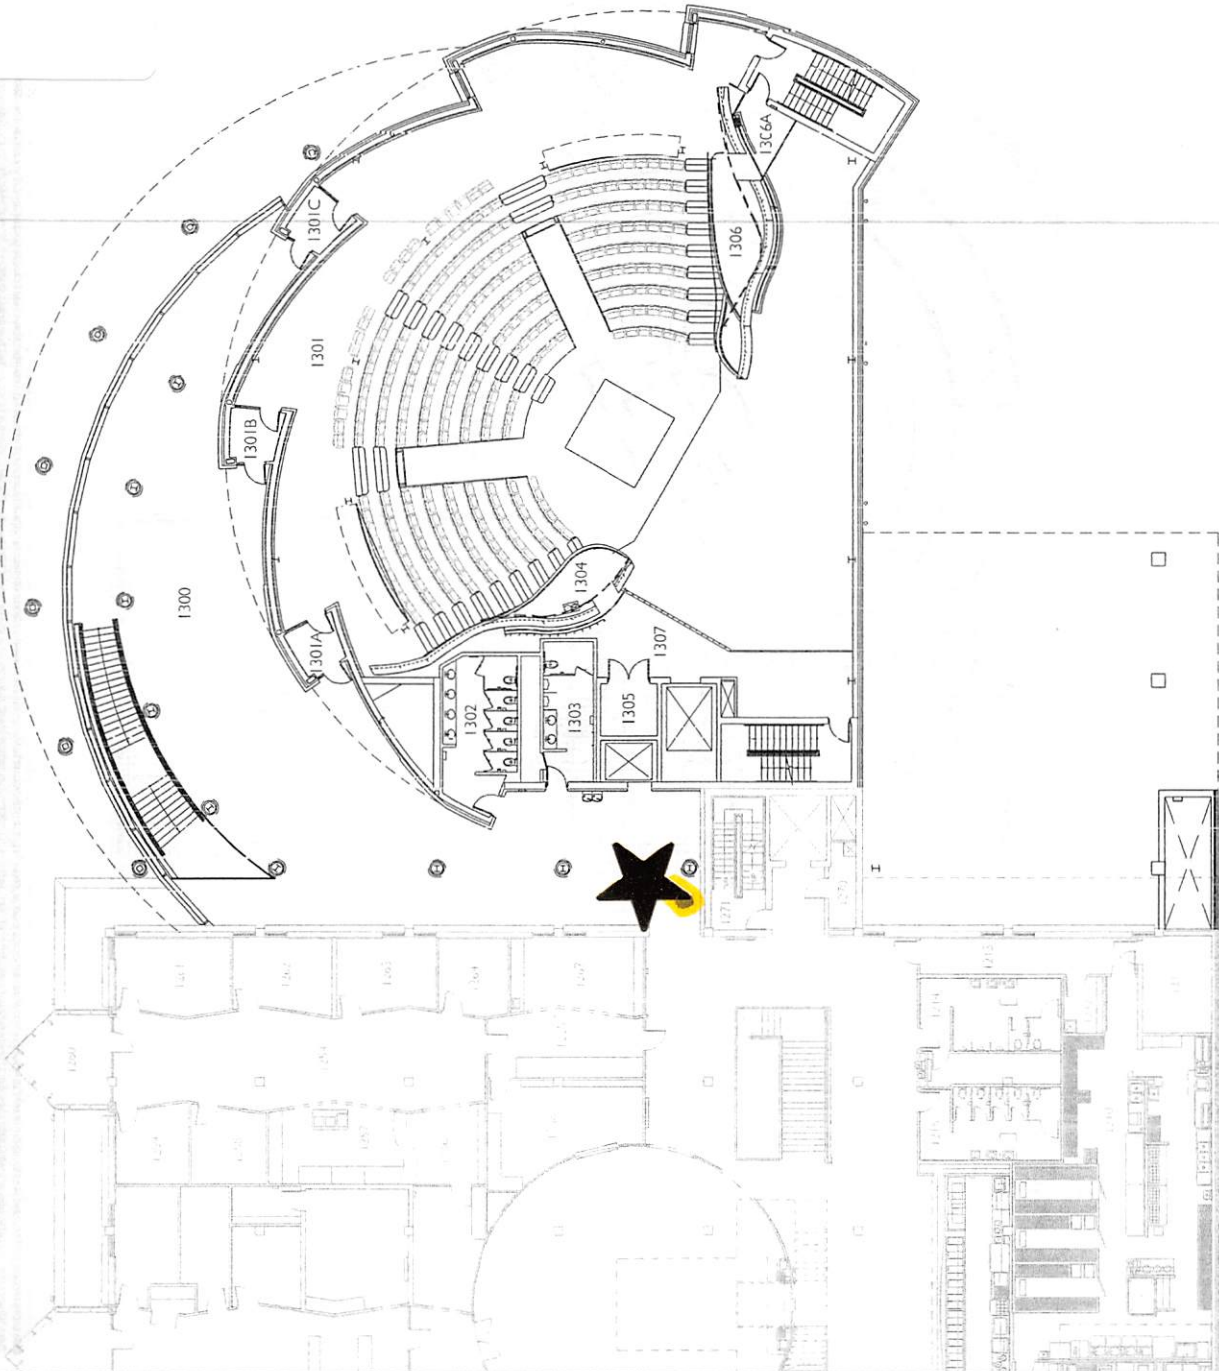


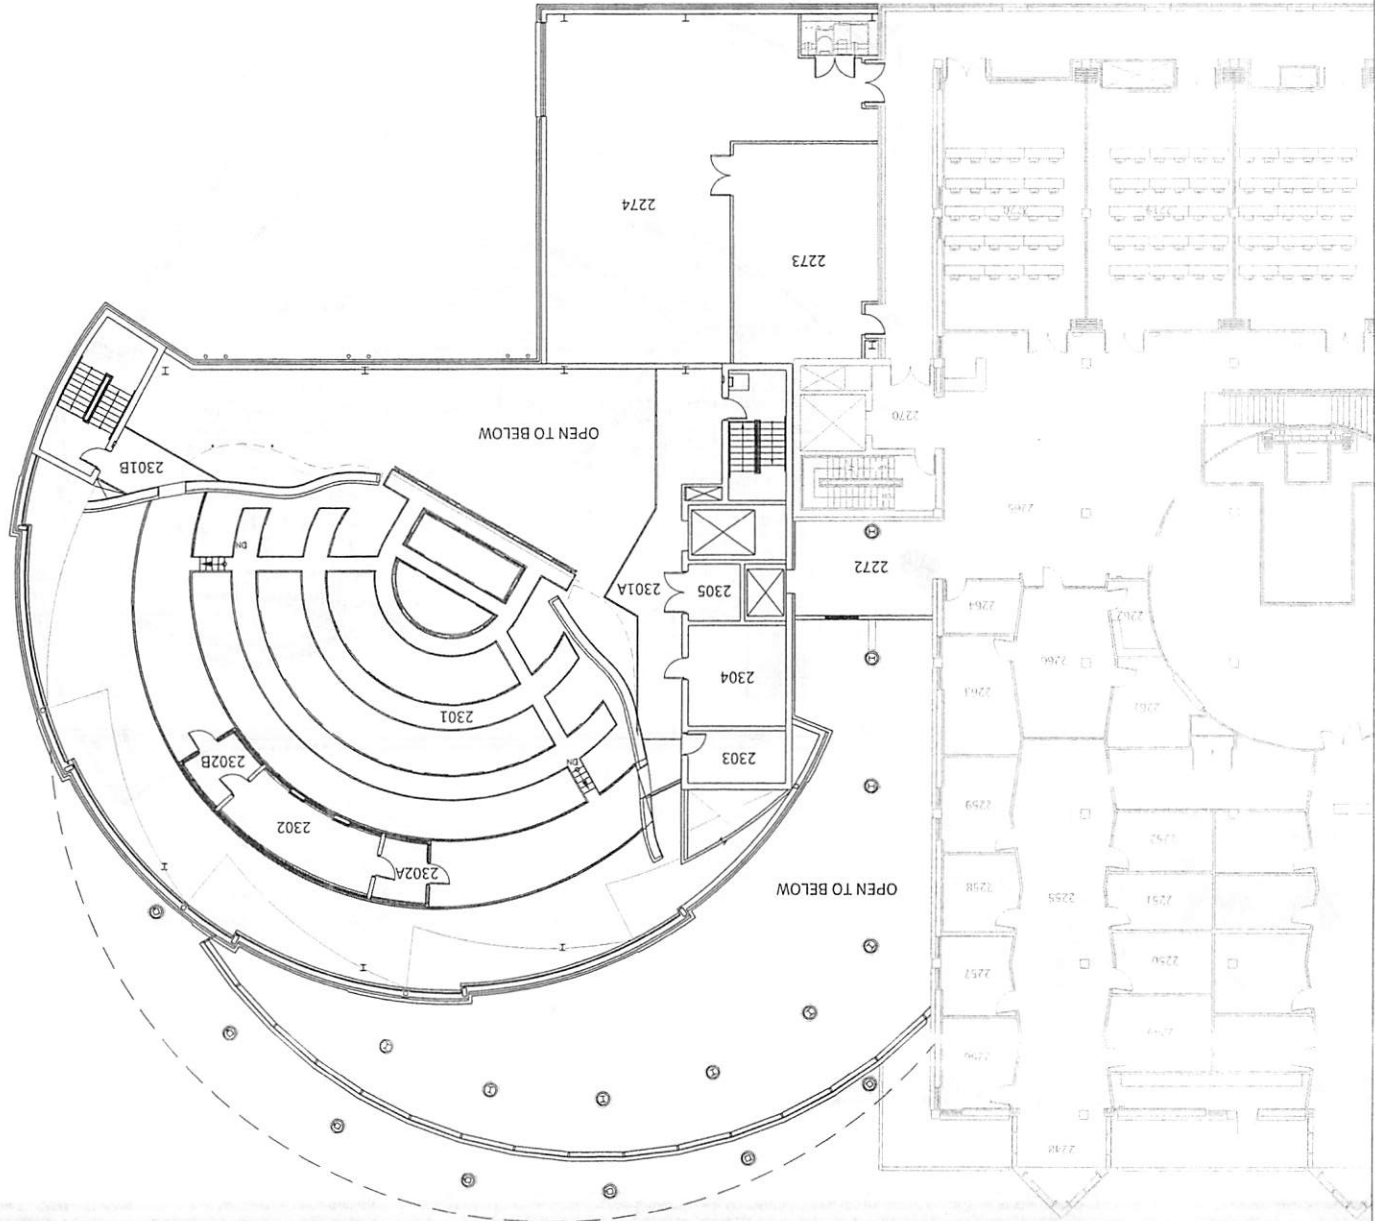







"Star" Indicates AED Location

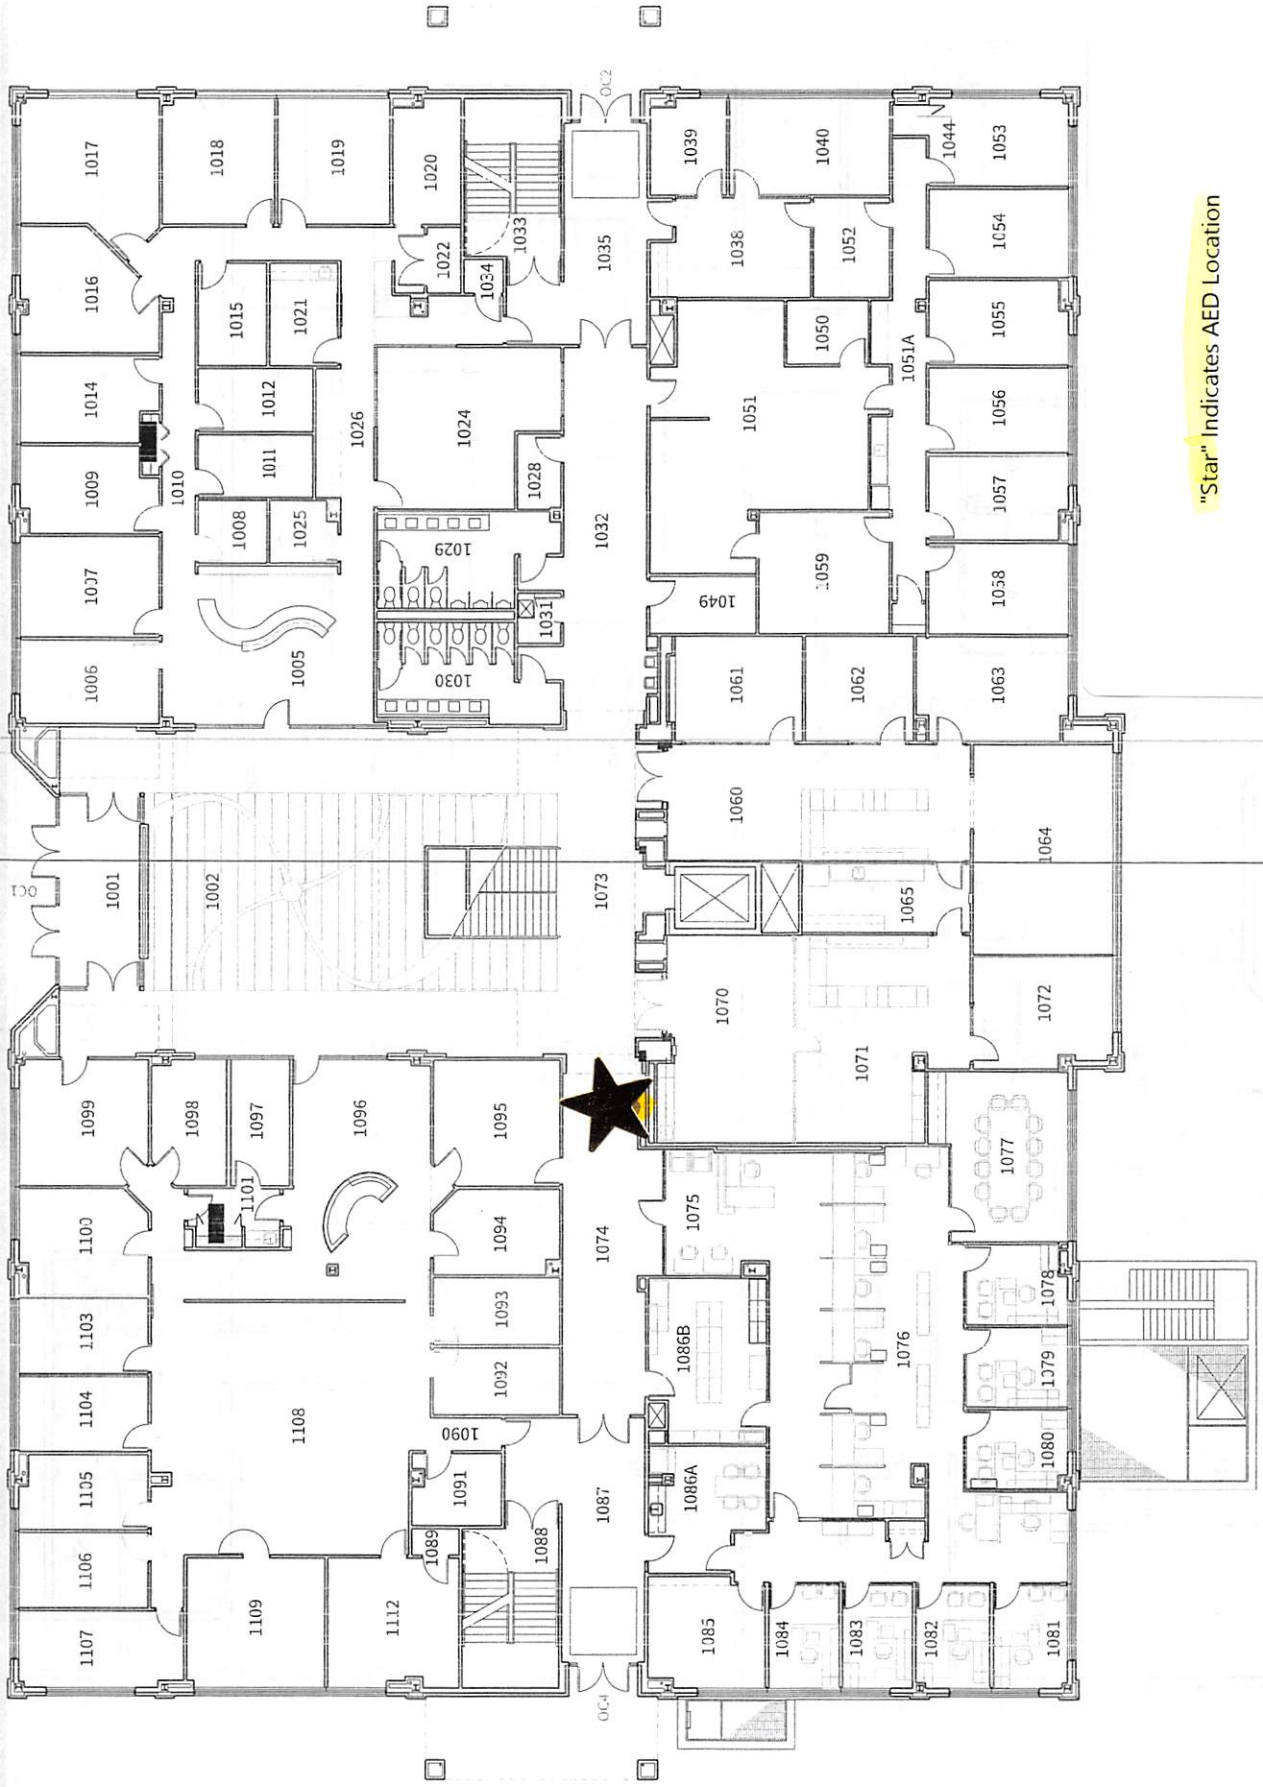

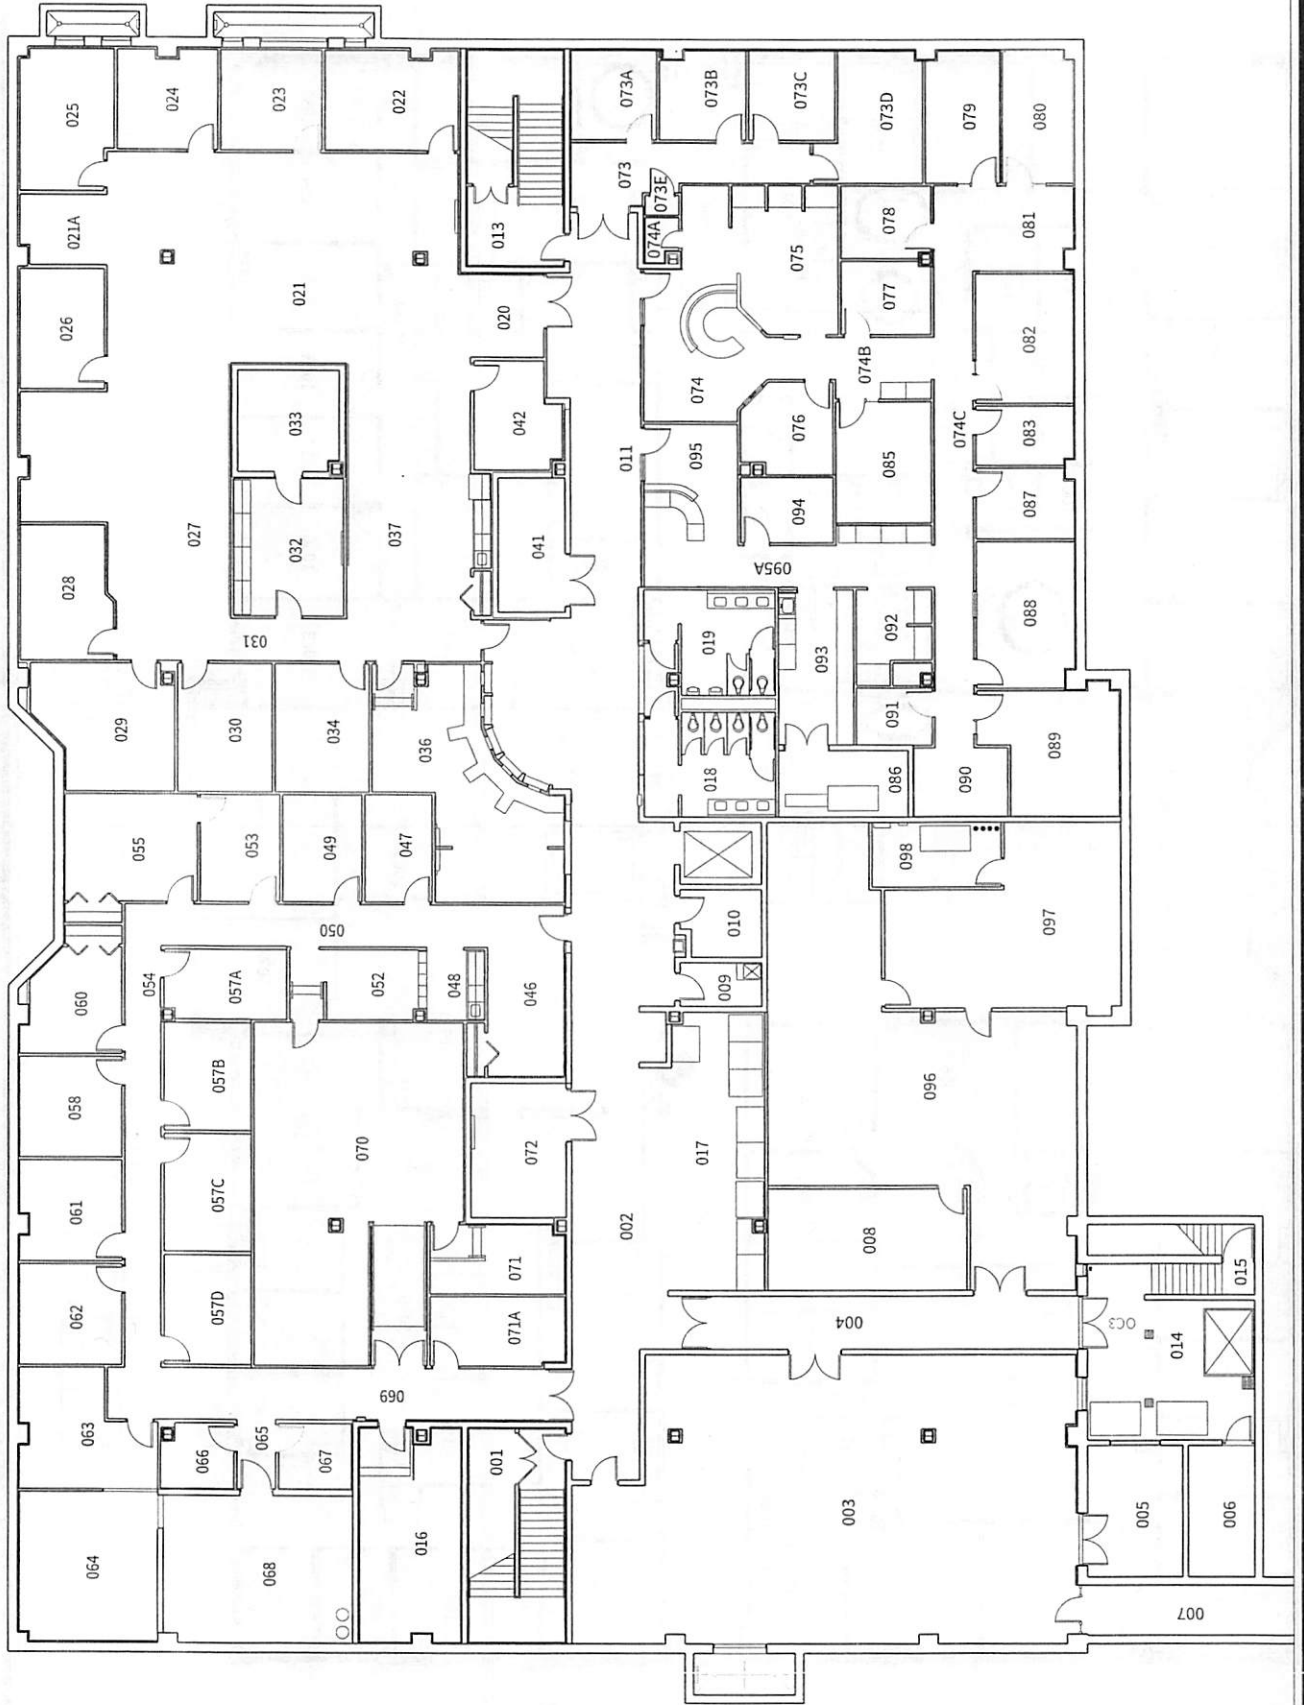


"Star" Indicates AED Location

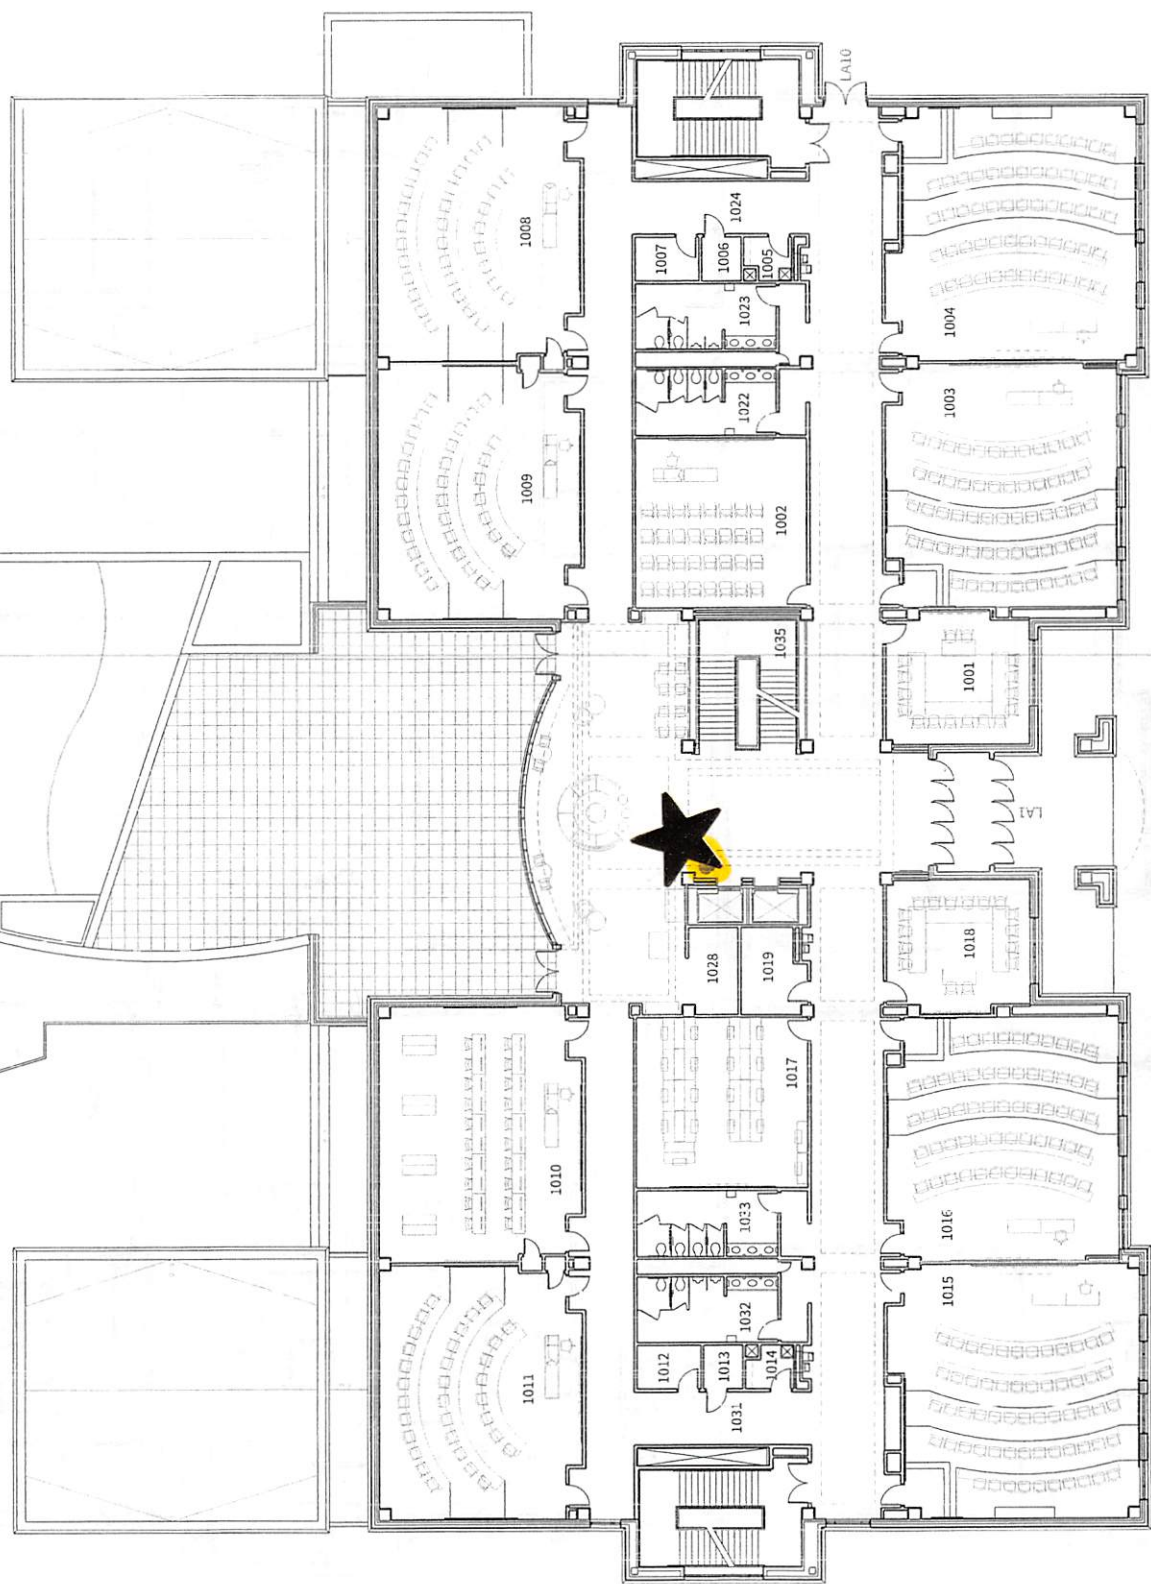




LIBERAL ARTS CENTER  
LA  
LOWER LEVEL FLOOR PLAN

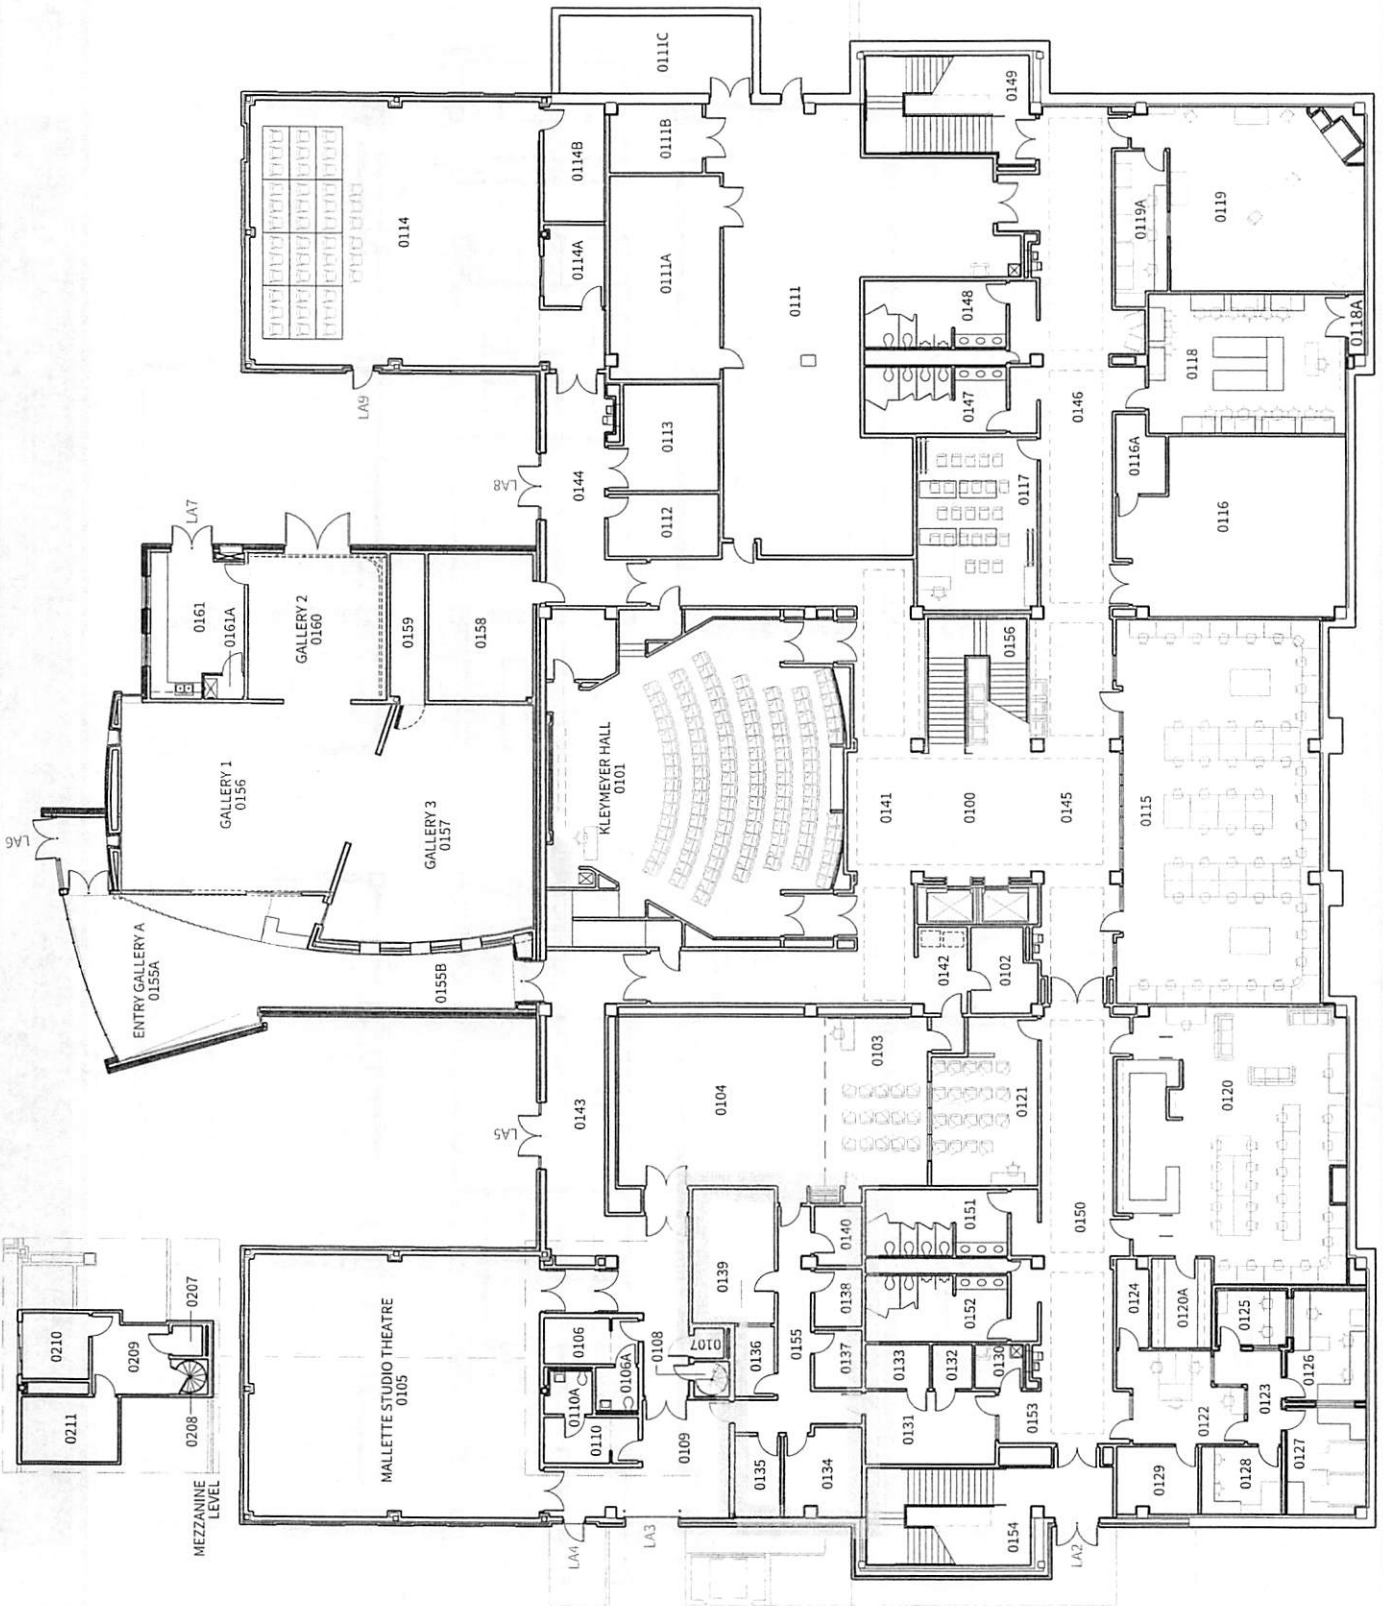


01.01.2022




"Star" Indicates AED Location

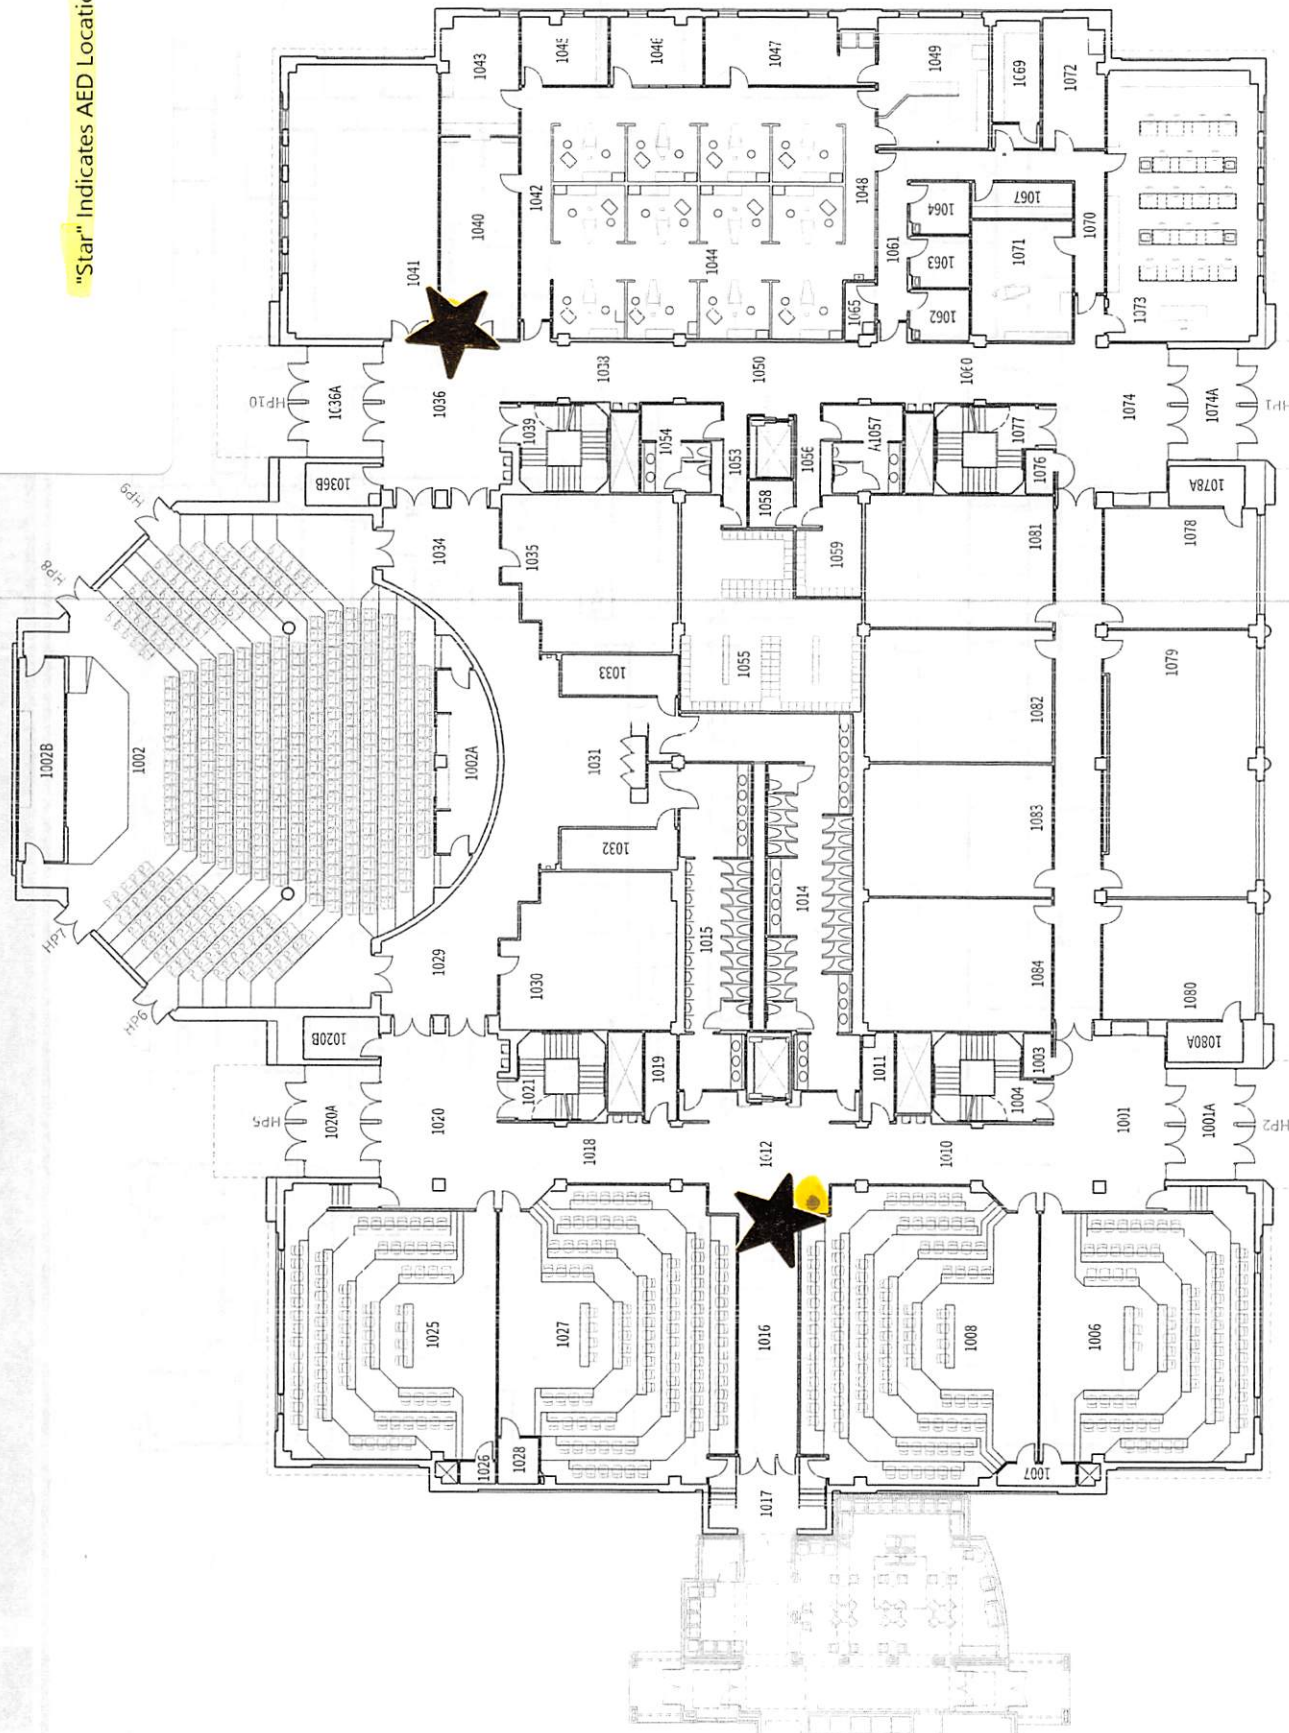

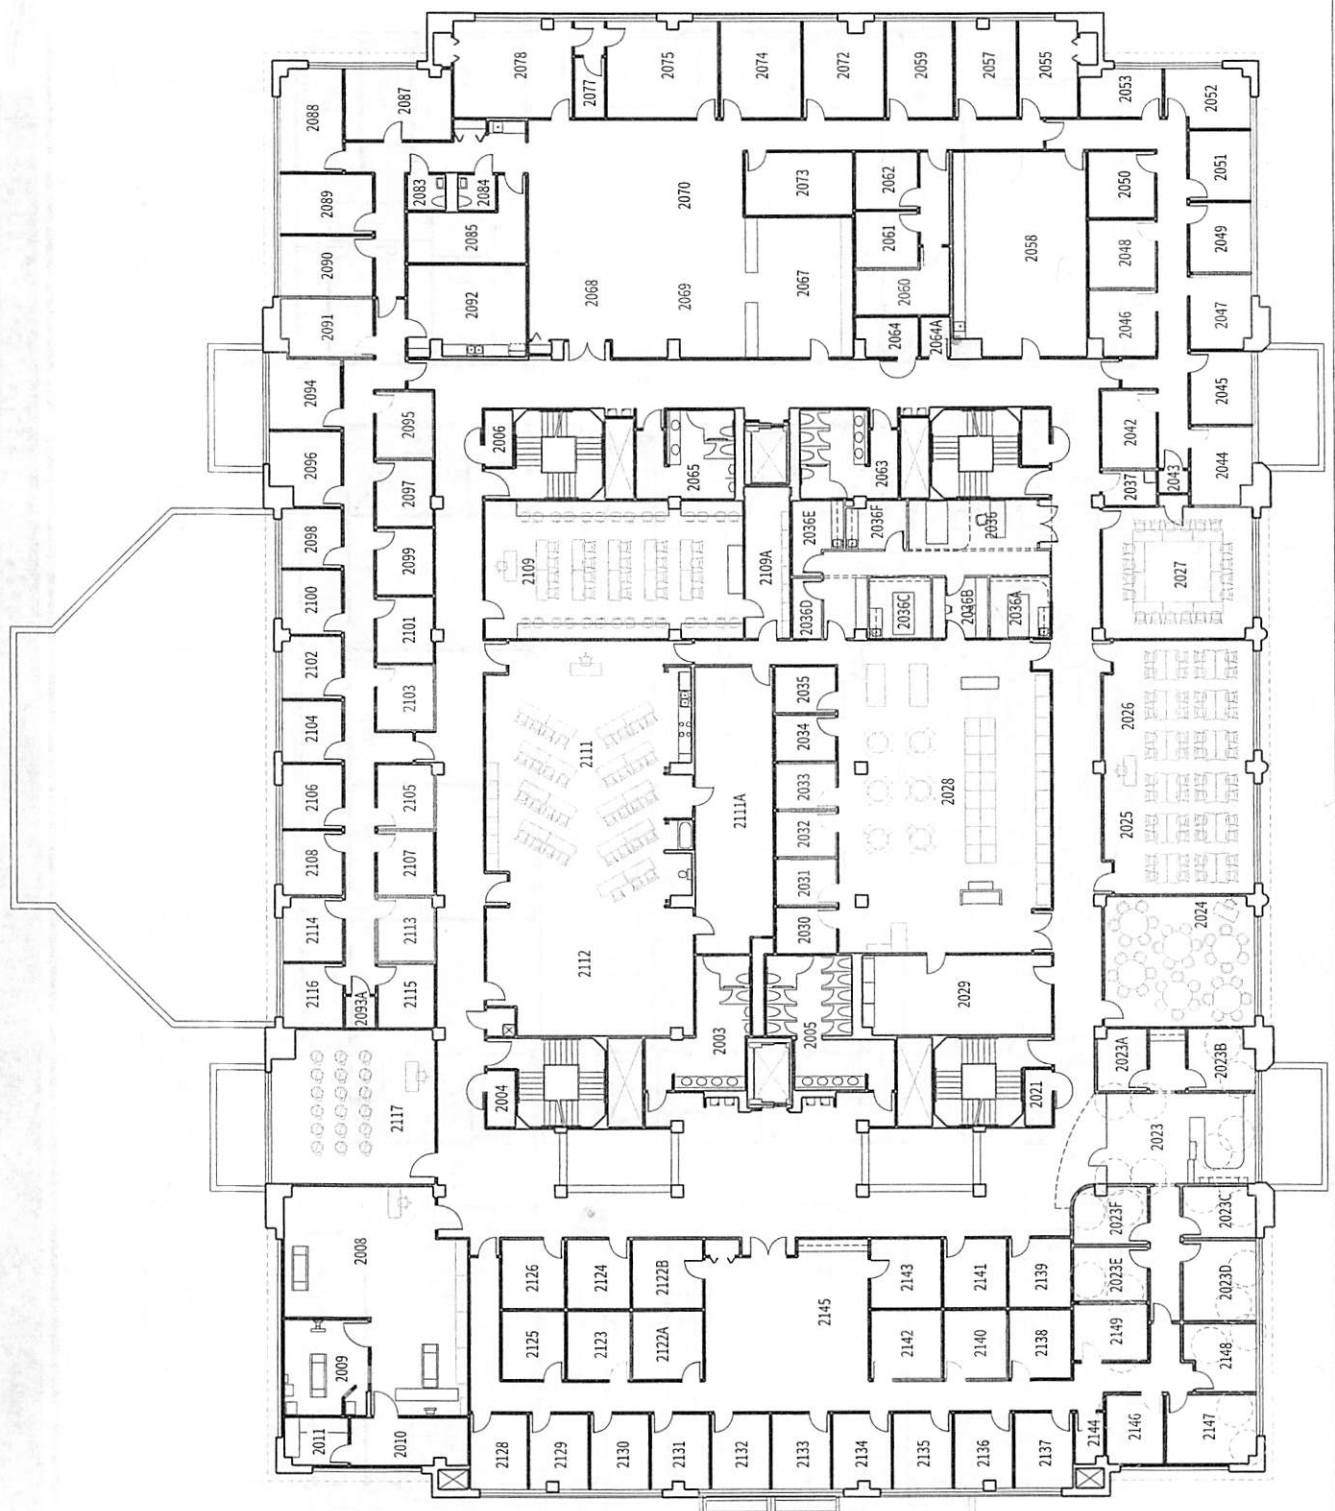




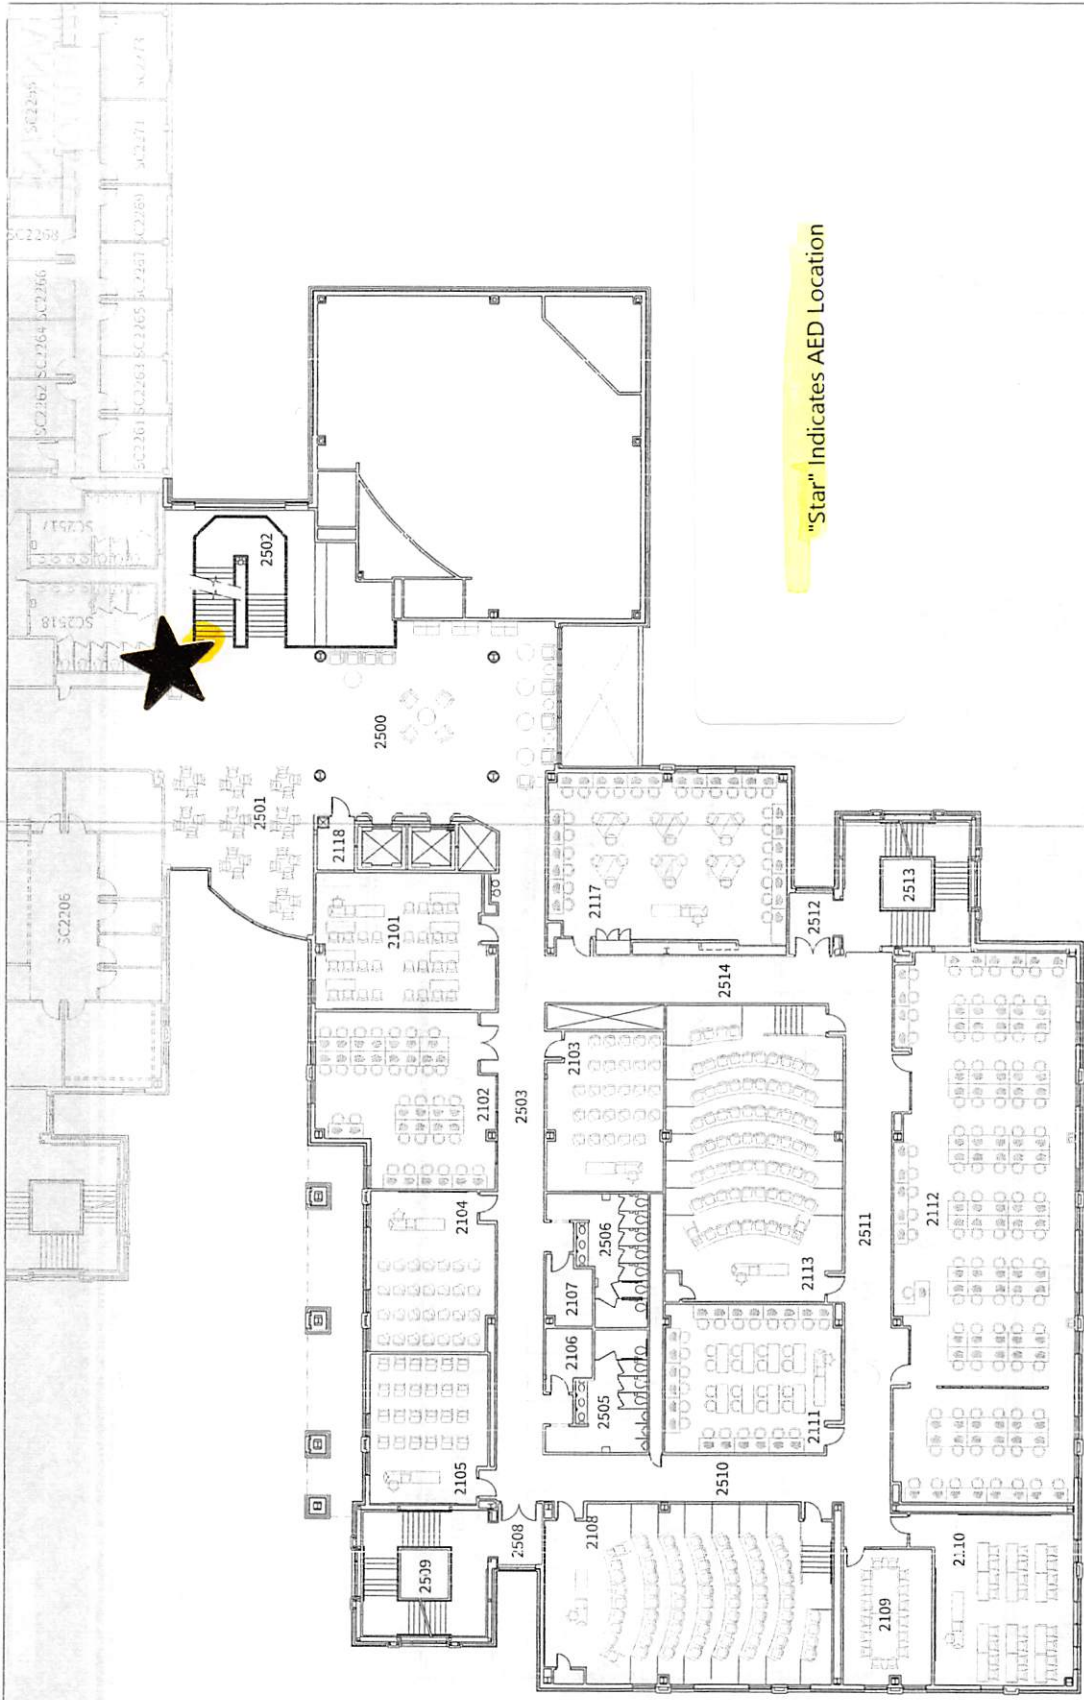


"Star" Indicates AED Location






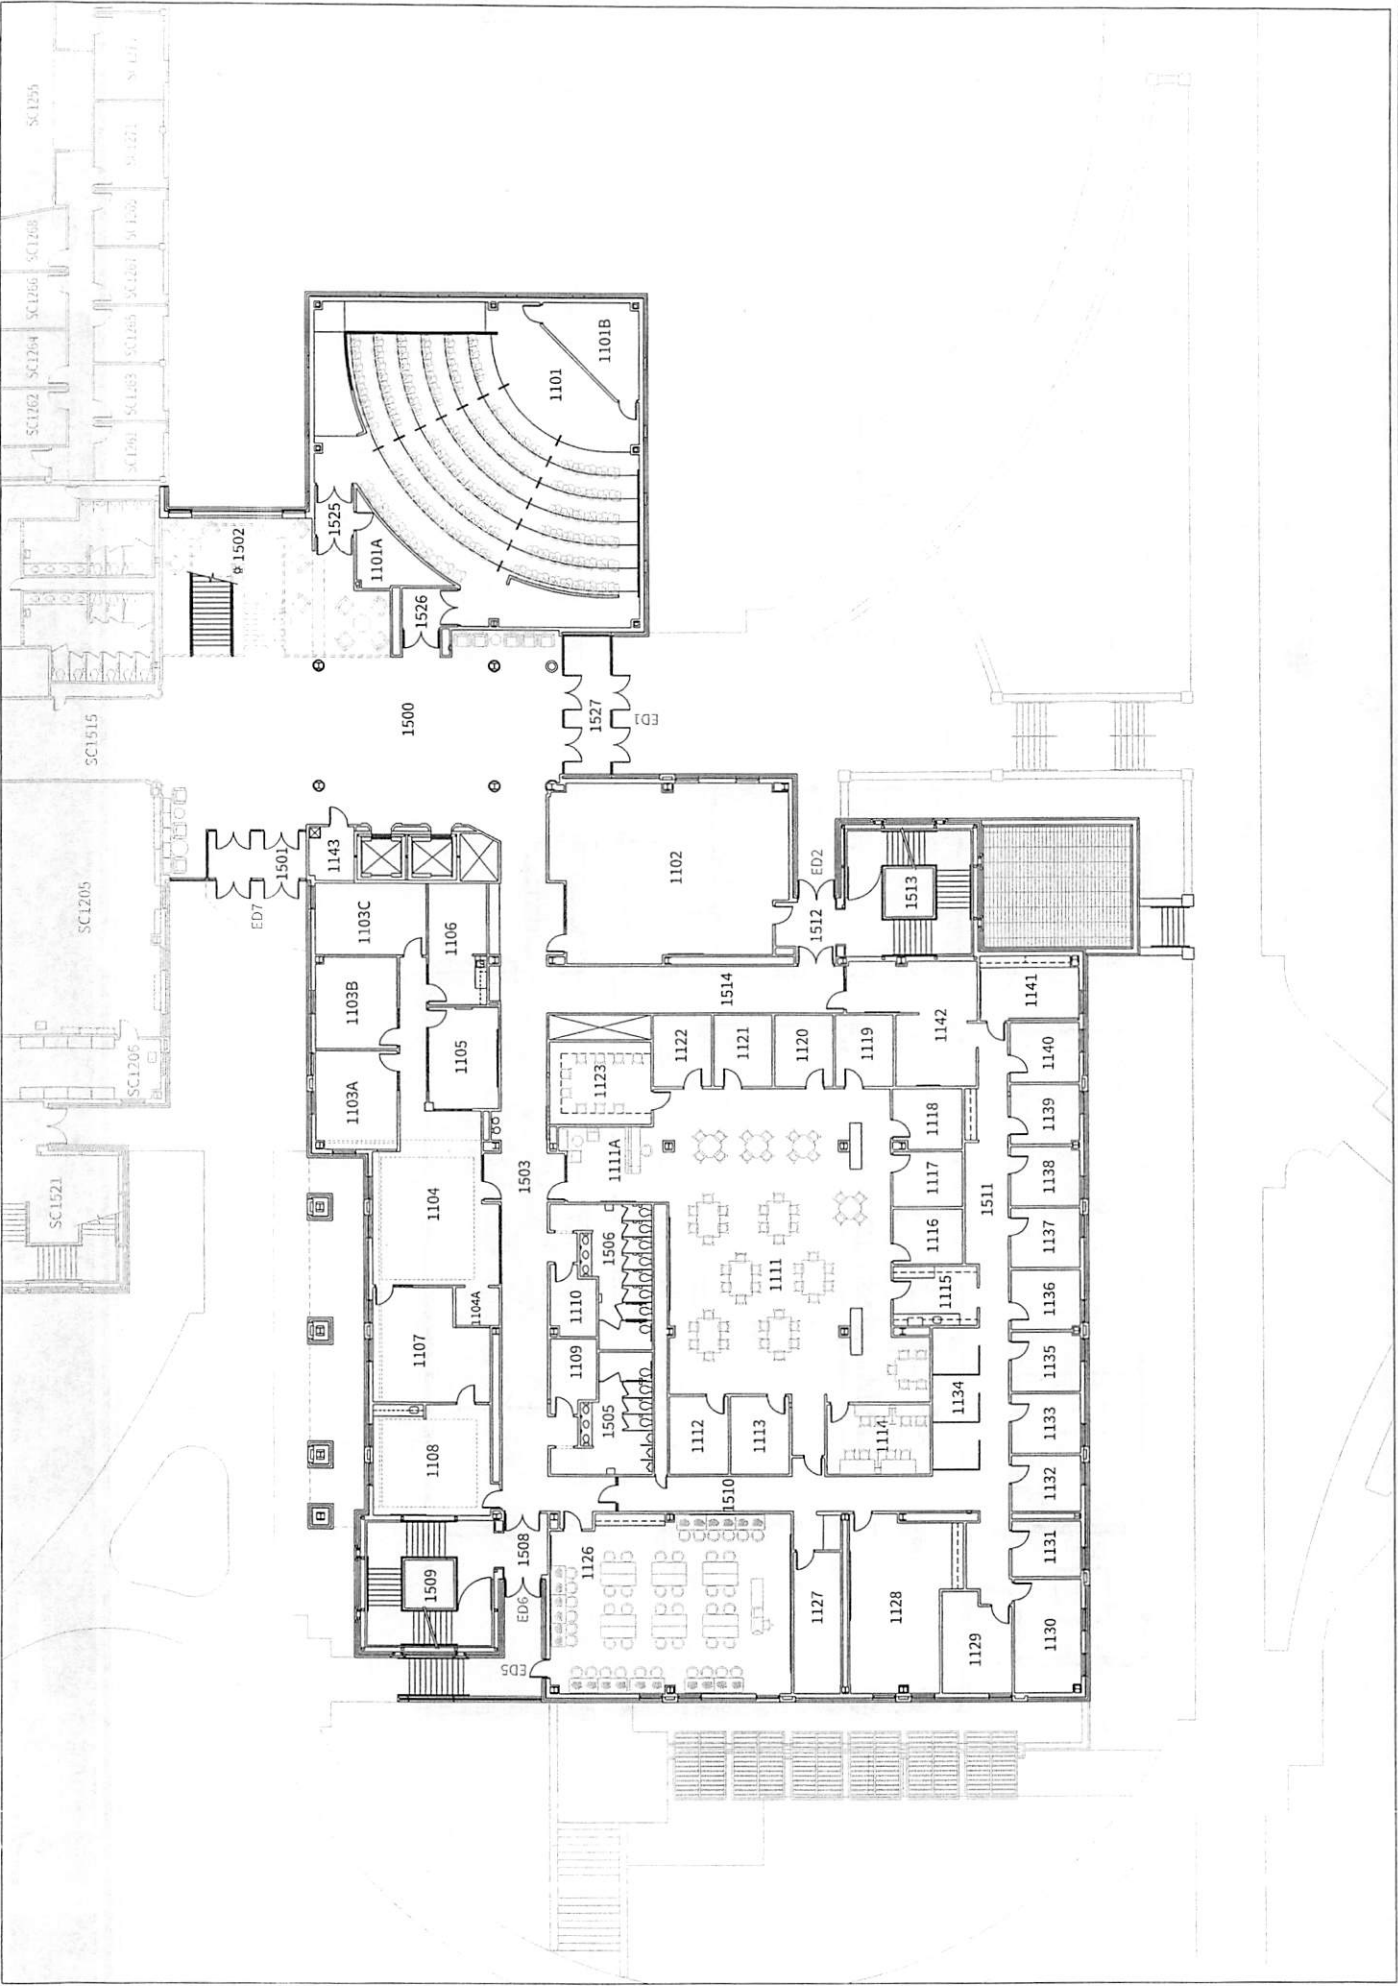


"Star" Indicates AED Location

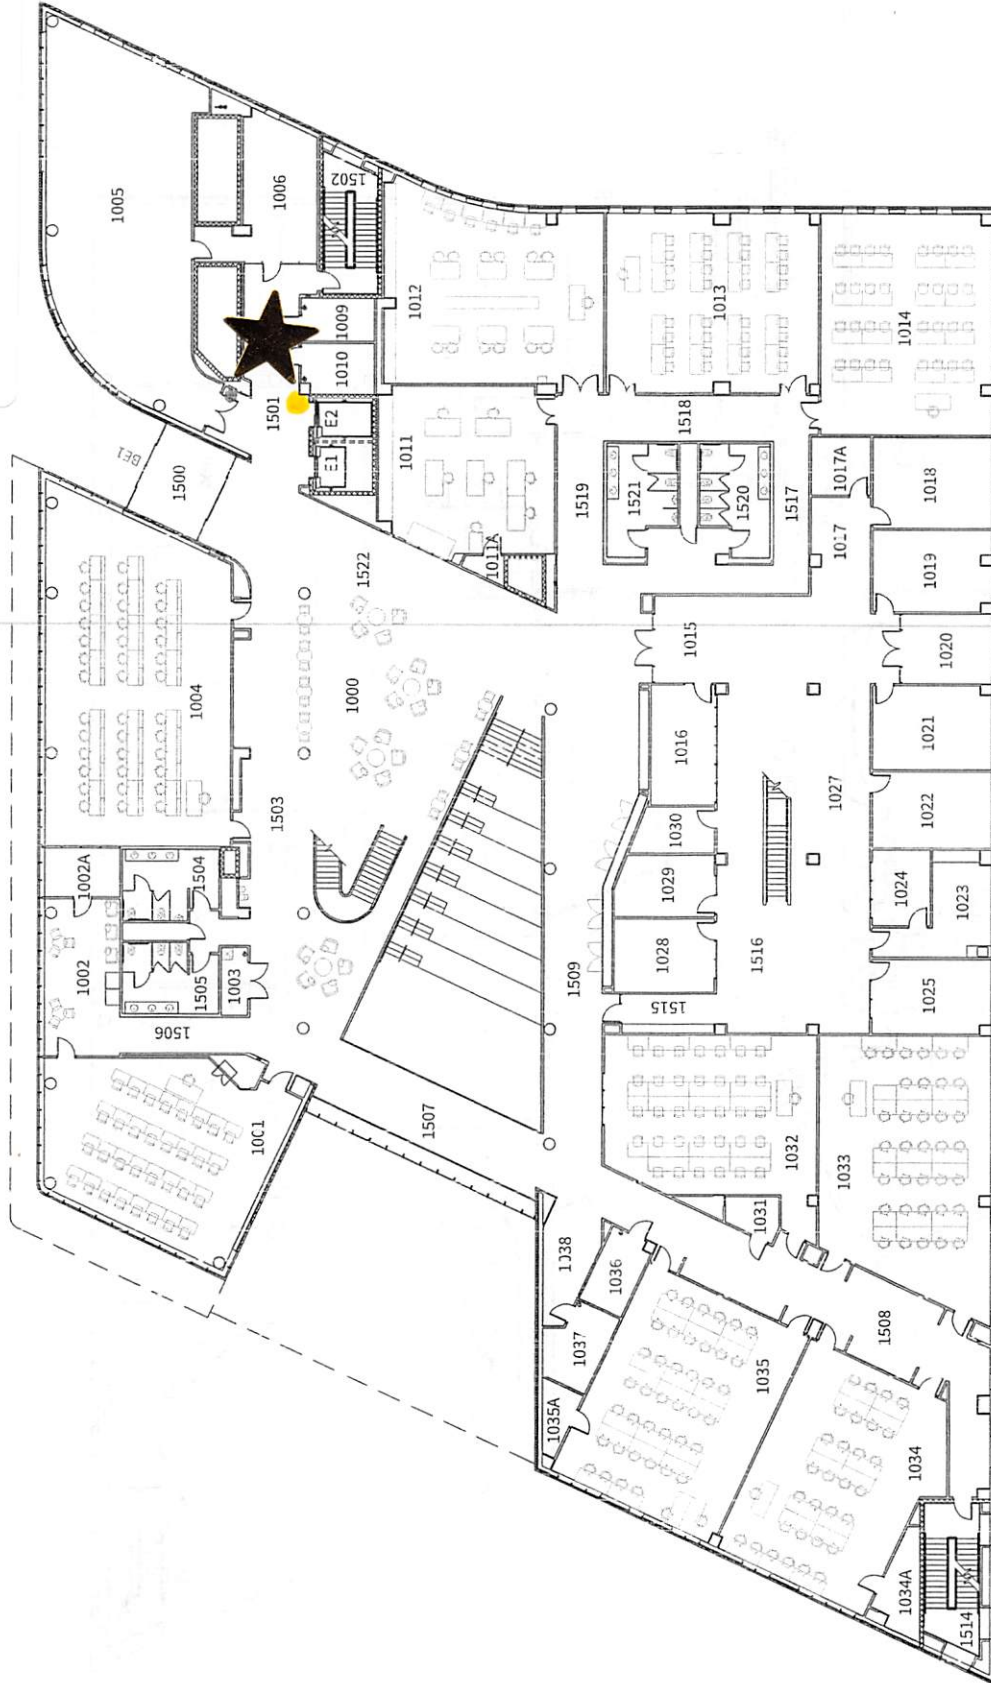


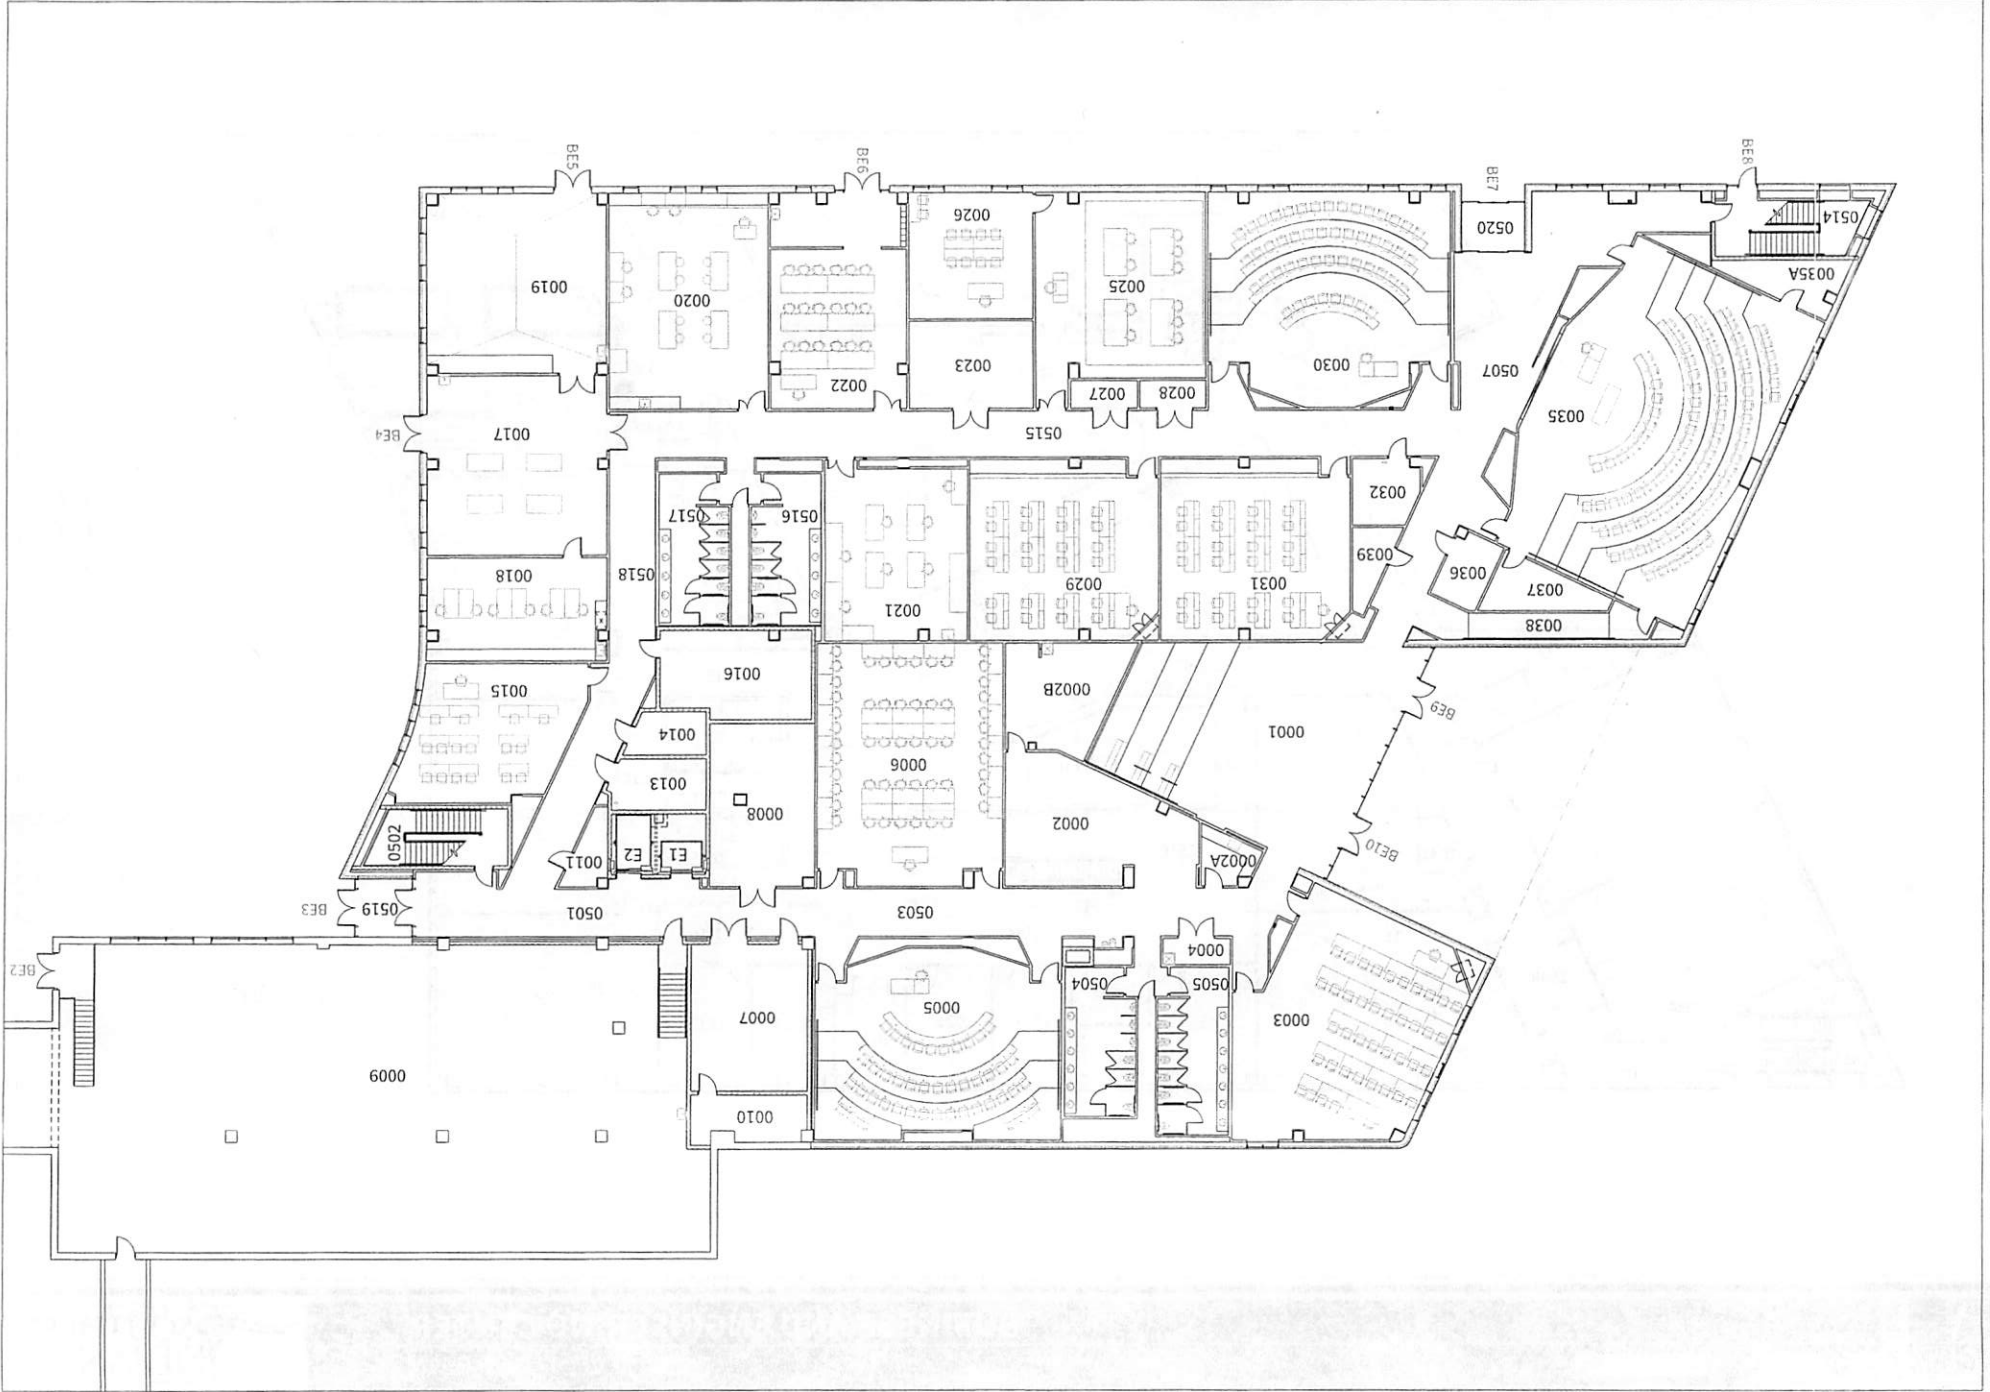



"Star" Indicates AED Location

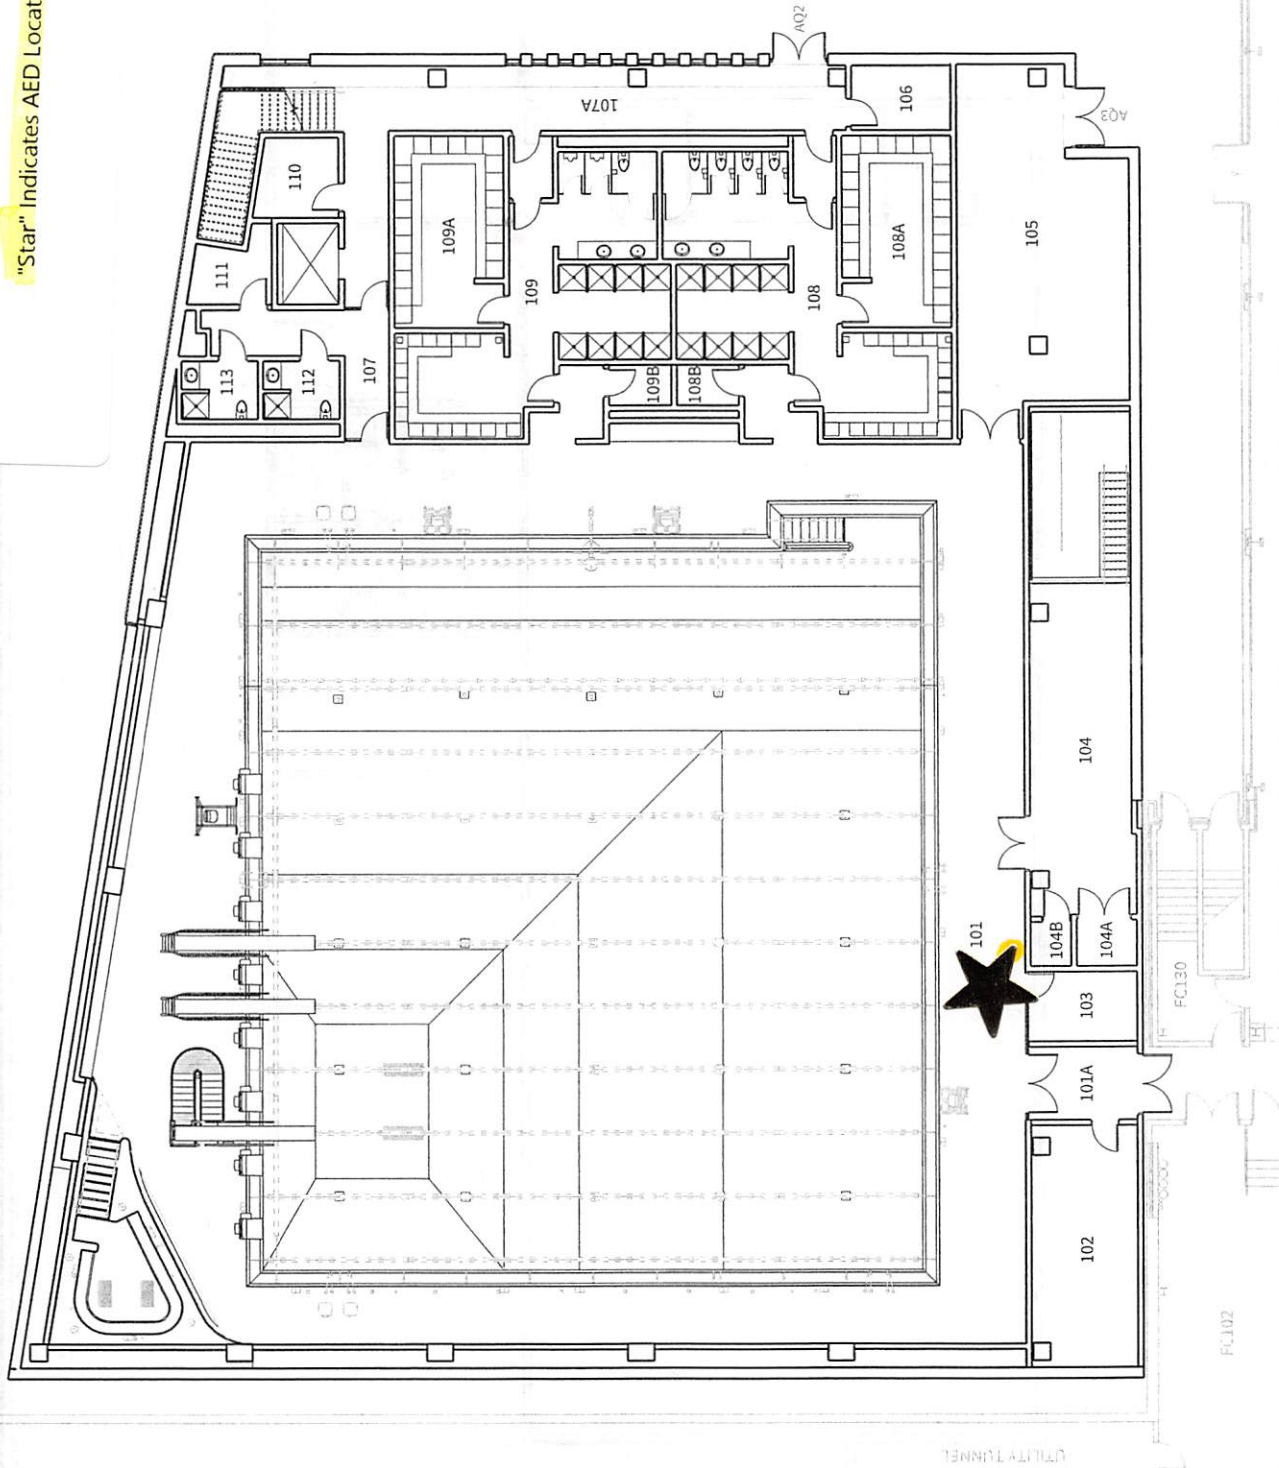


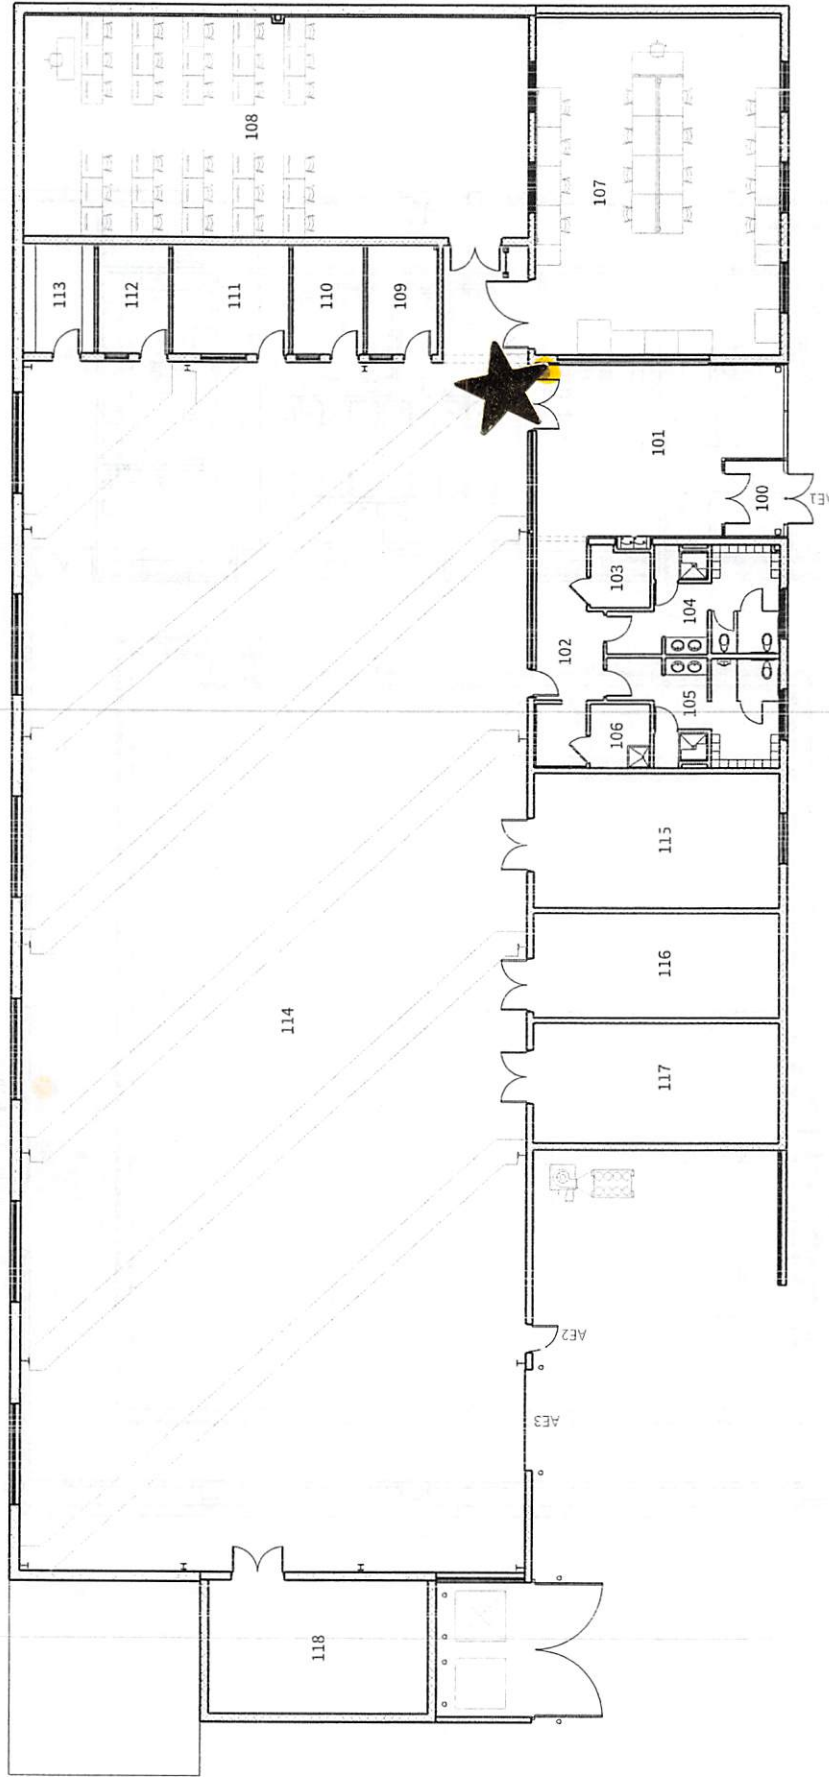


"Star" Indicates AED Location



"Star" Indicates AED Location

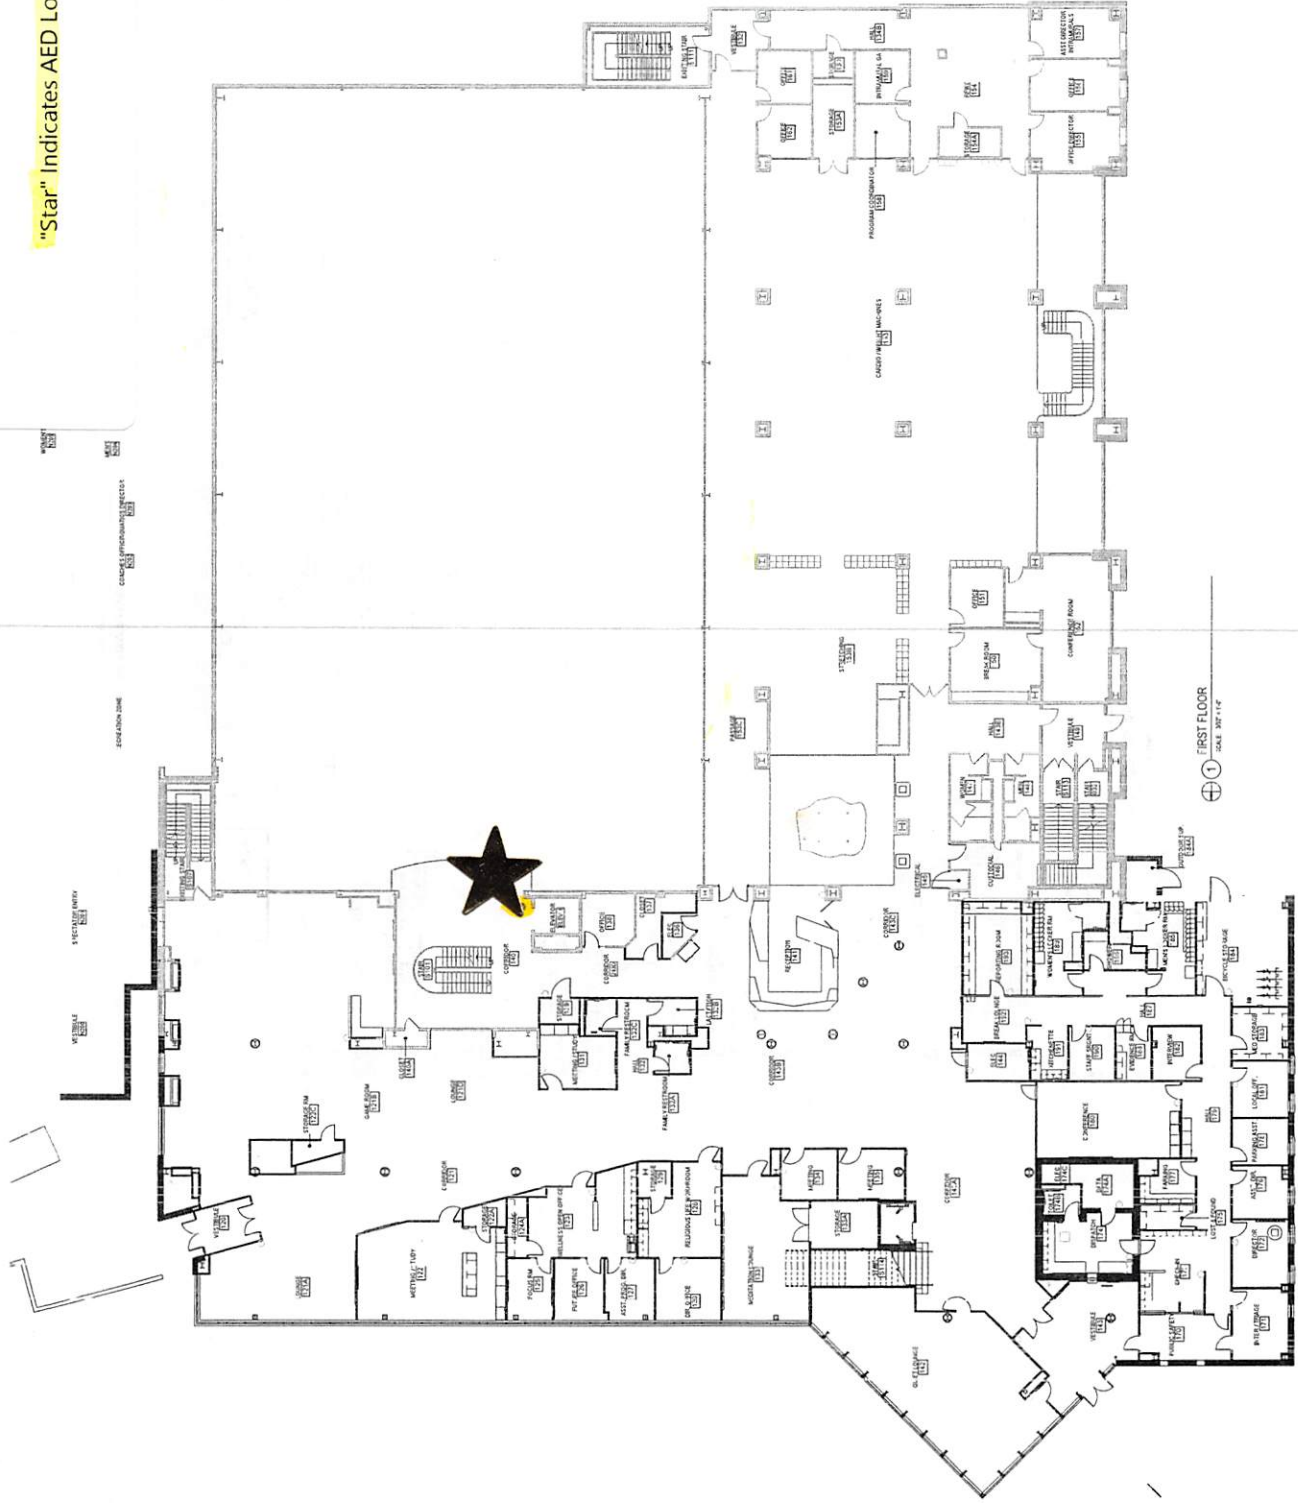




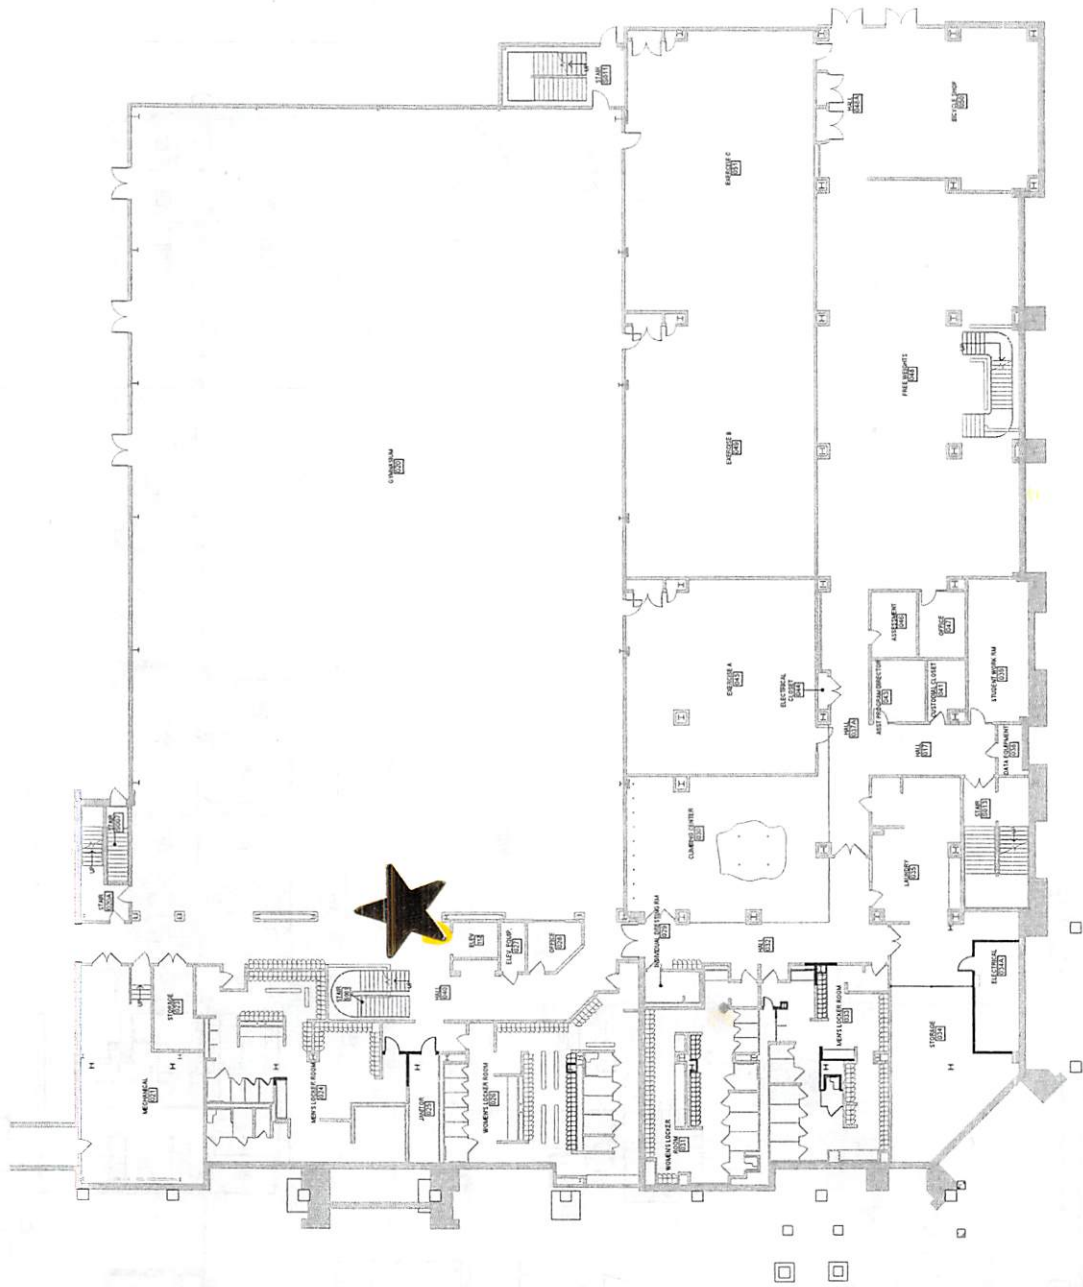


① LOWER LEVEL  
SCALE: 1/8" = 1'-0"

"Star" Indicates AED Location


"Star" Indicates AED Location

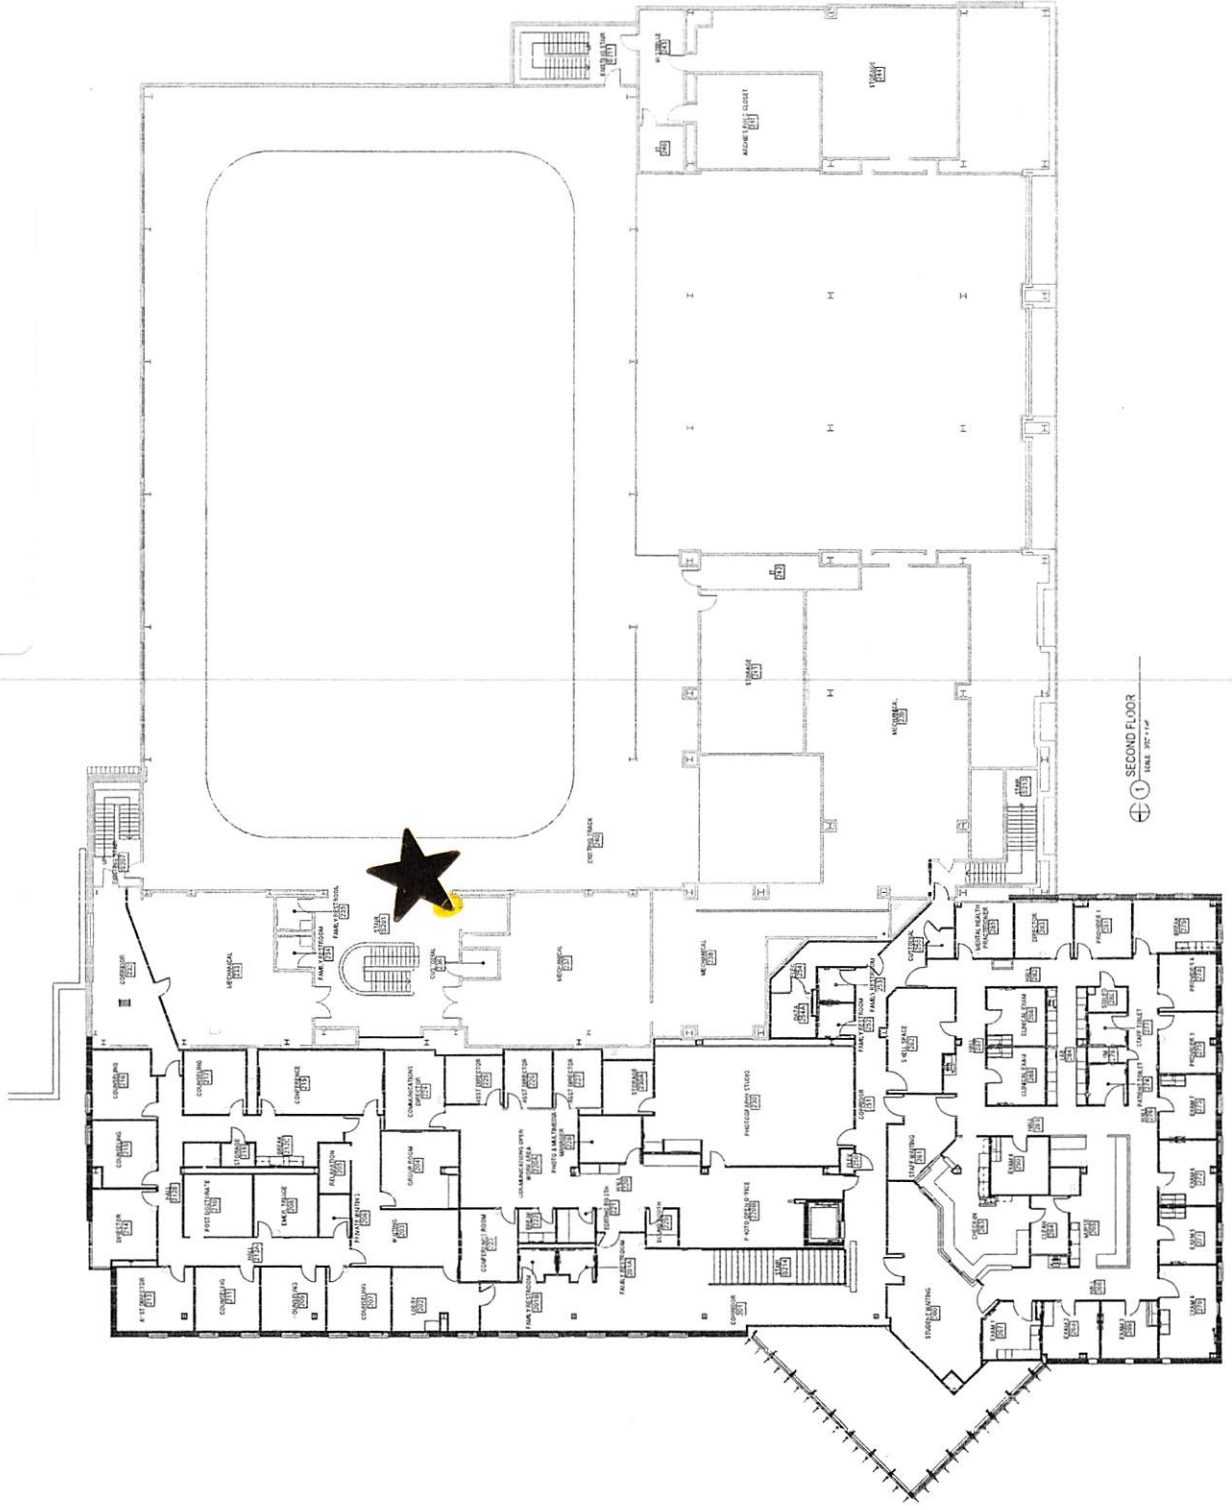

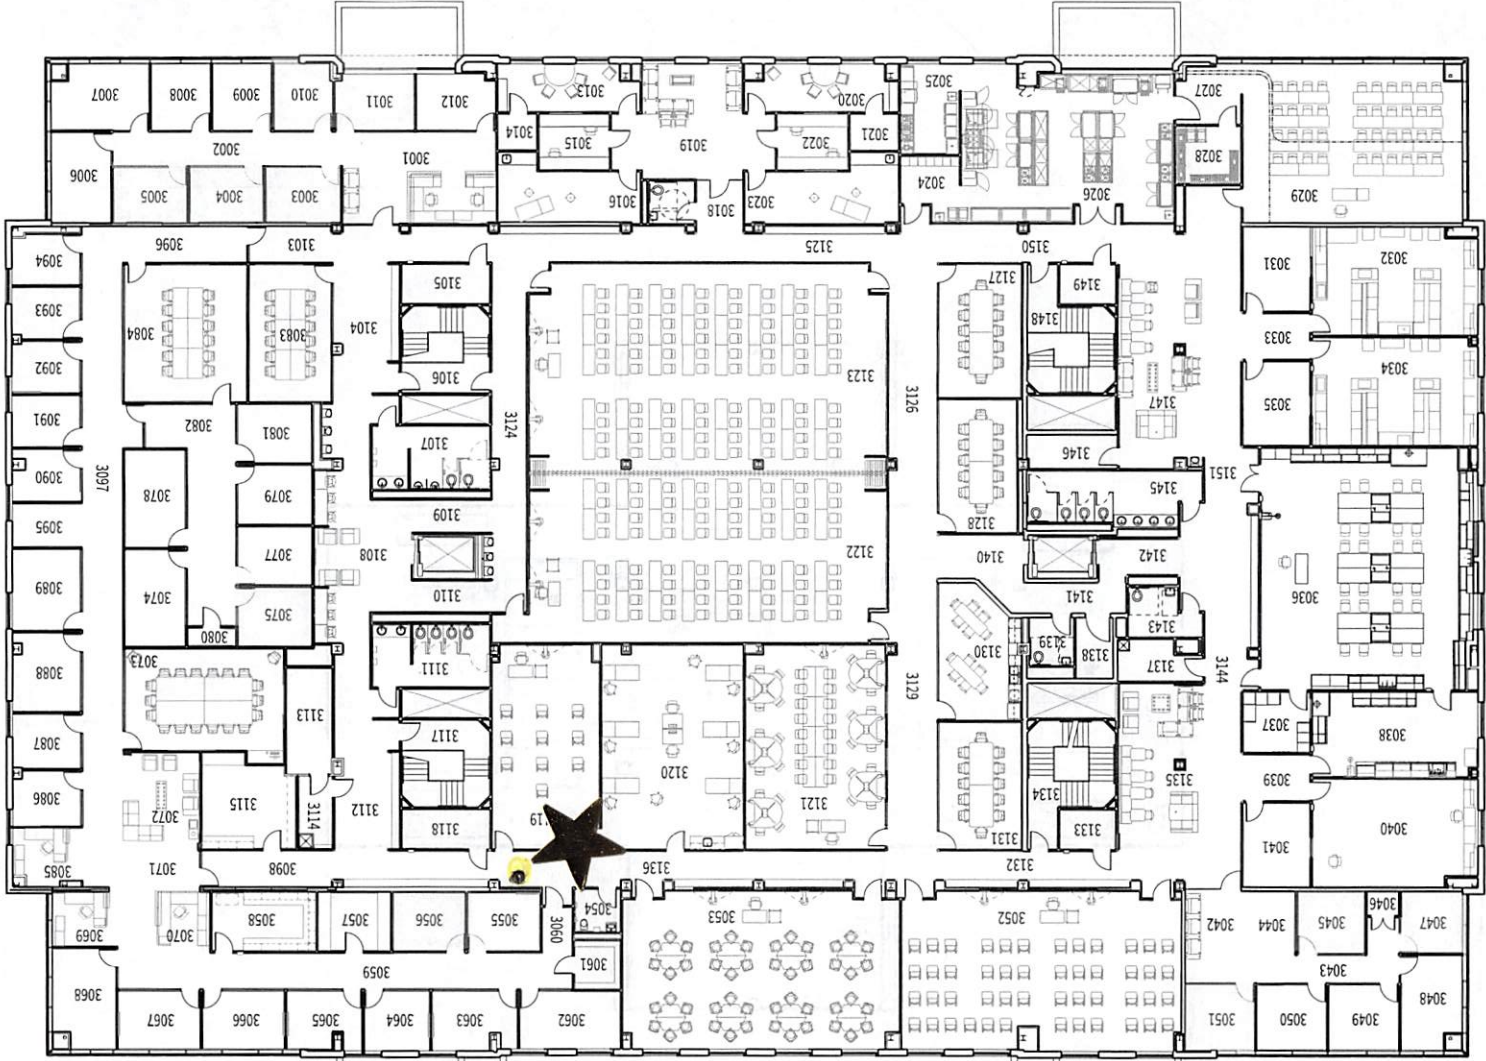

"Star" Indicates AED Location



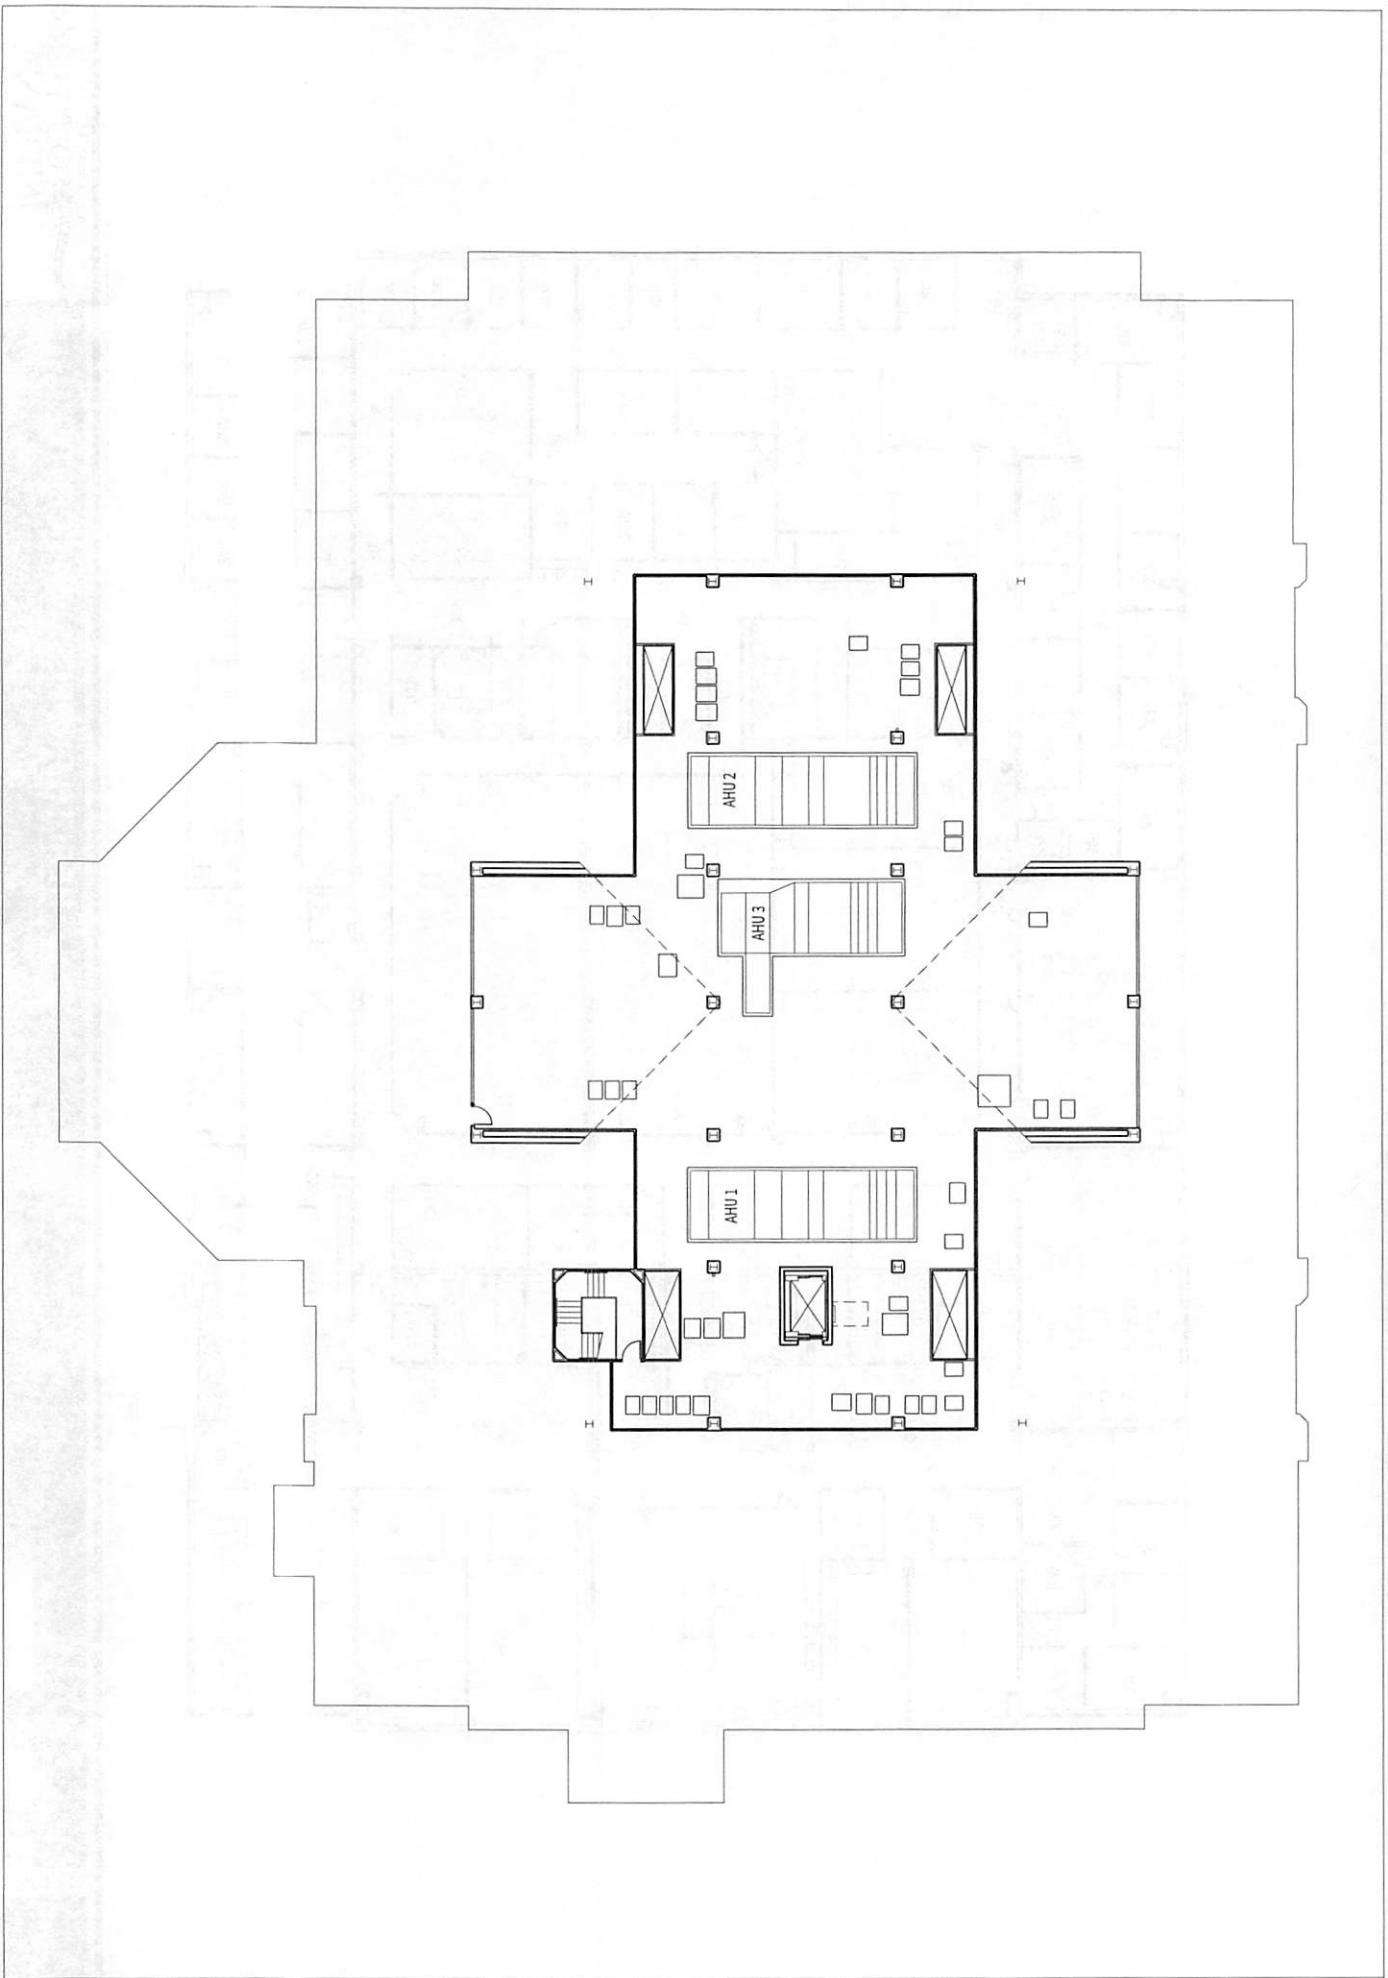

★ 2 mobile aeds on rolling carts  
Zell 3



